


FIRST FLOOR – DUCTWORK
SCALE: 1/8"=1'-0"

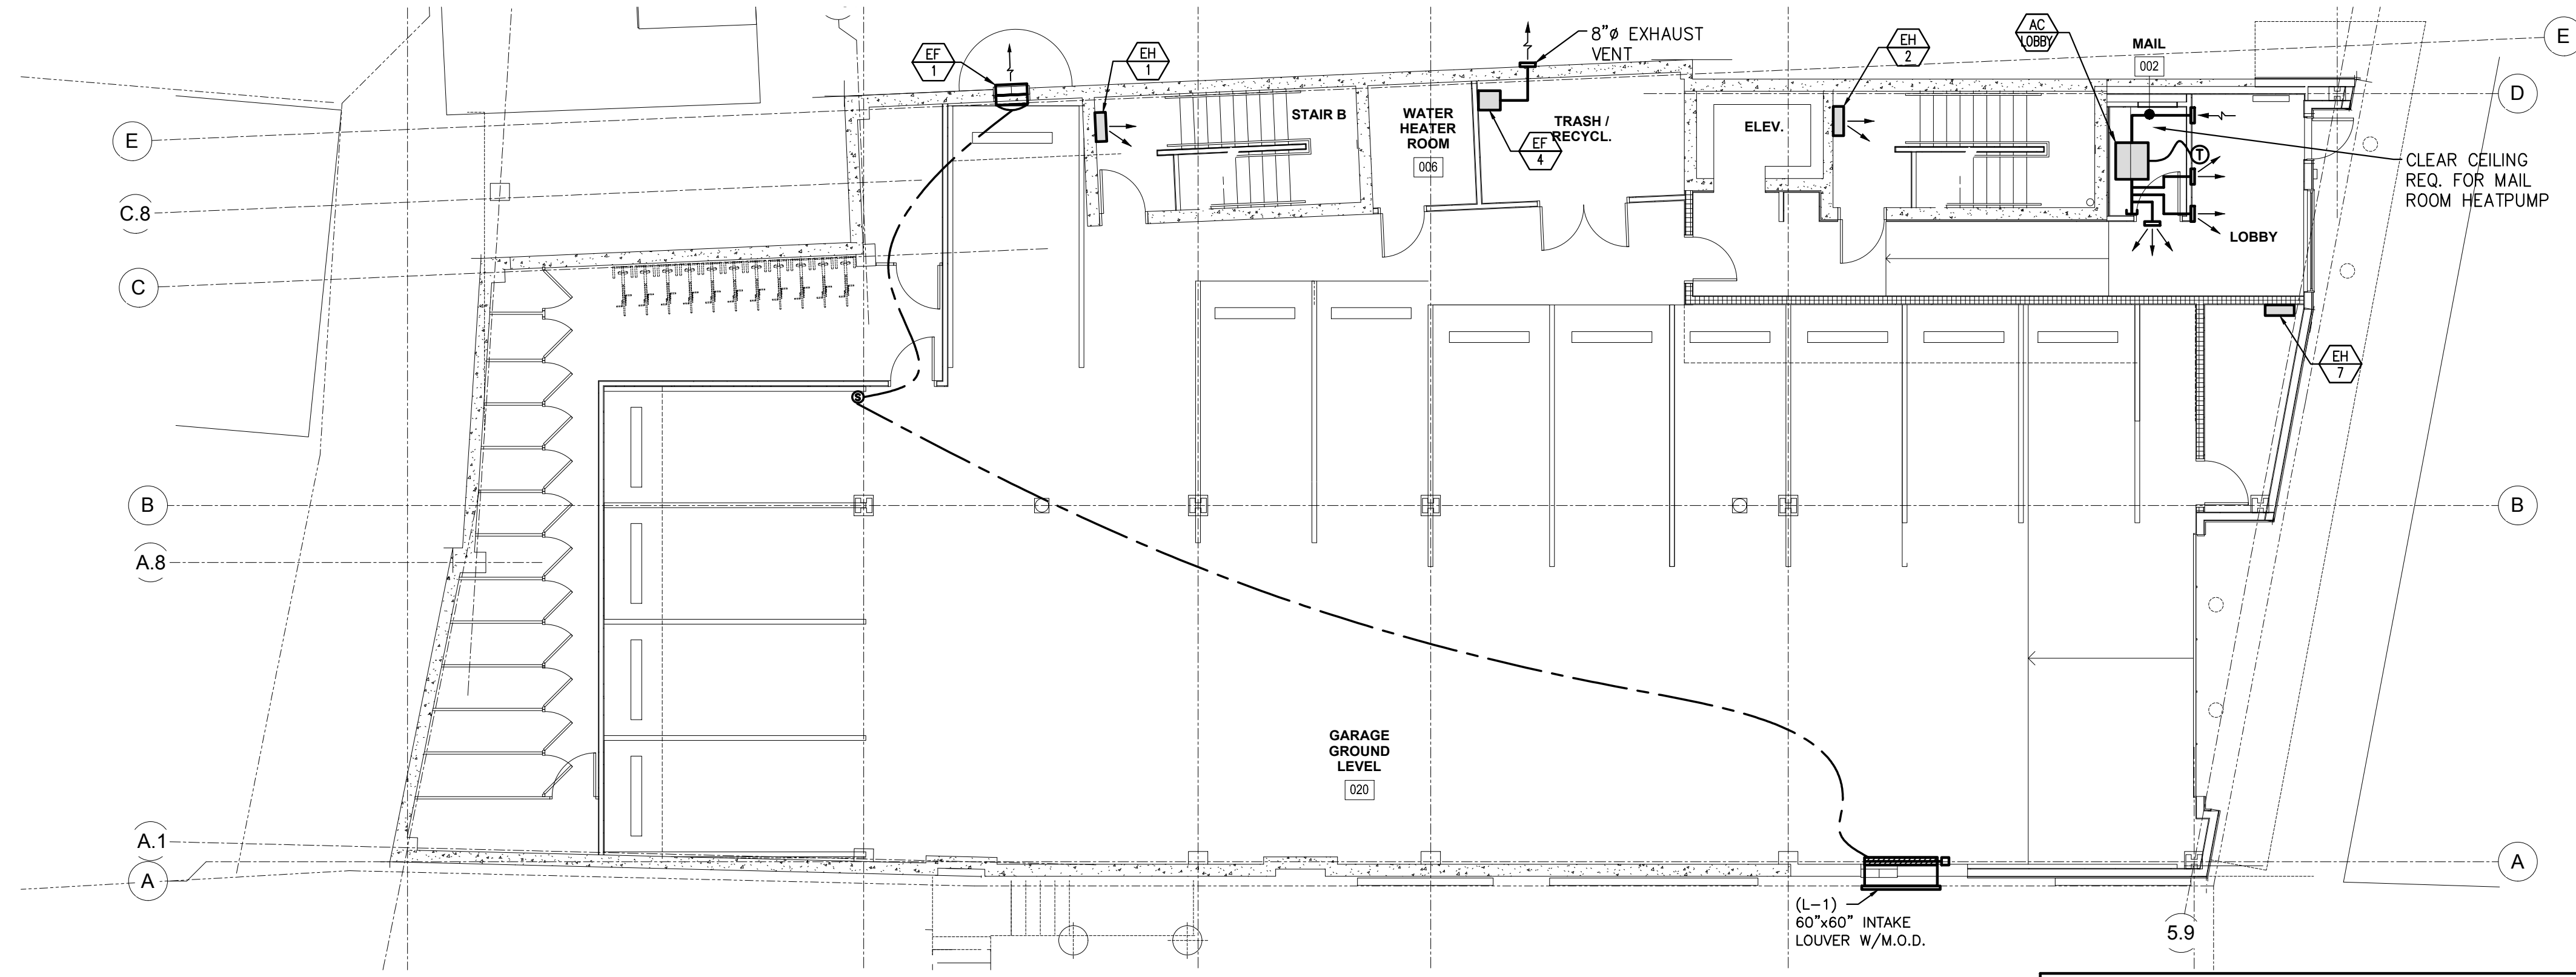

BASEMENT FLOOR – DUCTWORK
SCALE: 1/8"=1'-0"

Design • Build • Install • Service

HVAC SERVICES, INC.

73 BRADLEY DRIVE
WESTBROOK, MAINE 04092
(207) 854-HVAC (4822)

REVISIONS	
NO.	NOTES

PROJECT:		LUMINATO NEWBURY STREET PORTLAND, MAINE
SHEET TITLE:		1ST & BASEMENT FLOOR DUCTWORK PLANS
SCALE: 1/8"=1'-0"	DATE: 11-22-2016	
DRAWN BY: A2Z CADD DRAFTING SERVICES, INC.	SHEET No.	M-1
CHECKED BY:		
XX		