


3RD FLOOR - DUCTWORK


SCALE: 1/8"=1'-0"

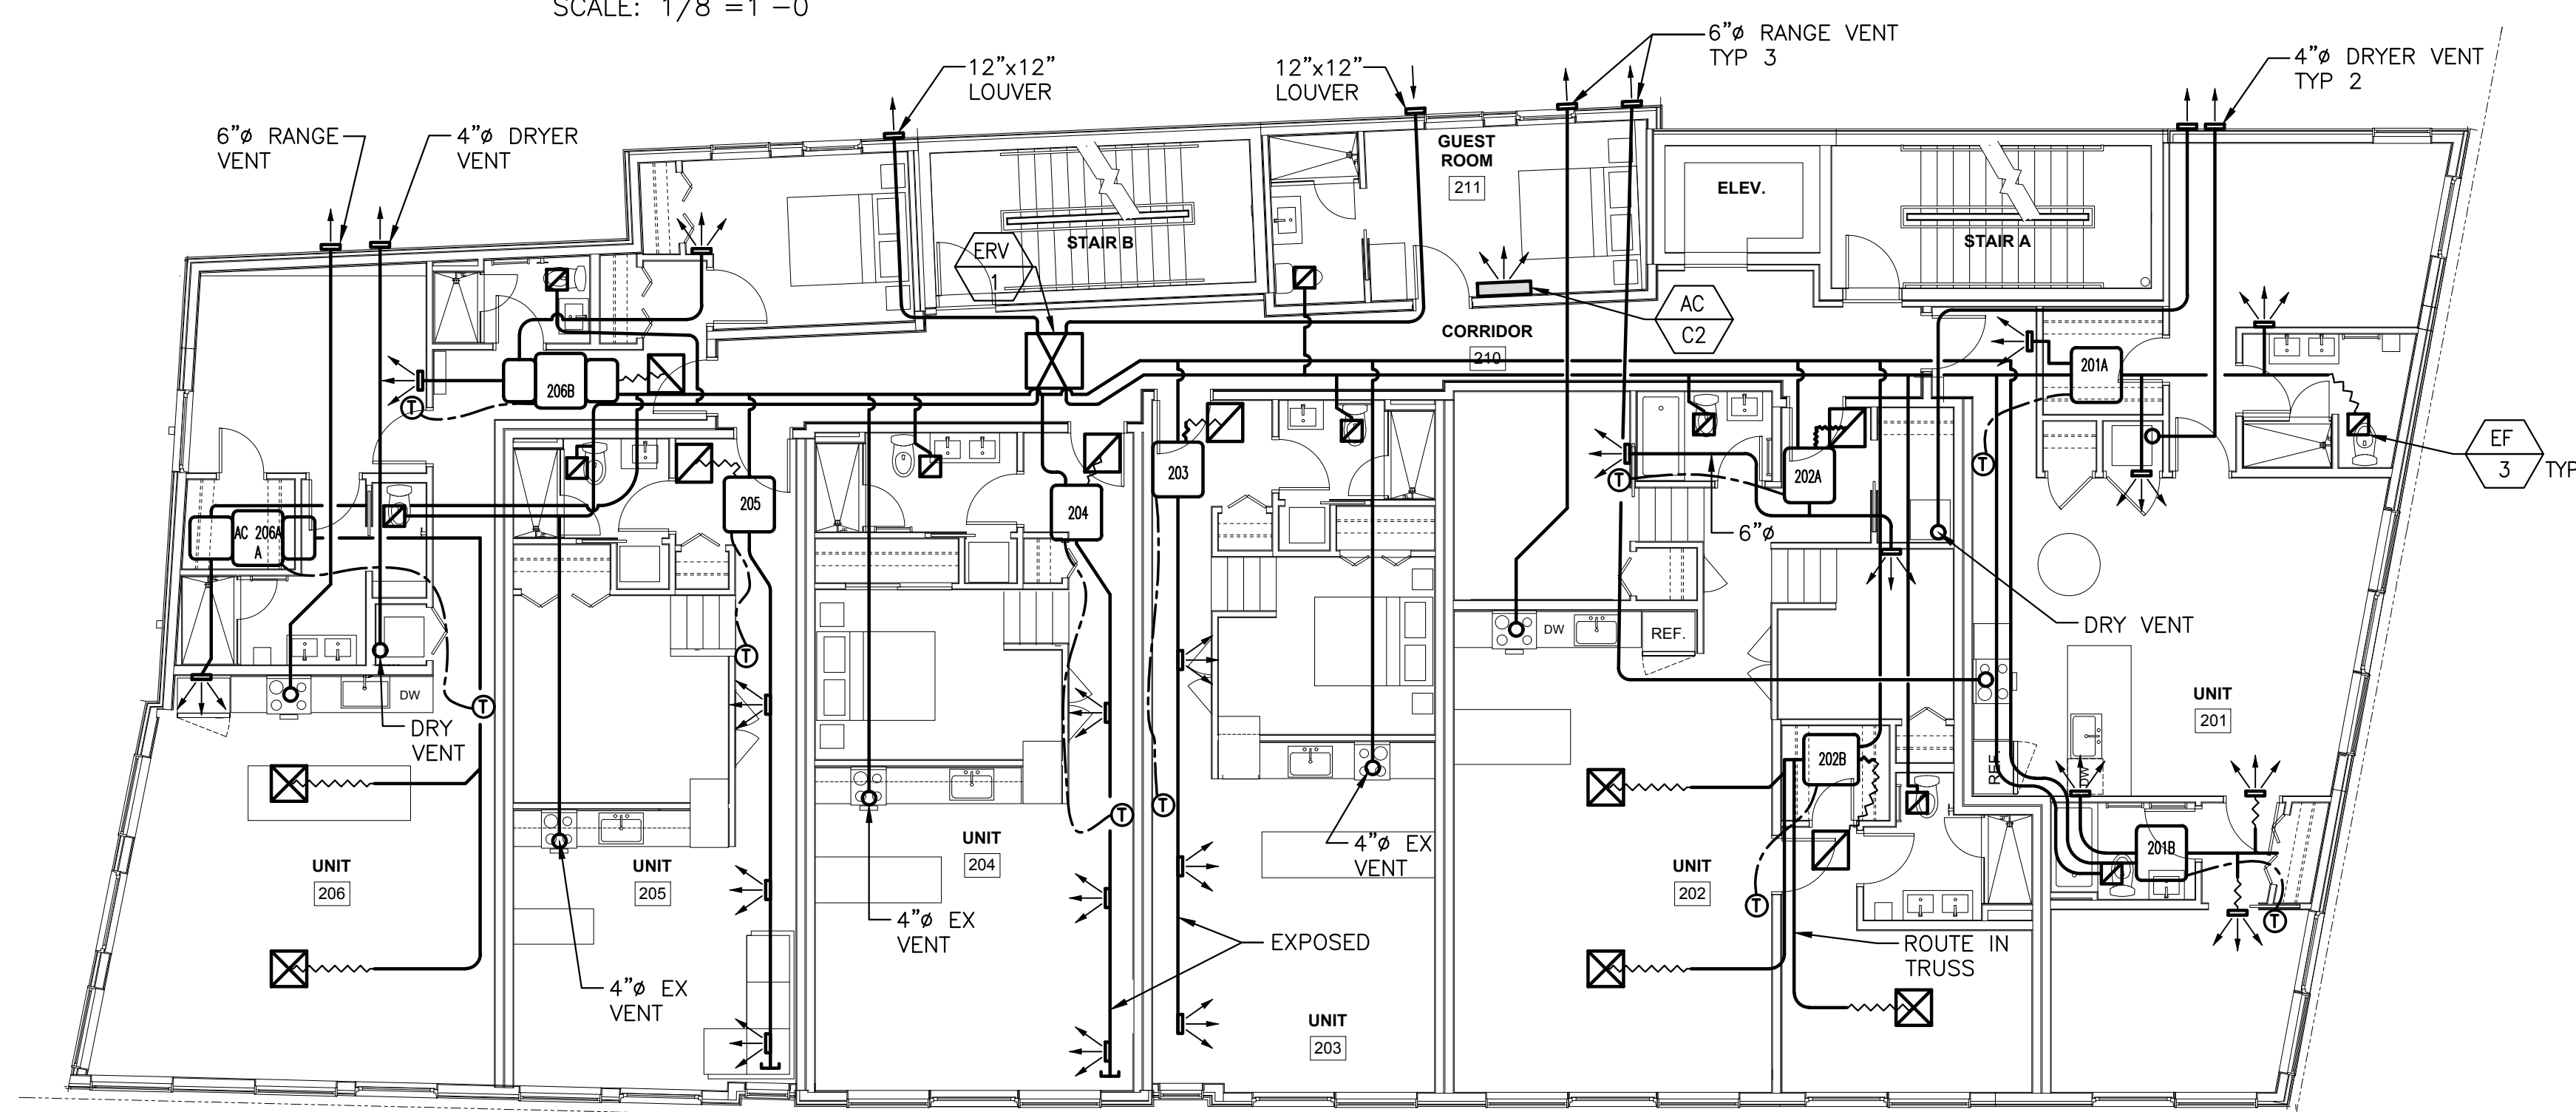

2ND FLOOR - DUCTWORK

SCALE: 1/8"=1'-0"

Design • Build • Install • Service



HVAC SERVICES, INC.

73 BRADLEY DRIVE
WESTBROOK, MAINE 04092
(207) 854-HVAC (4822)

REVISIONS		LUMINATO NEWBURY STREET PORTLAND, MAINE	
NO.	NOTES	PROJECT:	
		2ND AND 3RD FLOOR DUCTWORK PLANS	
		SHEET TITLE:	DATE: 11-22-2016
		SCALE: 1/8"=1'-0"	DRAWN BY: A2Z CADD DRAFTING SERVICES, INC.
		CHECKED BY:	SHEET No.
		XX	M-2