


5TH FLOOR - DUCTWORK
SCALE: 1/8"=1'-0"

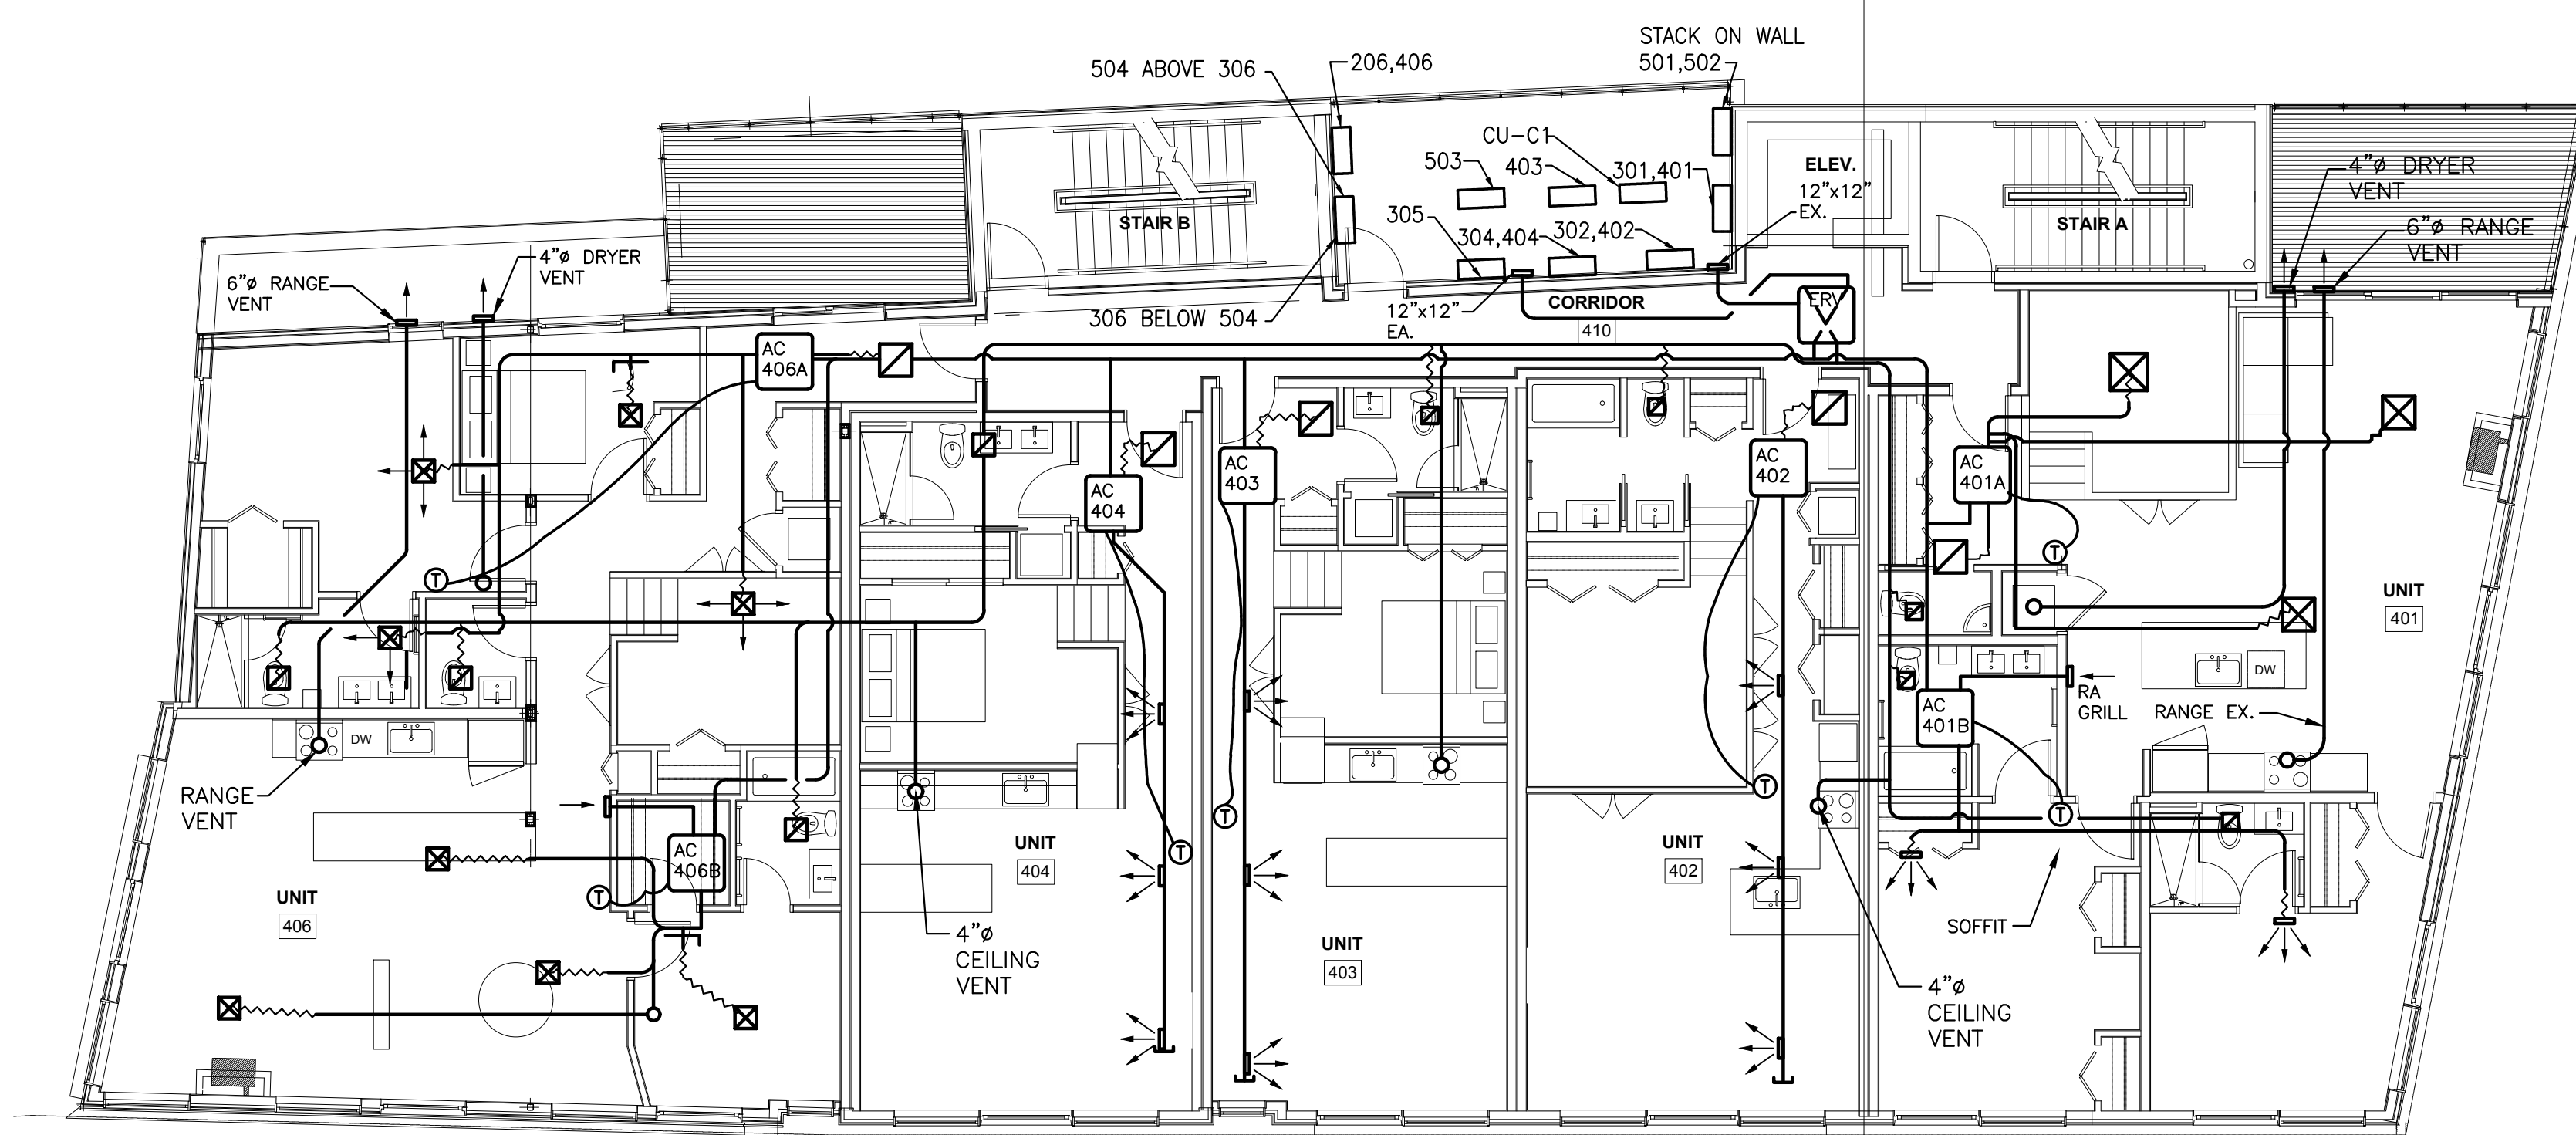

4TH FLOOR - DUCTWORK
SCALE: 1/8"=1'-0"

Design • Build • Install • Service

HVAC SERVICES, INC.

73 BRADLEY DRIVE
WESTBROOK, MAINE 04092
(207) 854-HVAC (4822)

| REVISIONS | | PROJECT: LUMINATO NEWBURY STREET PORTLAND, MAINE |
|-------------------|-------|---|
| NO. | NOTES | |
| | | 4TH AND 5TH FLOOR DUCTWORK PLANS |
| SHEET TITLE: | | DATE: 11-22-2016 |
| SCALE: 1/8"=1'-0" | | DRAWN BY: A22 CADD DRAFTING SERVICES, INC. SHEET No. |
| CHECKED BY: | | M-3 |
| XX | | |