


**LEGEND:**

RISE/DESC SW	NFPA SYMBOL	DESCRIPTION	CATALOG #
[FACP]	[FACP]	Fire Alarm Control Panel	EST-030300
[FAA]	[FAA]	Remote Annunciator	RLCD-CR
[BPS]	[FACU]	Backup Power Supply	BPS-10A
[F]	[P]	Addressable Manual Station	SIGA-278
[E]	[E]	Conventional Weatherproof Manual station	MPSC-SMVC-04
[1]	[1]	Addressable Smoke Detector w/ Base (ER indicates elevator shaft area)	SIGA-SD
[2]	[2]	Addressable Dual Smoke Detector	SIGA-SD
[3]	[3]	Addressable Heat Detector w/ Base	SIGA-SD
[4]	[4]	Carbon Monoxide Detector	SD-TRK
[5]	[5]	Remove Test Switch	COI224T
[6]	[6]	Multi-Voltage Relay	PR1
[7]	[7]	Addressable Input Module (7 terminals single or double input)	SIGA-CTX
[8]	[8]	Addressable Control Module	SIGA-CR
[9]	[9]	Synchronization Module	SIGA-CCIS
[10]	[10]	Smoke Unit (Adjustable Candel)	GIF-SW
[11]	[11]	Heatstroke Unit (Adjustable Candel)	GIF-HDWM
[12]	[12]	Low Frequency Heat Unit	GDAL-PWF-4
[13]	[13]	Weather Proof Horn/Stroke Unit (Adjustable Candel)	Z57-SA-T
[14]	[14]	Weather Proof Horn/Stroke Unit (Adjustable Candel)	Z57-SA-T
[15]	[15]	Weather Proof Horn/Stroke Unit (Adjustable Candel)	Z57-SA-T
[70]	[70]	Weather Proof Horn/Stroke Unit (Adjustable Candel)	Z57-SA-T

~NFPA 710(2009)  
Tables 4.5.6.7.1, 6.2.2 & 6.2.3

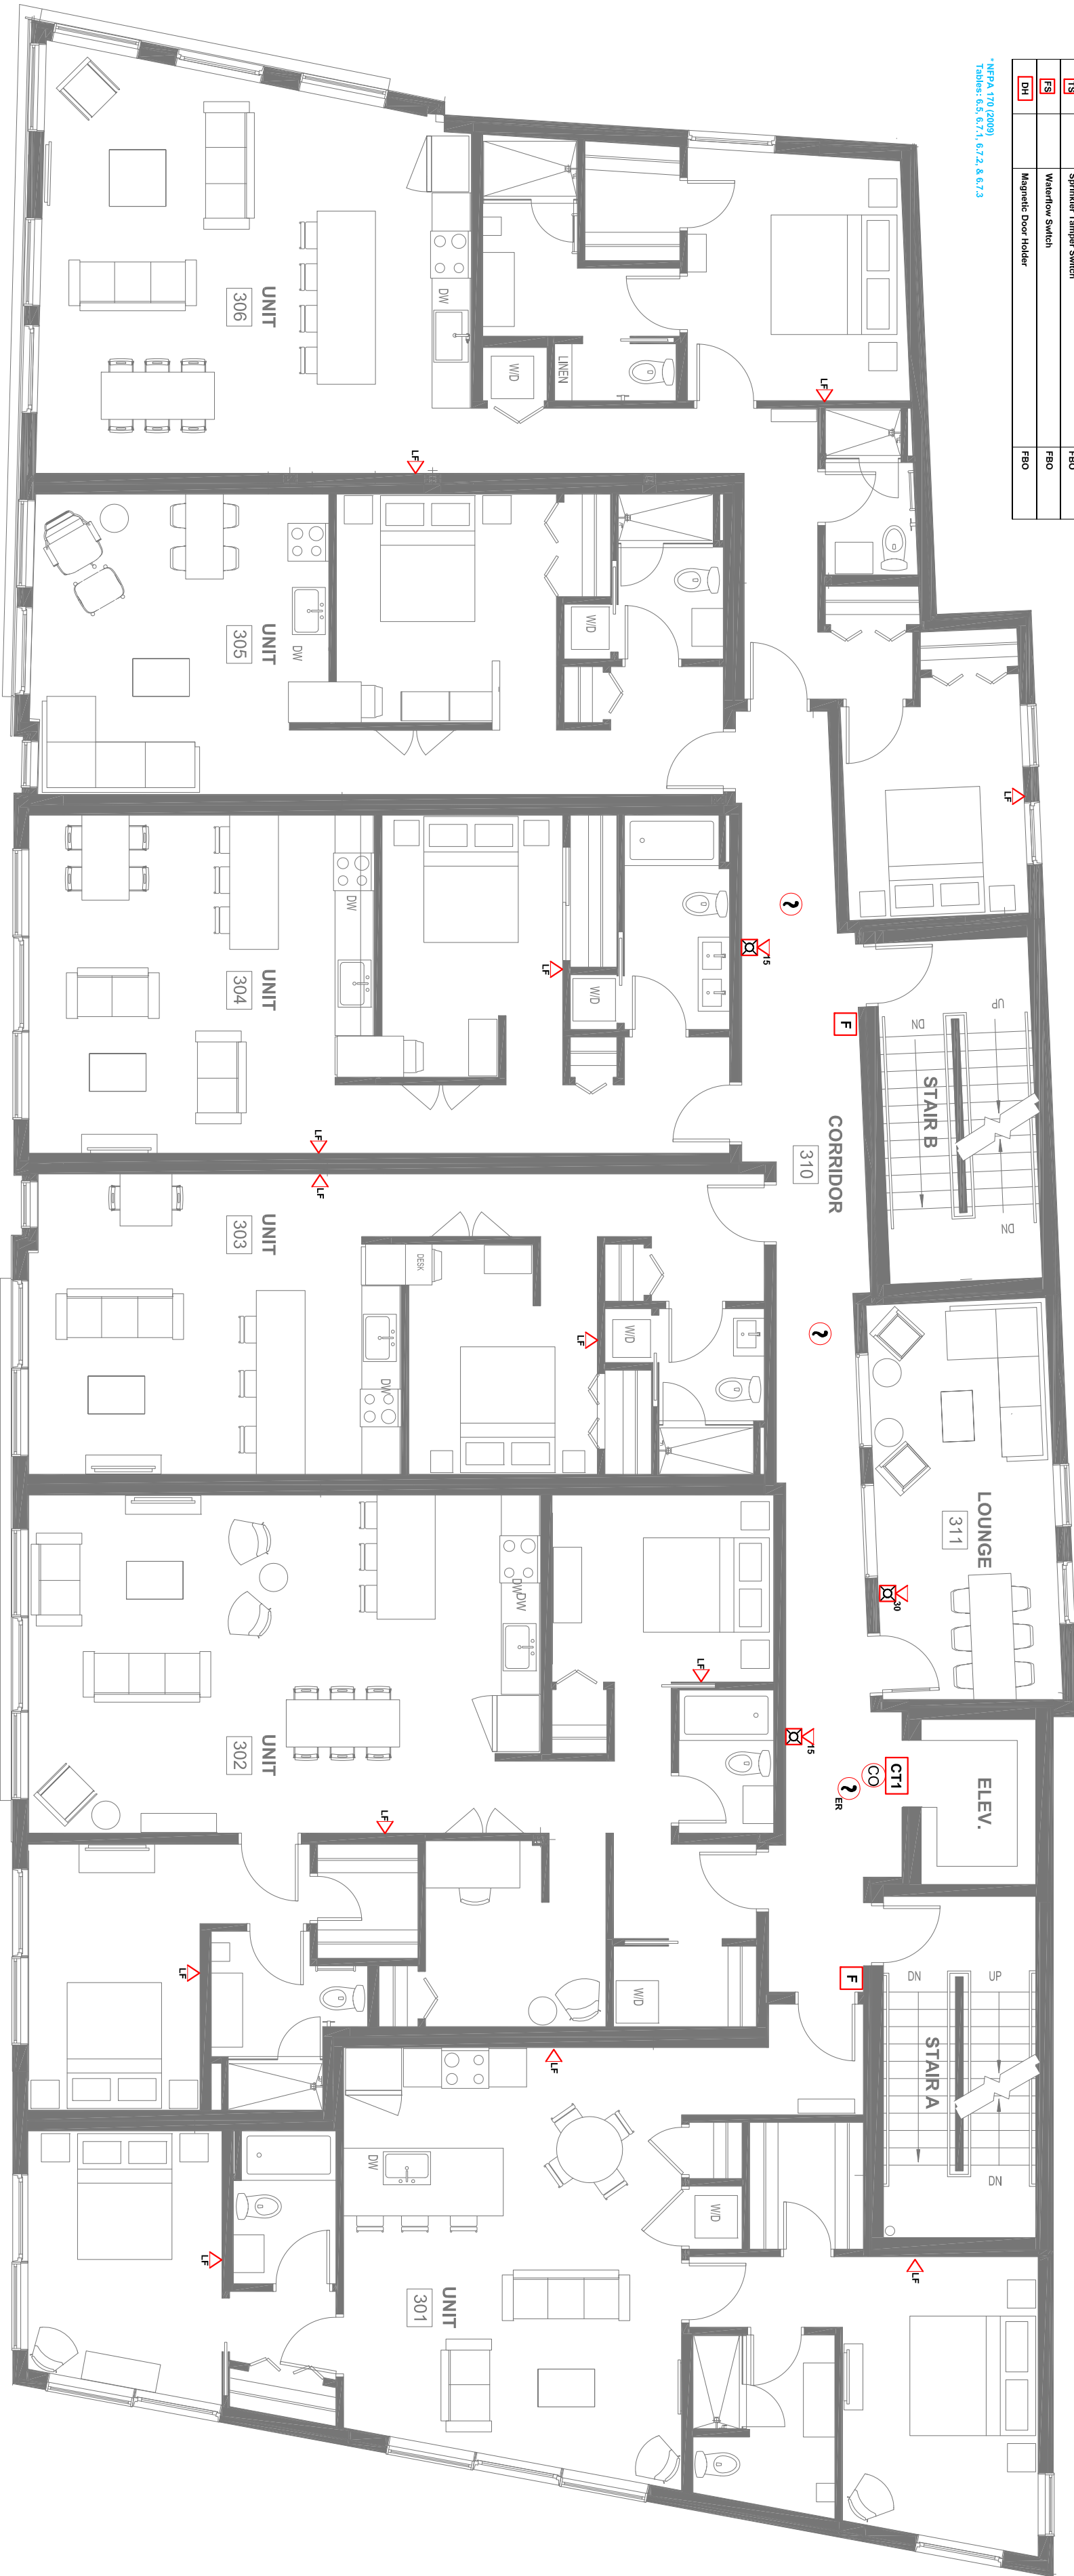

PO No. 91348 Luminato Portland, ME Floor Plan 3rd Floor DWG No. FA-005			
SCALE: 1/8" = 1'0"			
0	Original Issue	1/17	ENH TRD
REV.	DESCRIPTION	DATE	DRWN: RVW'D:

JOB NAME: **Luminato Portland, Maine Tier II Floor Plan 3rd Floor**

Contractor: **Deblois Electric, Inc.**

**R.B. Allen Co., Inc.**  
 P.O. BOX 770  
 131 LAFAYETTE RD  
 NO. HAMPTON, NH 03862  
 1-800-256-7264

**EST**  
 EDWARDS SYSTEM TECHNOLOGY

DWG NAME: FA-005

**Luminato Portland, ME Floor Plan 3rd Floor**

DWG No: FA-005