


FIRST FLOOR - DUCTWORK
SCALE: 1/8"=1'-0"

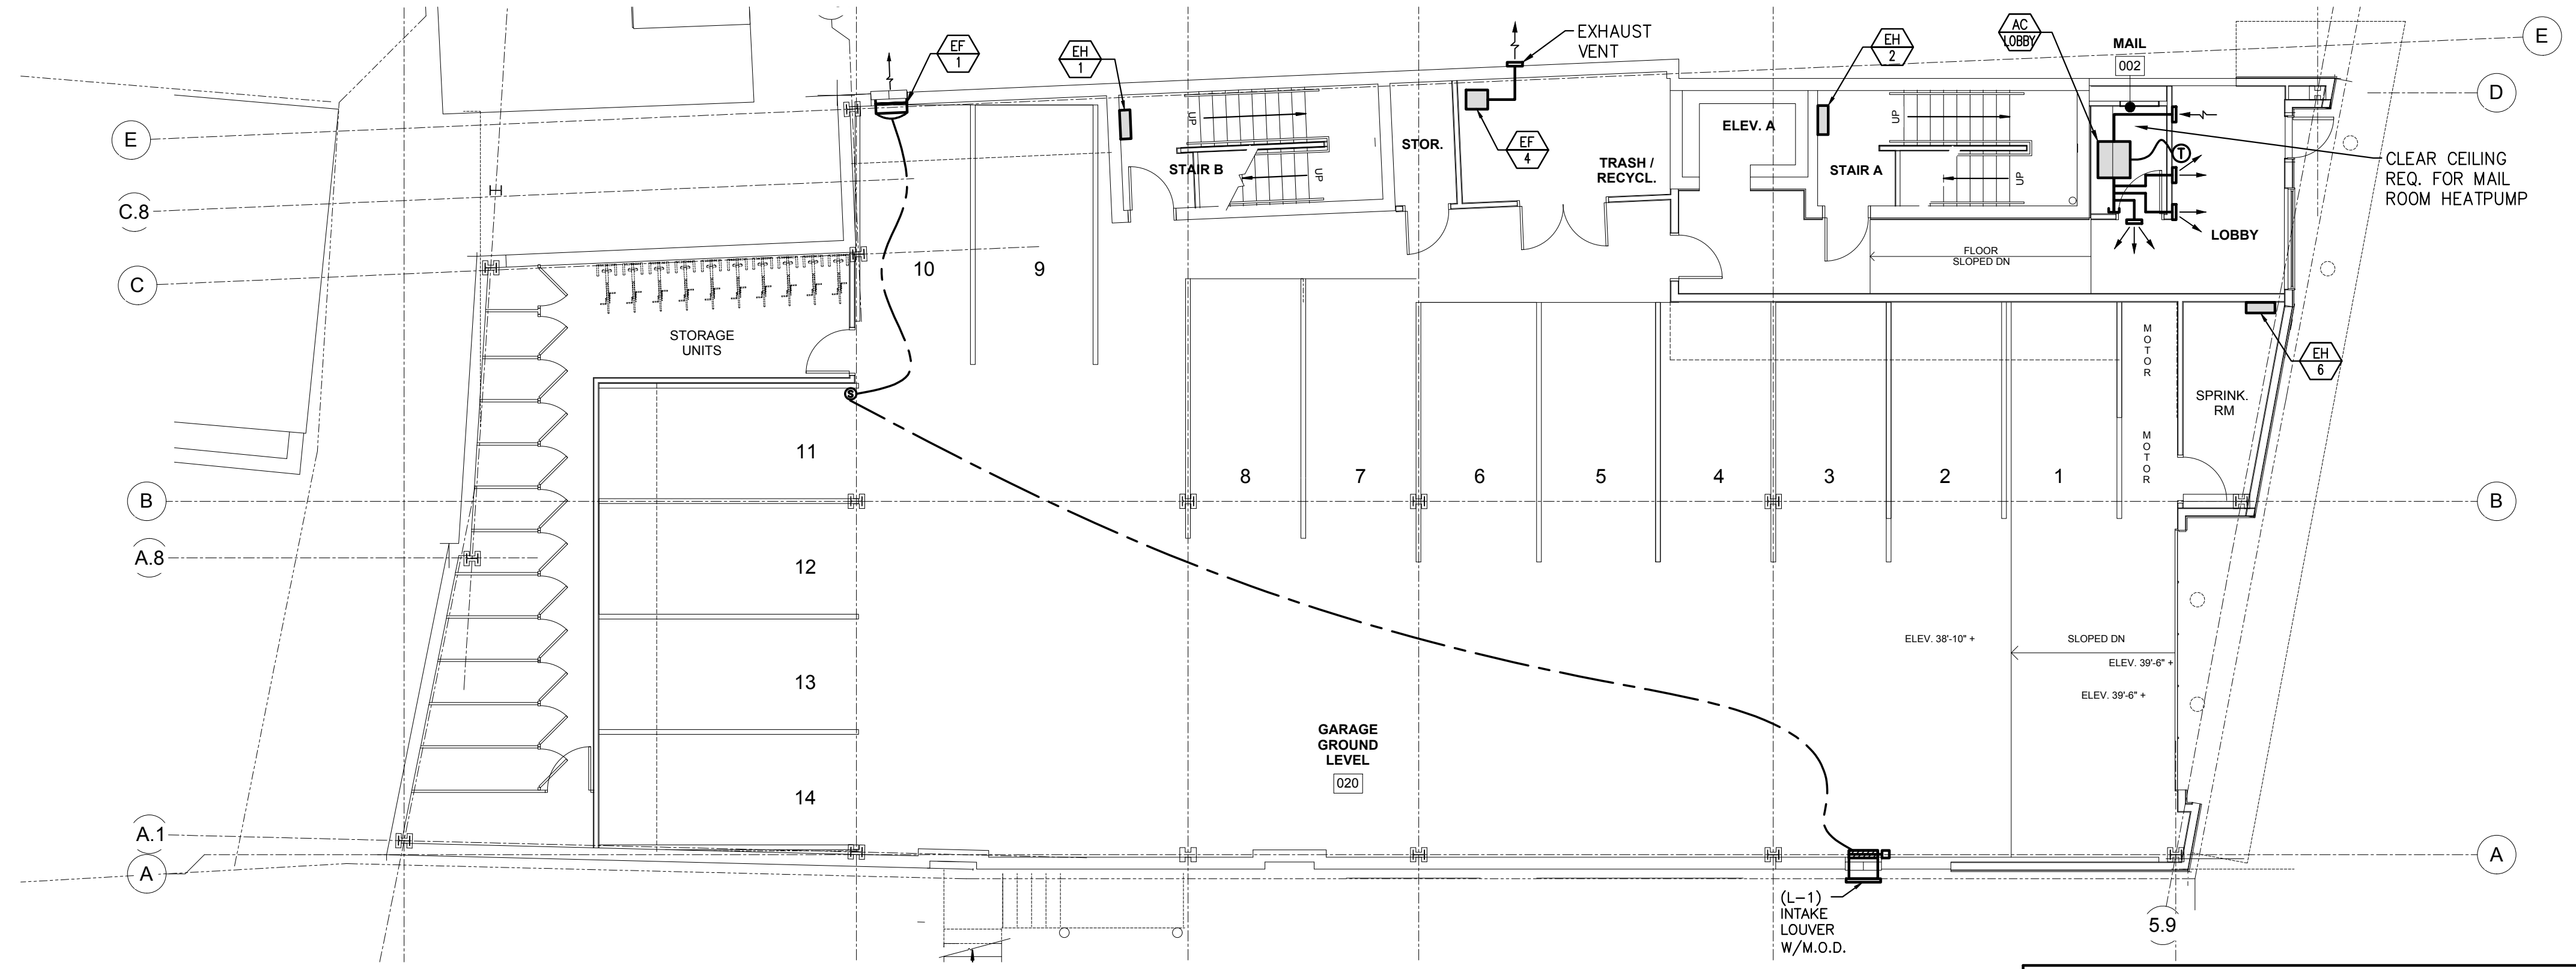

BASEMENT FLOOR - DUCTWORK
SCALE: 1/8"=1'-0"

Design • Build • Install • Service

HVAC SERVICES, INC.

73 BRADLEY DRIVE
WESTBROOK, MAINE 04092
(207) 854-HVAC (4822)

REVISIONS		PROJECT: LUMINATO NEWBURY STREET PORTLAND, MAINE
NO.	NOTES	
		1ST & BASEMENT FLOOR DUCTWORK PLANS
SHEET TITLE:		DATE: 7-20-2016
SCALE: 1/8"=1'-0"		DRAWN BY: A2Z CADD DRAFTING SERVICES, INC. SHEET No.
CHECKED BY:		M-1
XX		