


3RD FLOOR – DUCTWORK
SCALE: 1/8"=1'-0"

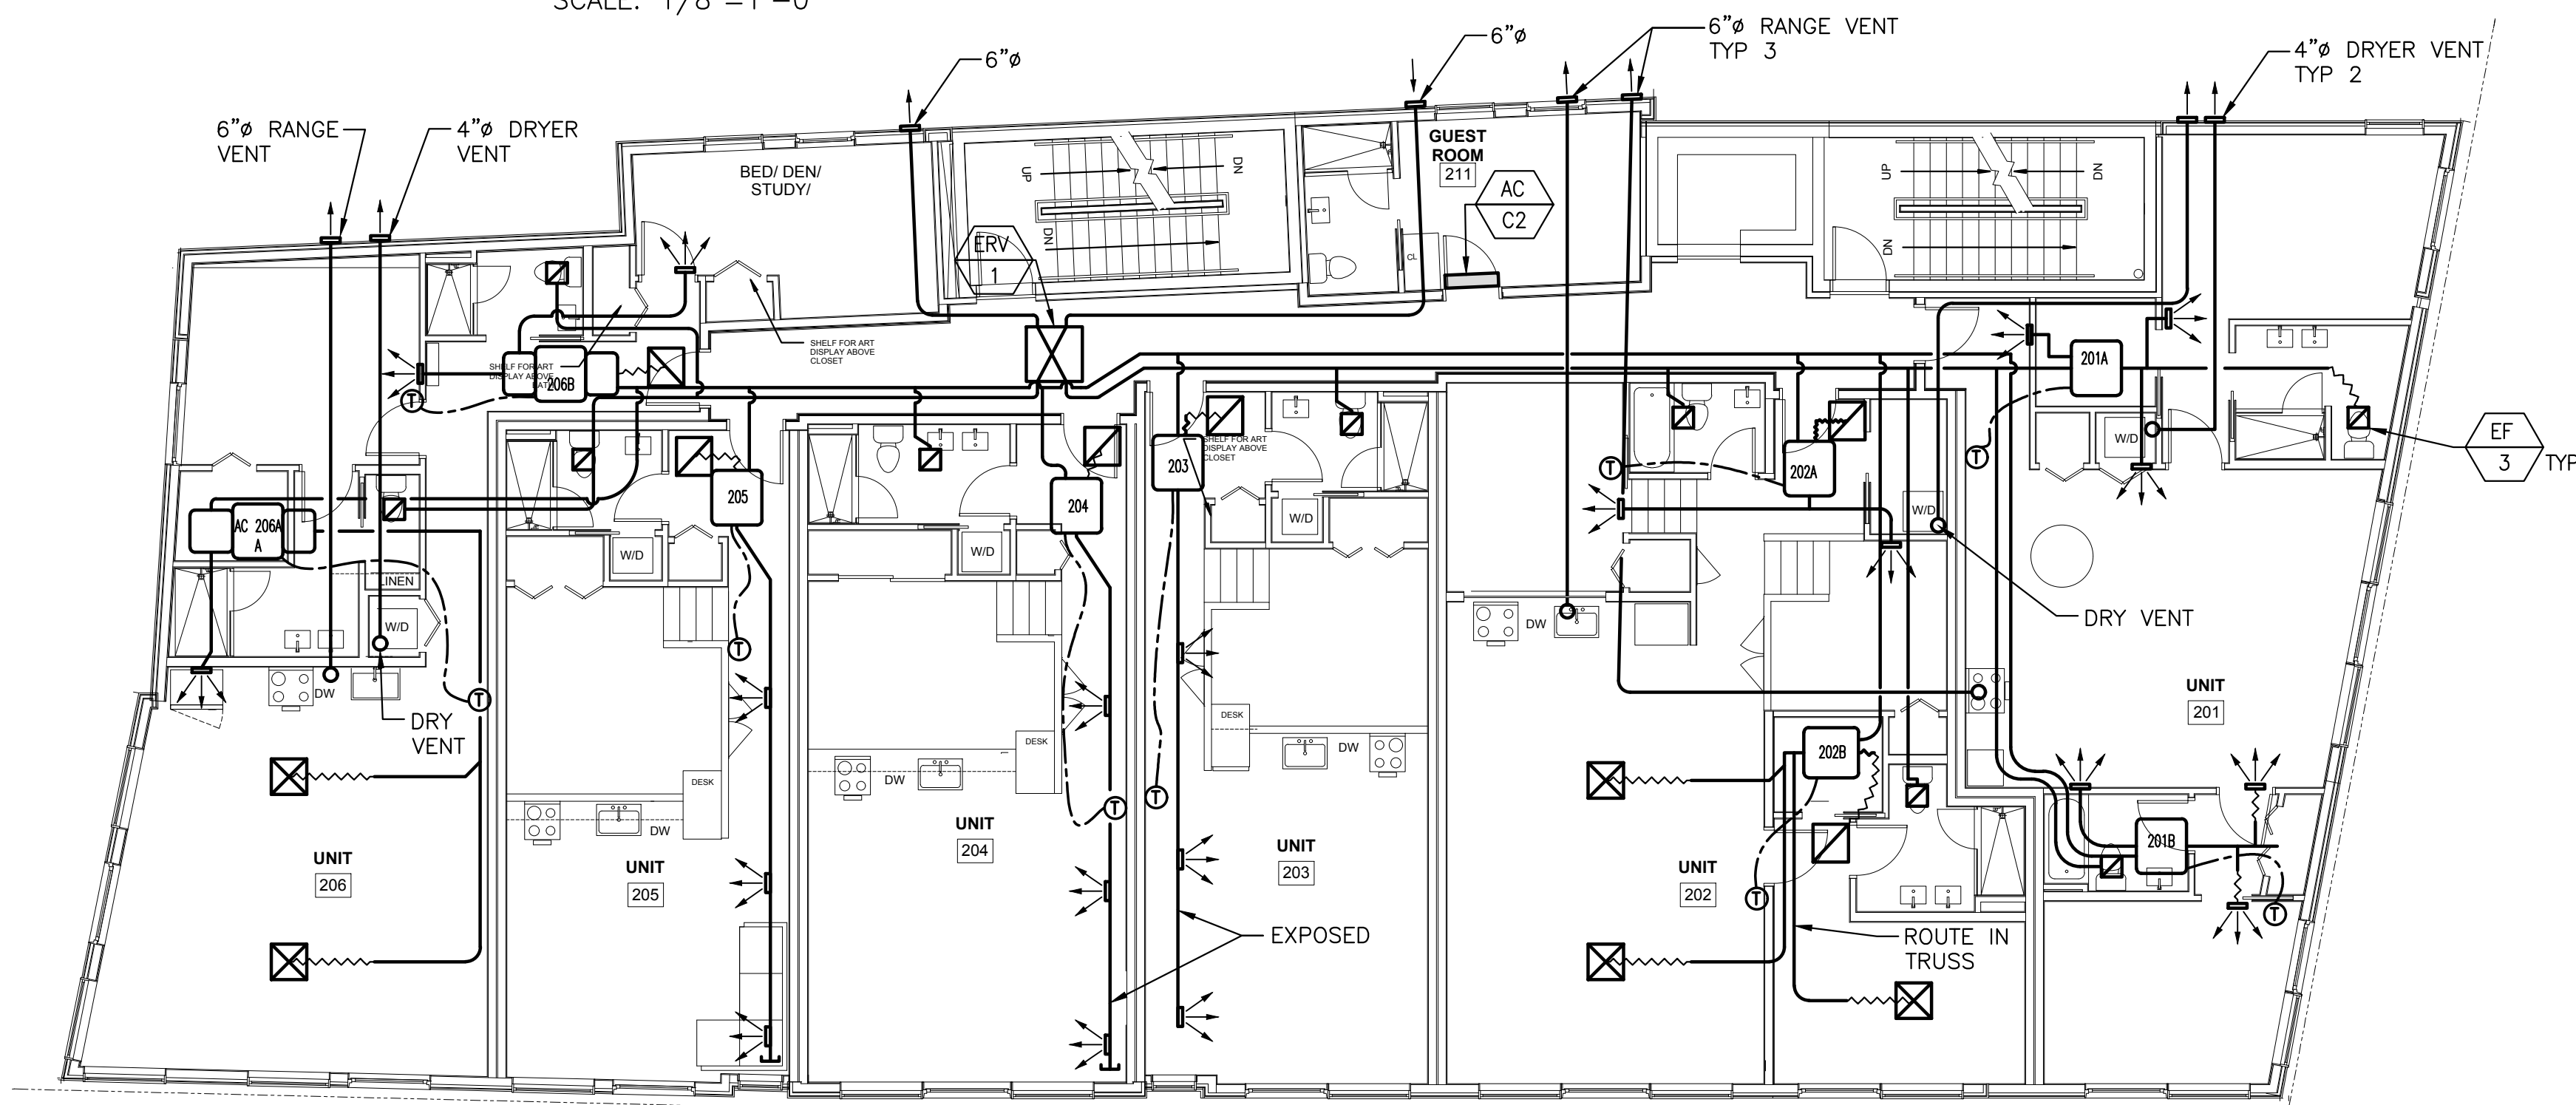

2ND FLOOR – DUCTWORK
SCALE: 1/8"=1'-0"

Design • Build • Install • Service

HVAC SERVICES, INC.

73 BRADLEY DRIVE
WESTBROOK, MAINE 04092
(207) 854-HVAC (4822)

| | | | |
|-----------|-------|---|--|
| REVISIONS | | LUMINATO NEWBURY STREET PORTLAND, MAINE | |
| NO. | NOTES | PROJECT: | |
| | | 2ND AND 3RD FLOOR DUCTWORK PLANS | |
| | | SHEET TITLE: | DATE: 7-20-2016 |
| | | SCALE: 1/8"=1'-0" | DRAWN BY: A2Z CADD DRAFTING SERVICES, INC. |
| | | CHECKED BY: | SHEET No. |
| | | XX | M-2 |