



5TH FLOOR – DUCTWORK
SCALE: 1/8"=1'-0"



4TH FLOOR – DUCTWORK
SCALE: 1/8"=1'-0"

Design • Build • Install • Service

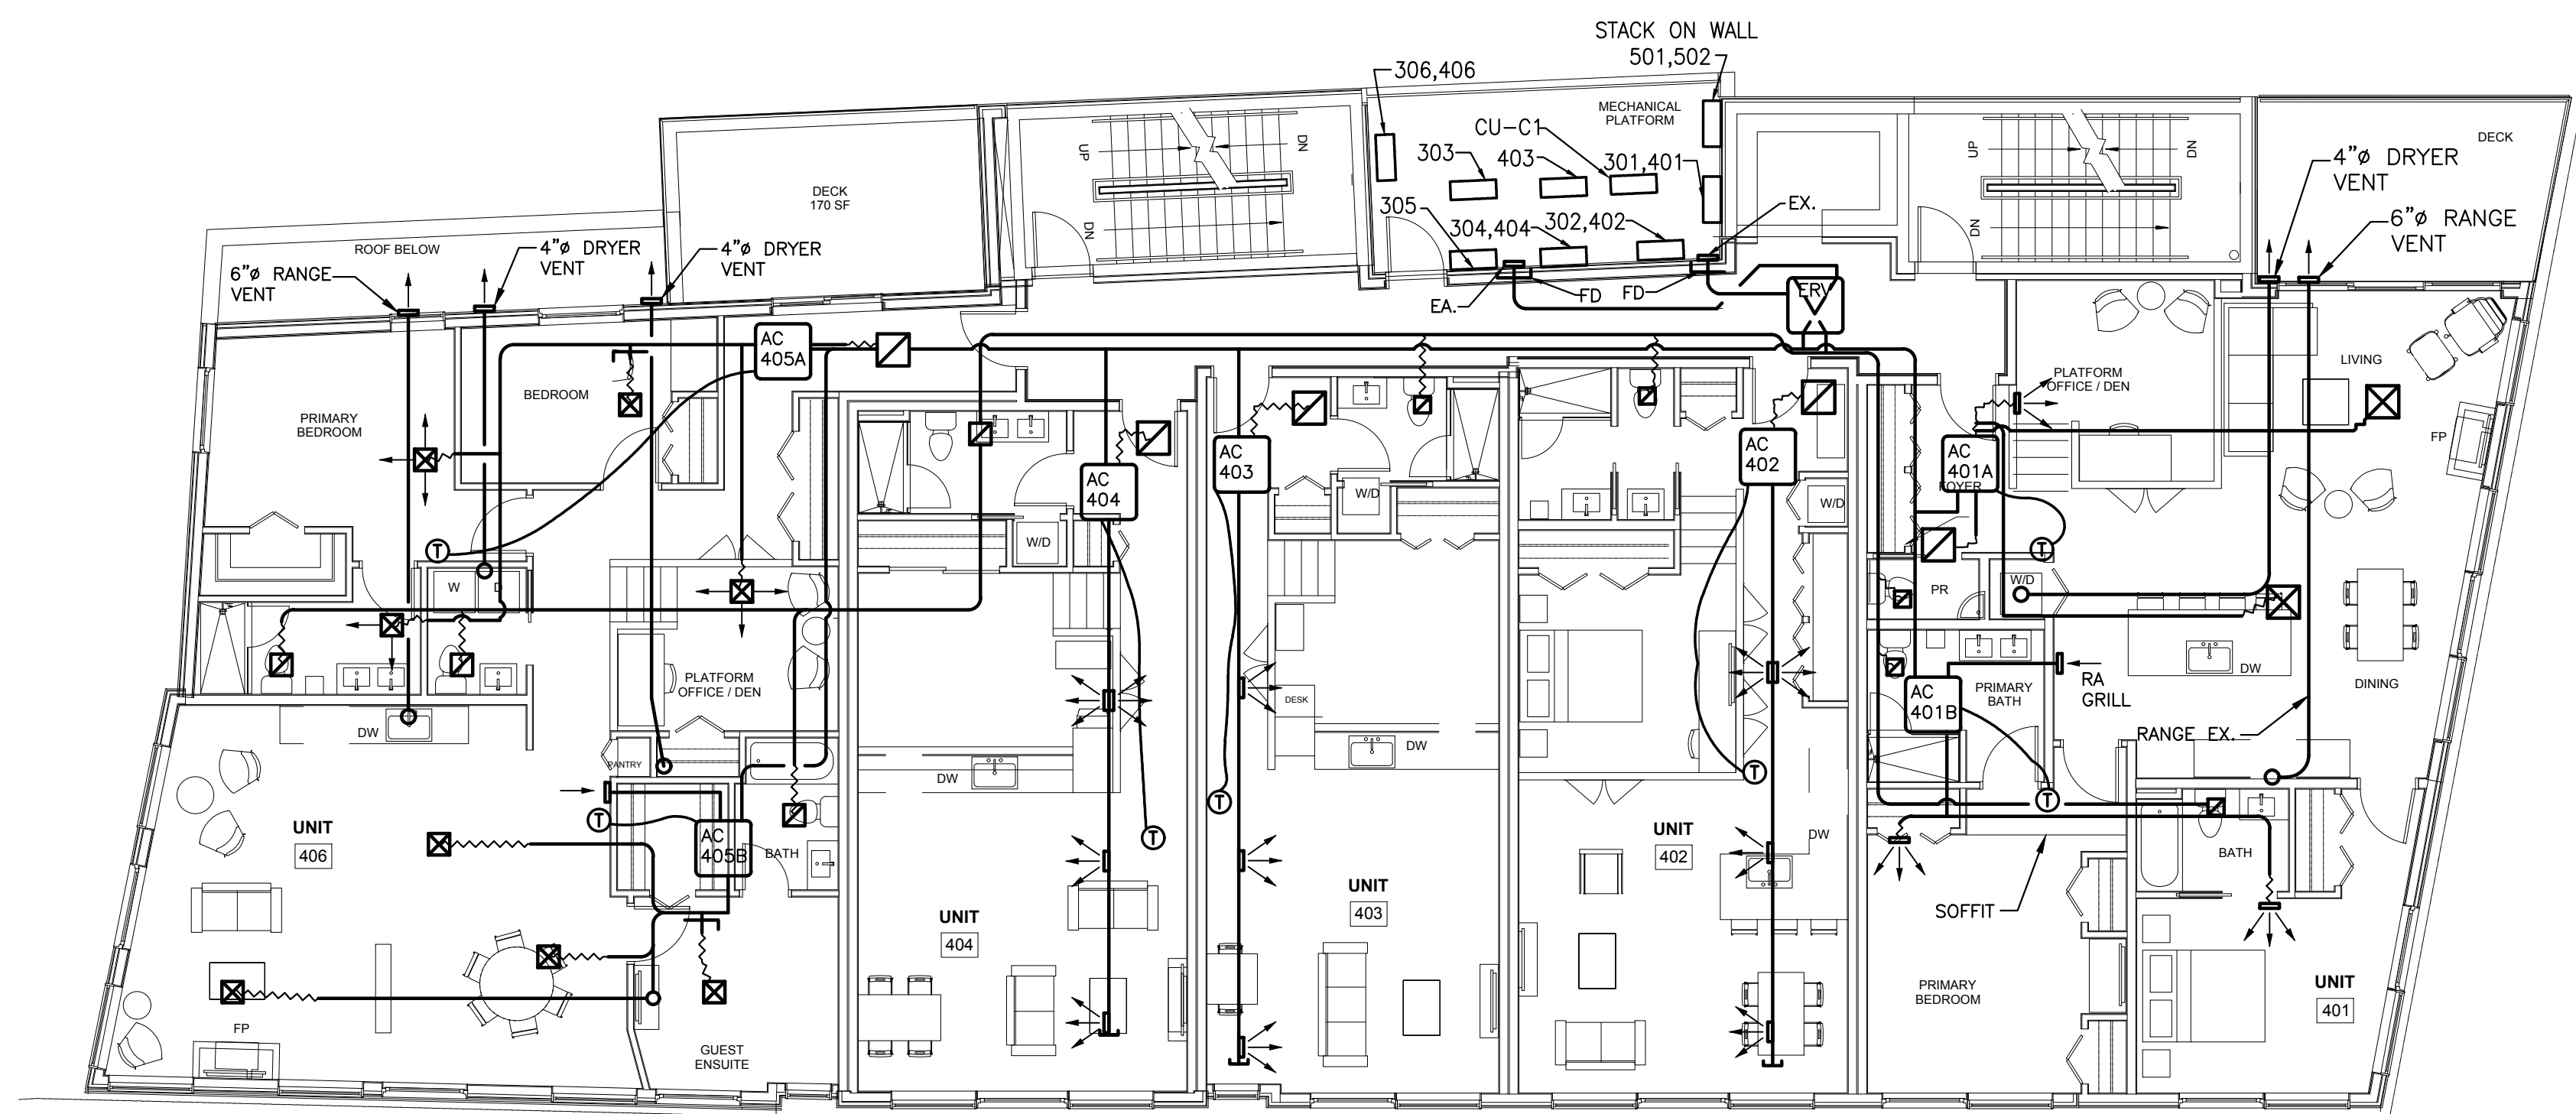

HVAC SERVICES, INC.

73 BRADLEY DRIVE
WESTBROOK, MAINE 04092
(207) 854-HVAC (4822)

REVISIONS		LUMINATO NEWBURY STREET PORTLAND, MAINE	
NO.	NOTES	PROJECT:	
		4TH AND 5TH FLOOR DUCTWORK PLANS	
		SHEET TITLE:	
		SCALE: 1/8"=1'-0"	DATE: 7-20-2016
		DRAWN BY: A22 CADD DRAFTING SERVICES, INC. SHEET No.	
		CHECKED BY:	
		XX	
		M-3	