


ROOF STAIR / ELEV. TOWER


SCALE: 1/8"=1'-0"

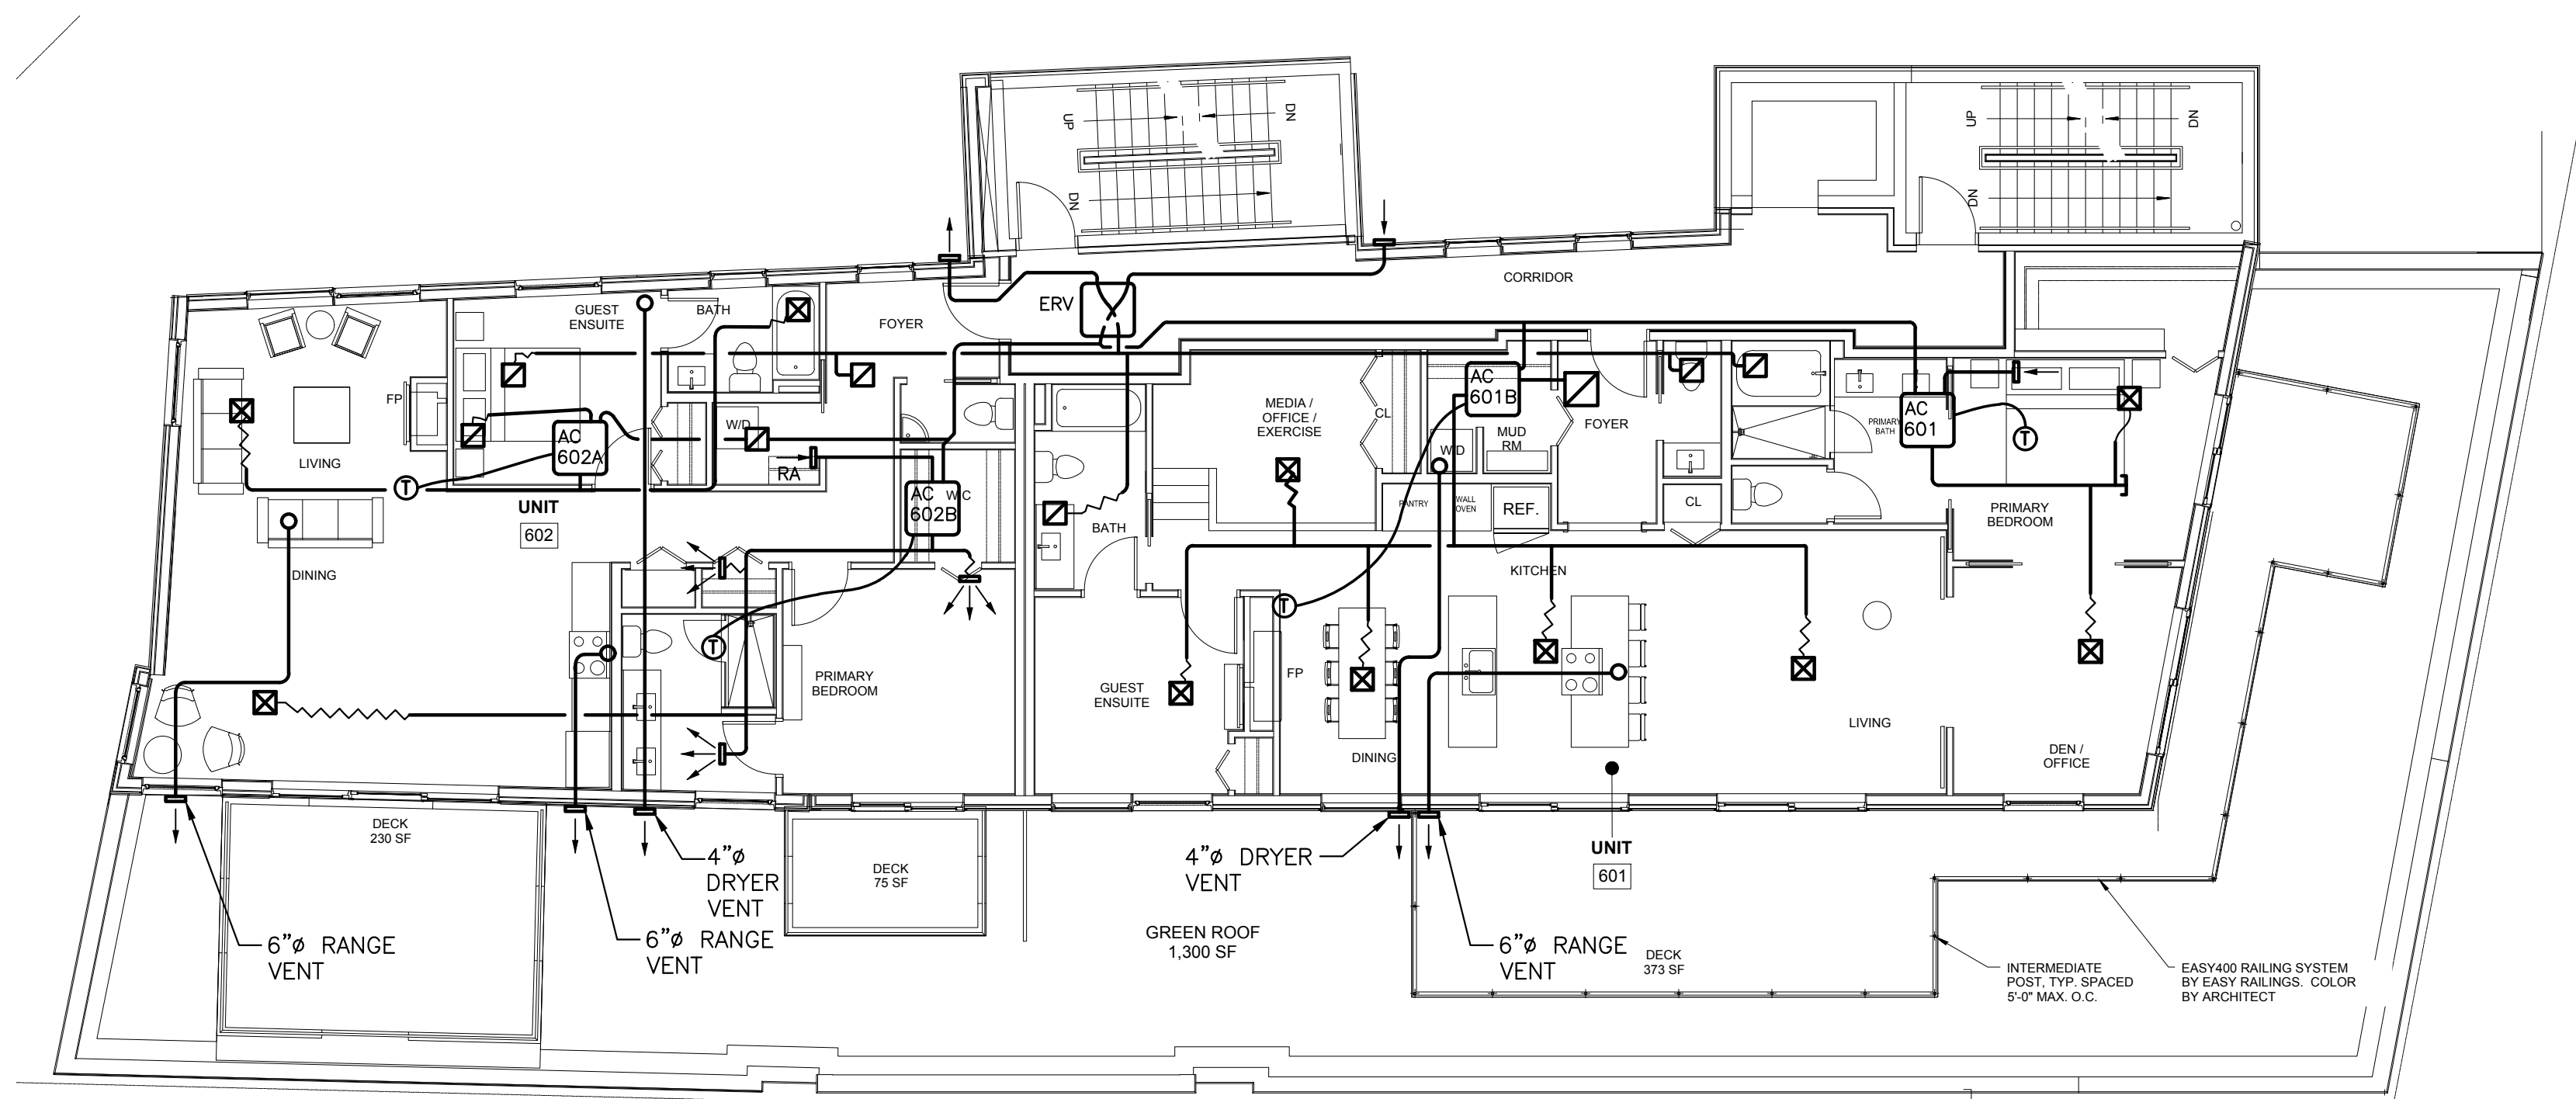

6TH FLOOR - DUCTWORK

SCALE: 1/8"=1'-0"

Design • Build • Install • Service



HVAC SERVICES, INC.

73 BRADLEY DRIVE
WESTBROOK, MAINE 04092
(207) 854-HVAC (4822)

REVISIONS		LUMINATO NEWBURY STREET PORTLAND, MAINE	
NO.	NOTES	PROJECT:	
		6TH FLOOR AND ROOF DUCTWORK PLANS	
		SHEET TITLE:	DATE: 7-20-2016
		SCALE: 1/8"=1'-0"	SHEET No.
		DRAWN BY: A2Z CADD DRAFTING SERVICES, INC.	
		CHECKED BY:	
		XX	M-4