



SECOND FLOOR PLUMBING PLAN
SCALE - 1/8" = 1'-0"

NOTES -
1. BALANCE ALL HOT WATER RECIRC. (RHU) BRANCHES TO 0.5 GPM
2. INSTALL SIZE 'A' WATER HAMMER ARRESTORS UNDER ALL P-4 FIXTURES
3. FIELD ROUTE HEAT PUMP CONDENSATE TO P-2 TAILPIECE. SEE MECHANICAL DRAWINGS FOR HEAT PUMP QUANTITIES AND LOCATIONS

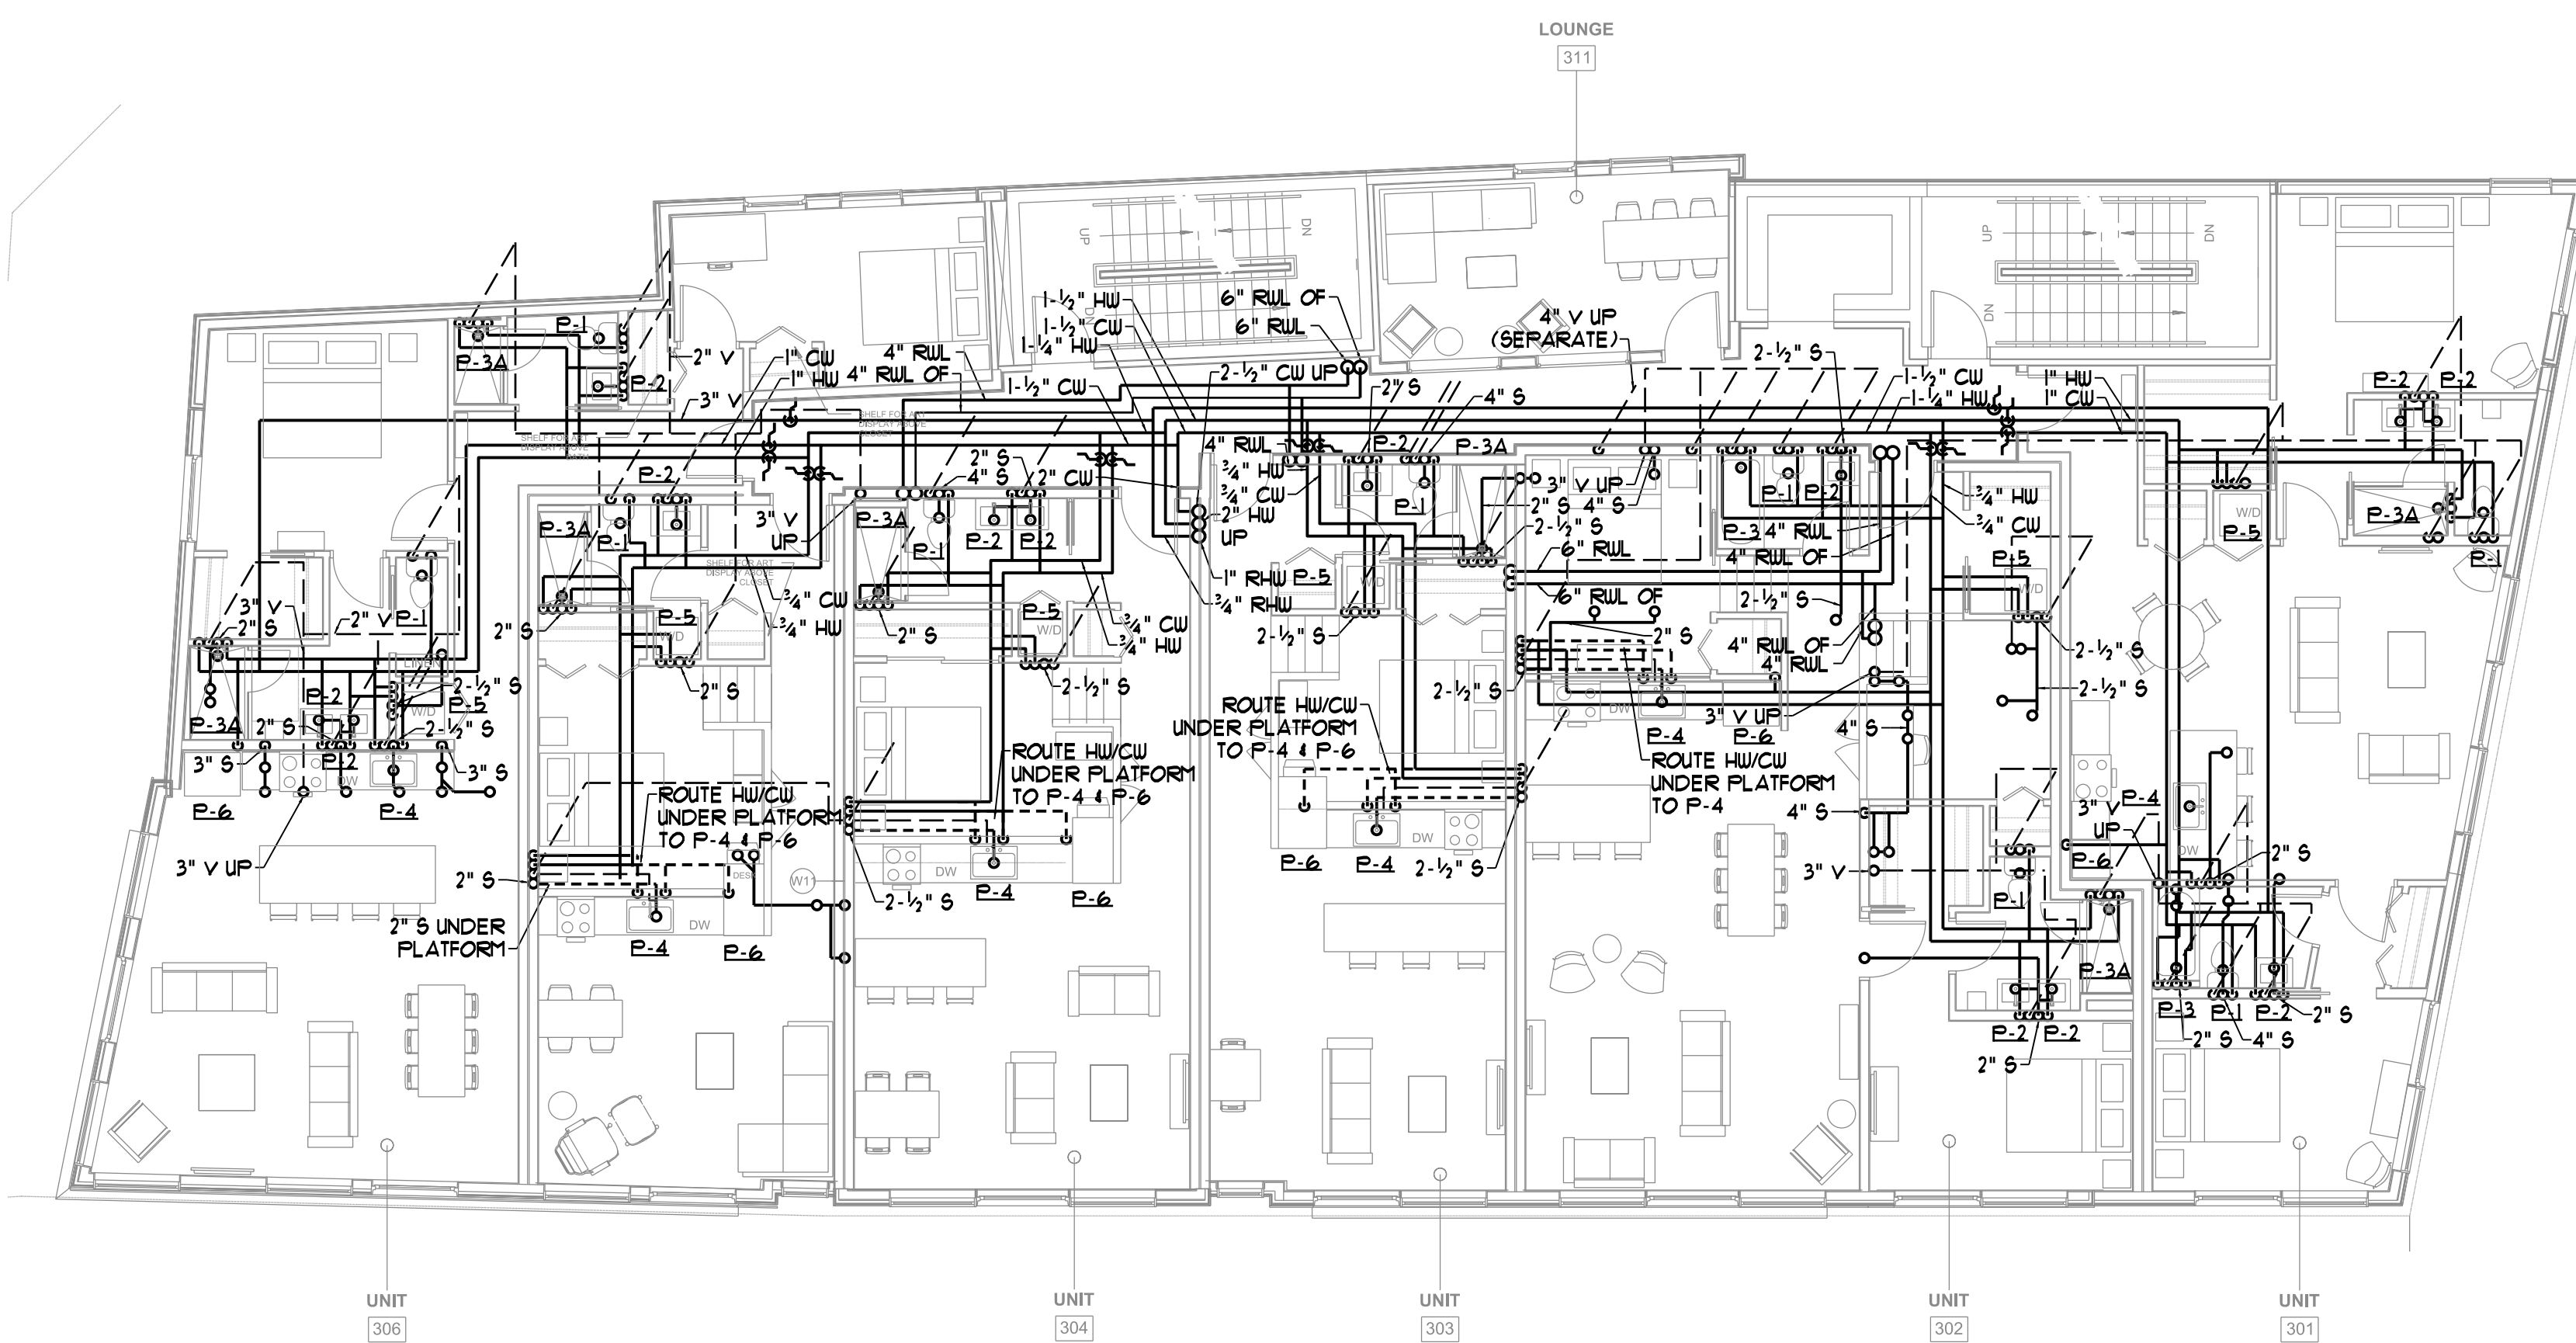

THIRD FLOOR PLUMBING PLAN
SCALE - 1/8" = 1'-0"

NOTES -
1. BALANCE ALL HOT WATER RECIRC. (RHU) BRANCHES TO 0.5 GPM
2. INSTALL SIZE 'A' WATER HAMMER ARRESTORS UNDER ALL P-4 FIXTURES
3. FIELD ROUTE HEAT PUMP CONDENSATE TO P-2 TAILPIECE. SEE MECHANICAL DRAWINGS FOR HEAT PUMP QUANTITIES AND LOCATIONS

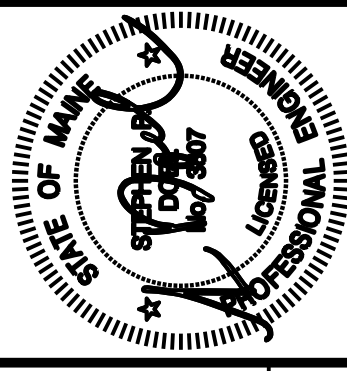

Prepared For:
NewHeight Group
118 Congress Street, Unit 401
Portland, Maine



Consultant:
BENNETT ENGINEERING
MECHANICAL - ELECTRICAL
(207) 865-9475

Architect:
ARCHITECTYPE architects
48 Union Wharf Portland, Maine 04101
(207) 772-6022 ARCHITYPE@ARCHITYPEPA.COM

Project:
LUMINATO
167 Newbury Street Portland, Maine

Revisions:

Date: **JUNE 17, 2016**
Scale: **As indicated**
SECOND & THIRD FLOOR PLUMBING PLANS

M1.02