



2 | THIRD FLOOR - POWER  
1/8" = 1'-0"

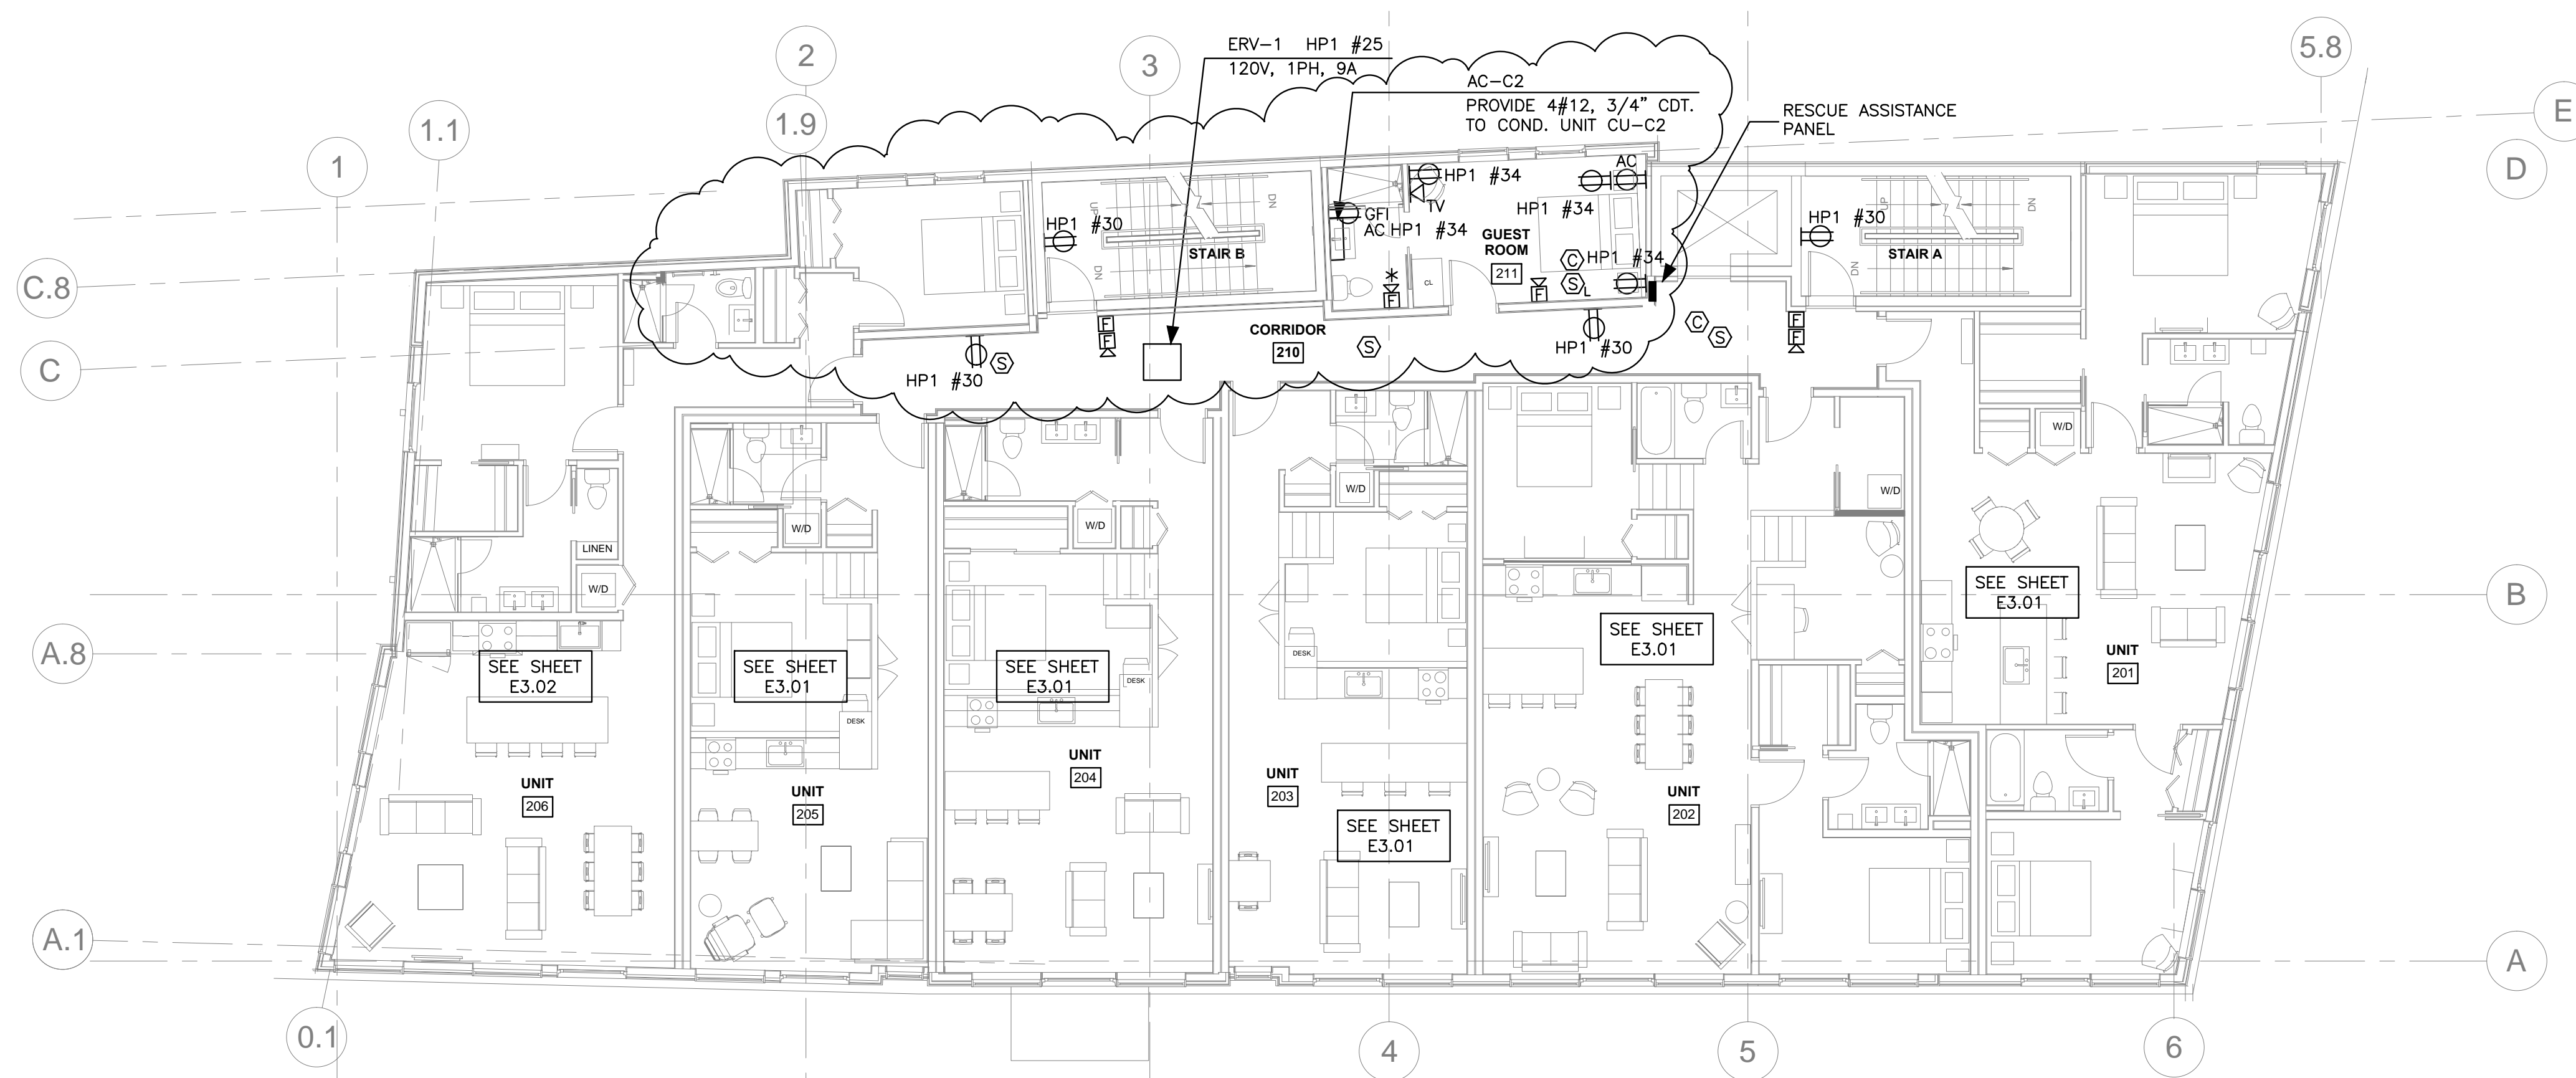

1 | SECOND FLOOR - POWER  
1/8" = 1'-0"

CIRCUIT THE LOCAL SMOKE AND CO DETECTORS IN GUEST ROOM 211 TO PANEL EP1 #3.

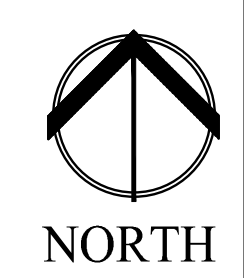

E1.02

Date: JUNE 17 2016  
Scale: AS NOTED  
SECOND AND THIRD FLOOR POWER PLANS

Revisions:  
06/17/16 100% REVIEW SET  
07/22/16 REVISED PLANS  
07/28/16 ADDENDUM A

Project: LUMINATO  
Newbury Street Portland, Maine

Architect: ARCHITYPE architects  
48 Union Wharf Portland, Maine 04101  
(207) 772-6022 Fax (207) 772-4056

Consultant: Bartlett Design  
ELECTRICAL ENGINEERING  
144 HUNTSMEAD AVENUE PORTLAND, ME 04103  
TEL: (207) 448-3447 FAX: (207) 448-3000

Prepared For: NewHeight Group

