


FIRST FLOOR PARTIAL PLUMBING PLAN

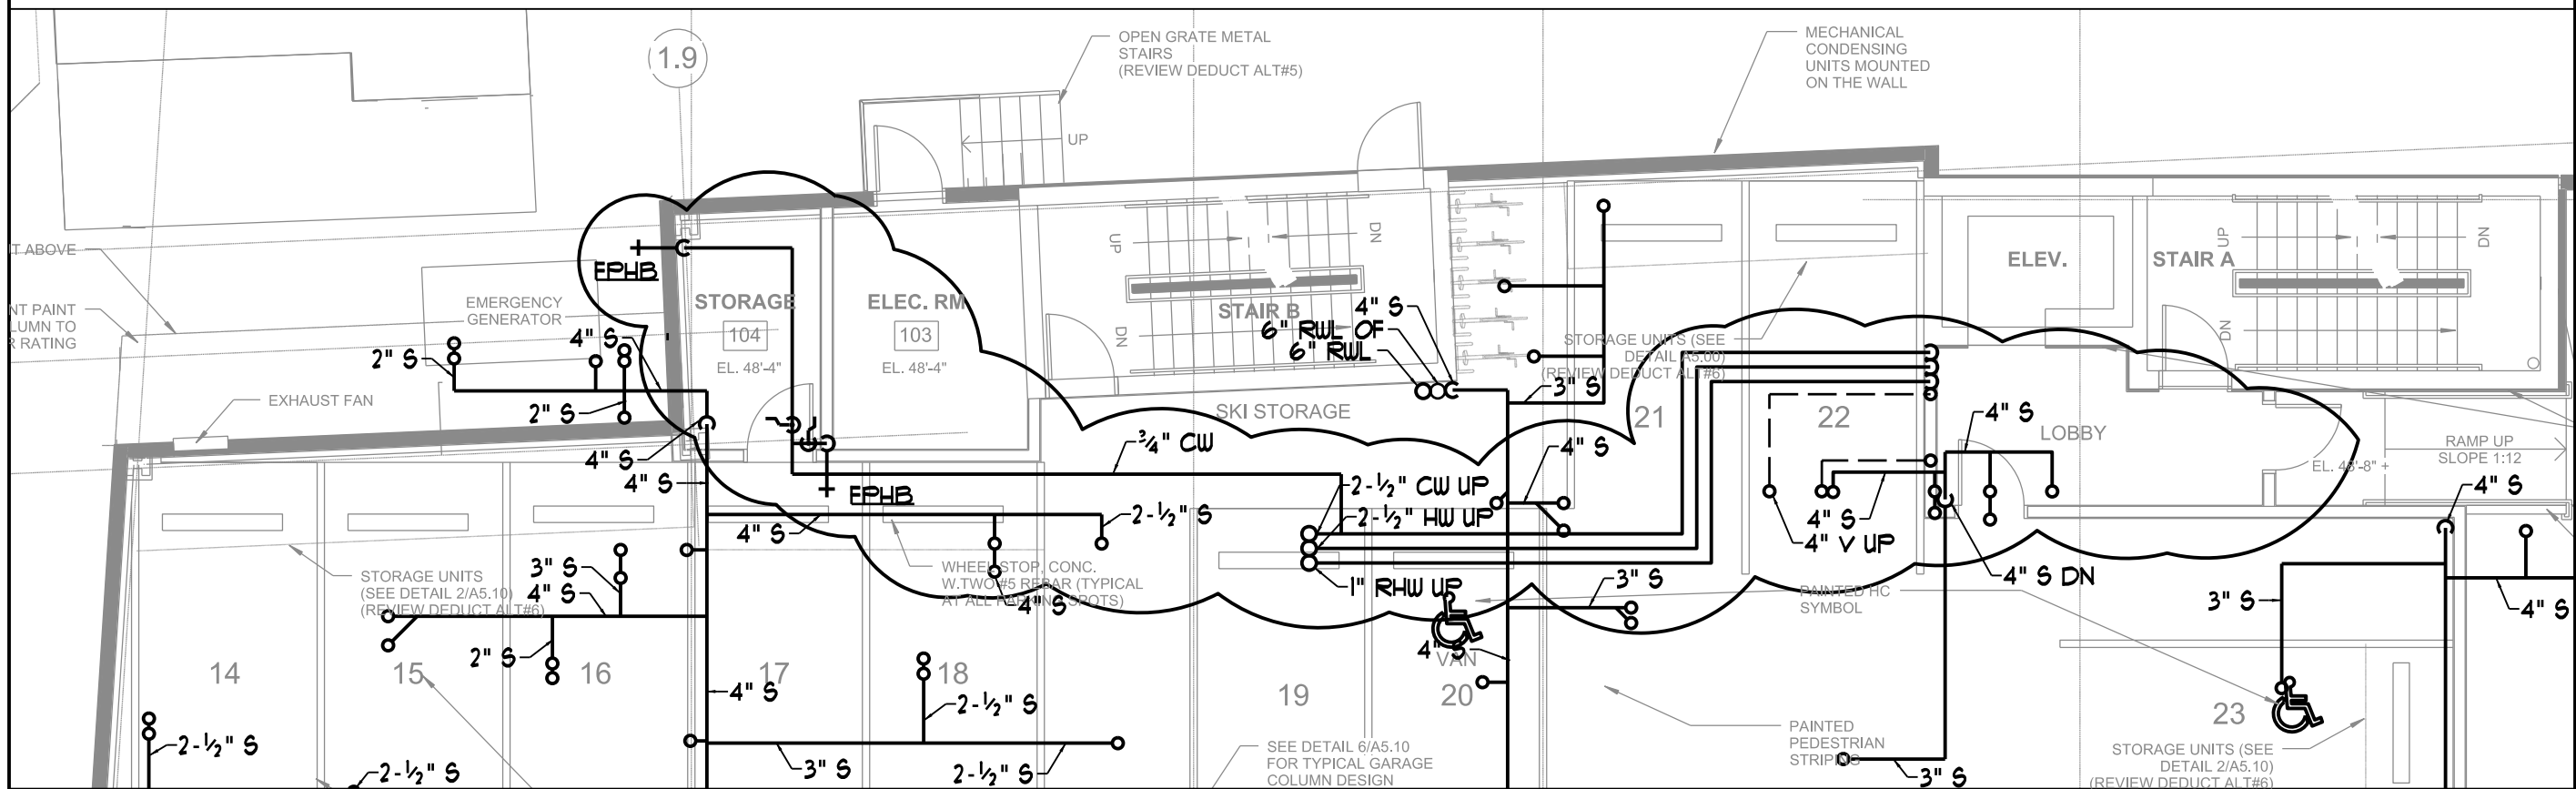

LOWER LEVEL PARTIAL PLUMBING PLAN

LUMINATO

DRAWING TITLE - WATER HEATER RELOCATION
 DESIGNED/CHECKED BY - JMV
 DATE - 1/27/16
 SCALE - 1/8" = 1'-0"

SKP-1