


HAMPSHIRE STREET

FEDERAL STREET

NEWBURY STREET

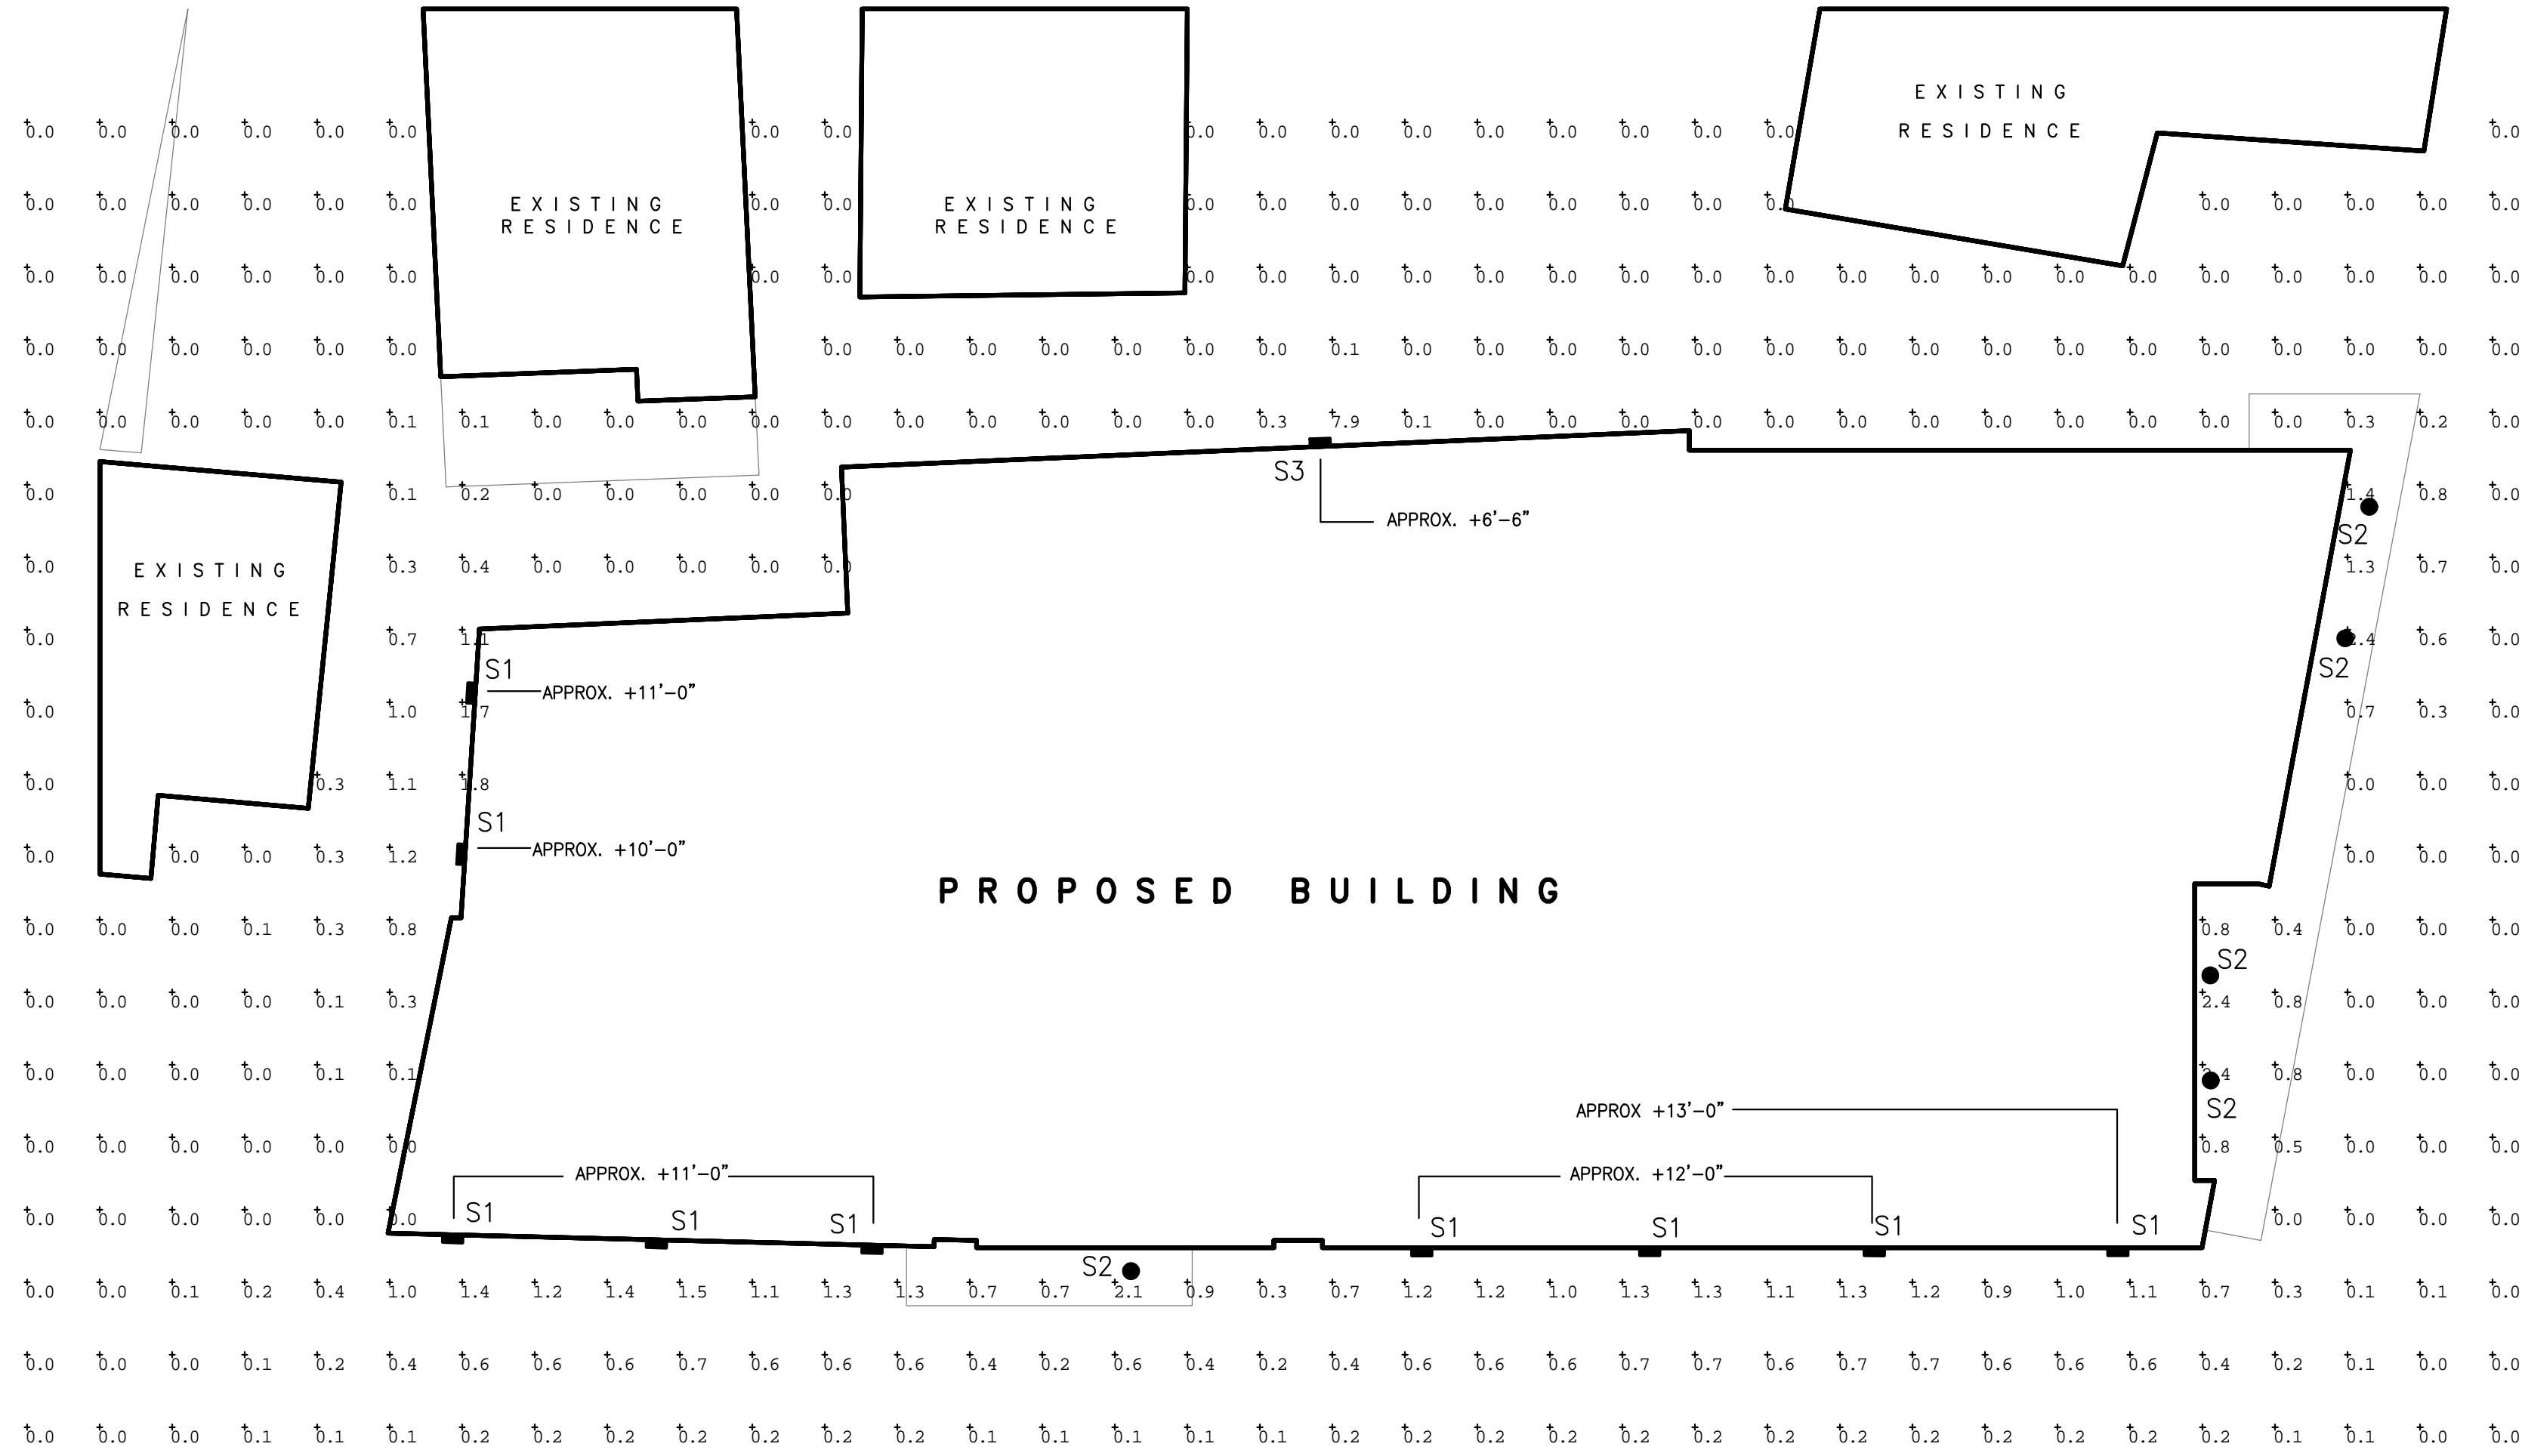

TYPE S1:
 BEGA # 2261LED 6.6W 291 LUMENS
 SURFACE WALL LUMINAIRE

TYPE S2:
 BEGA # 6604LED 6.5W 127 LUMENS
 RECESSED DOWNLIGHT LUMINAIRE


TYPE S3:
 BEGA # 6516LED.537 26W 910 LUMENS
 SURFACE WALL LUMINAIRE

FRANKLIN ARTERIAL

ILLUMINANCE VALUES INDICATED AT GRADE IN FOOTCANDLES
 EXACT MOUNTING HEIGHTS OF WALL MOUNTED LUMINAIRES ARE AS INDICATED ON ARCHITECTURAL ELEVATIONS



48 Union Wharf Portland, Maine 04101
 (207) 772-6022 Fax (207) 772-4056

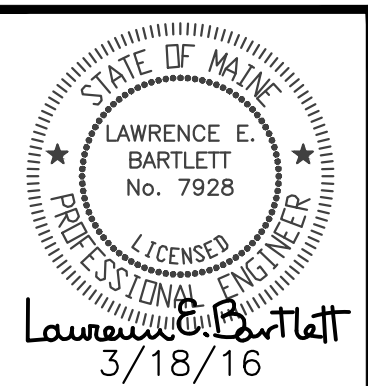

Bartlett Design
 LIGHTING & ELECTRICAL ENGINEERING
 942 WASHINGTON STREET, BATH, ME 04500
 TEL (207) 443-5447 FAX (207) 443-5560

date drawn: 03/18/16
 date issued:
 drawn by: LEB
 scale: AS NOTED

LUMINATO CONDOMINIUMS
 169 NEWBURY STREET PORTLAND, MAINE
 project
 LIGHTING CALCULATION PLAN
 drawing title

project no. 15-0044
 revisions:

E1
 sheet number

SCALE: 1" = 10'-0"

SITE LIGHTING PLAN

1