


HAMPSHIRE STREET

FEDERAL STREET

NEWBURY STREET

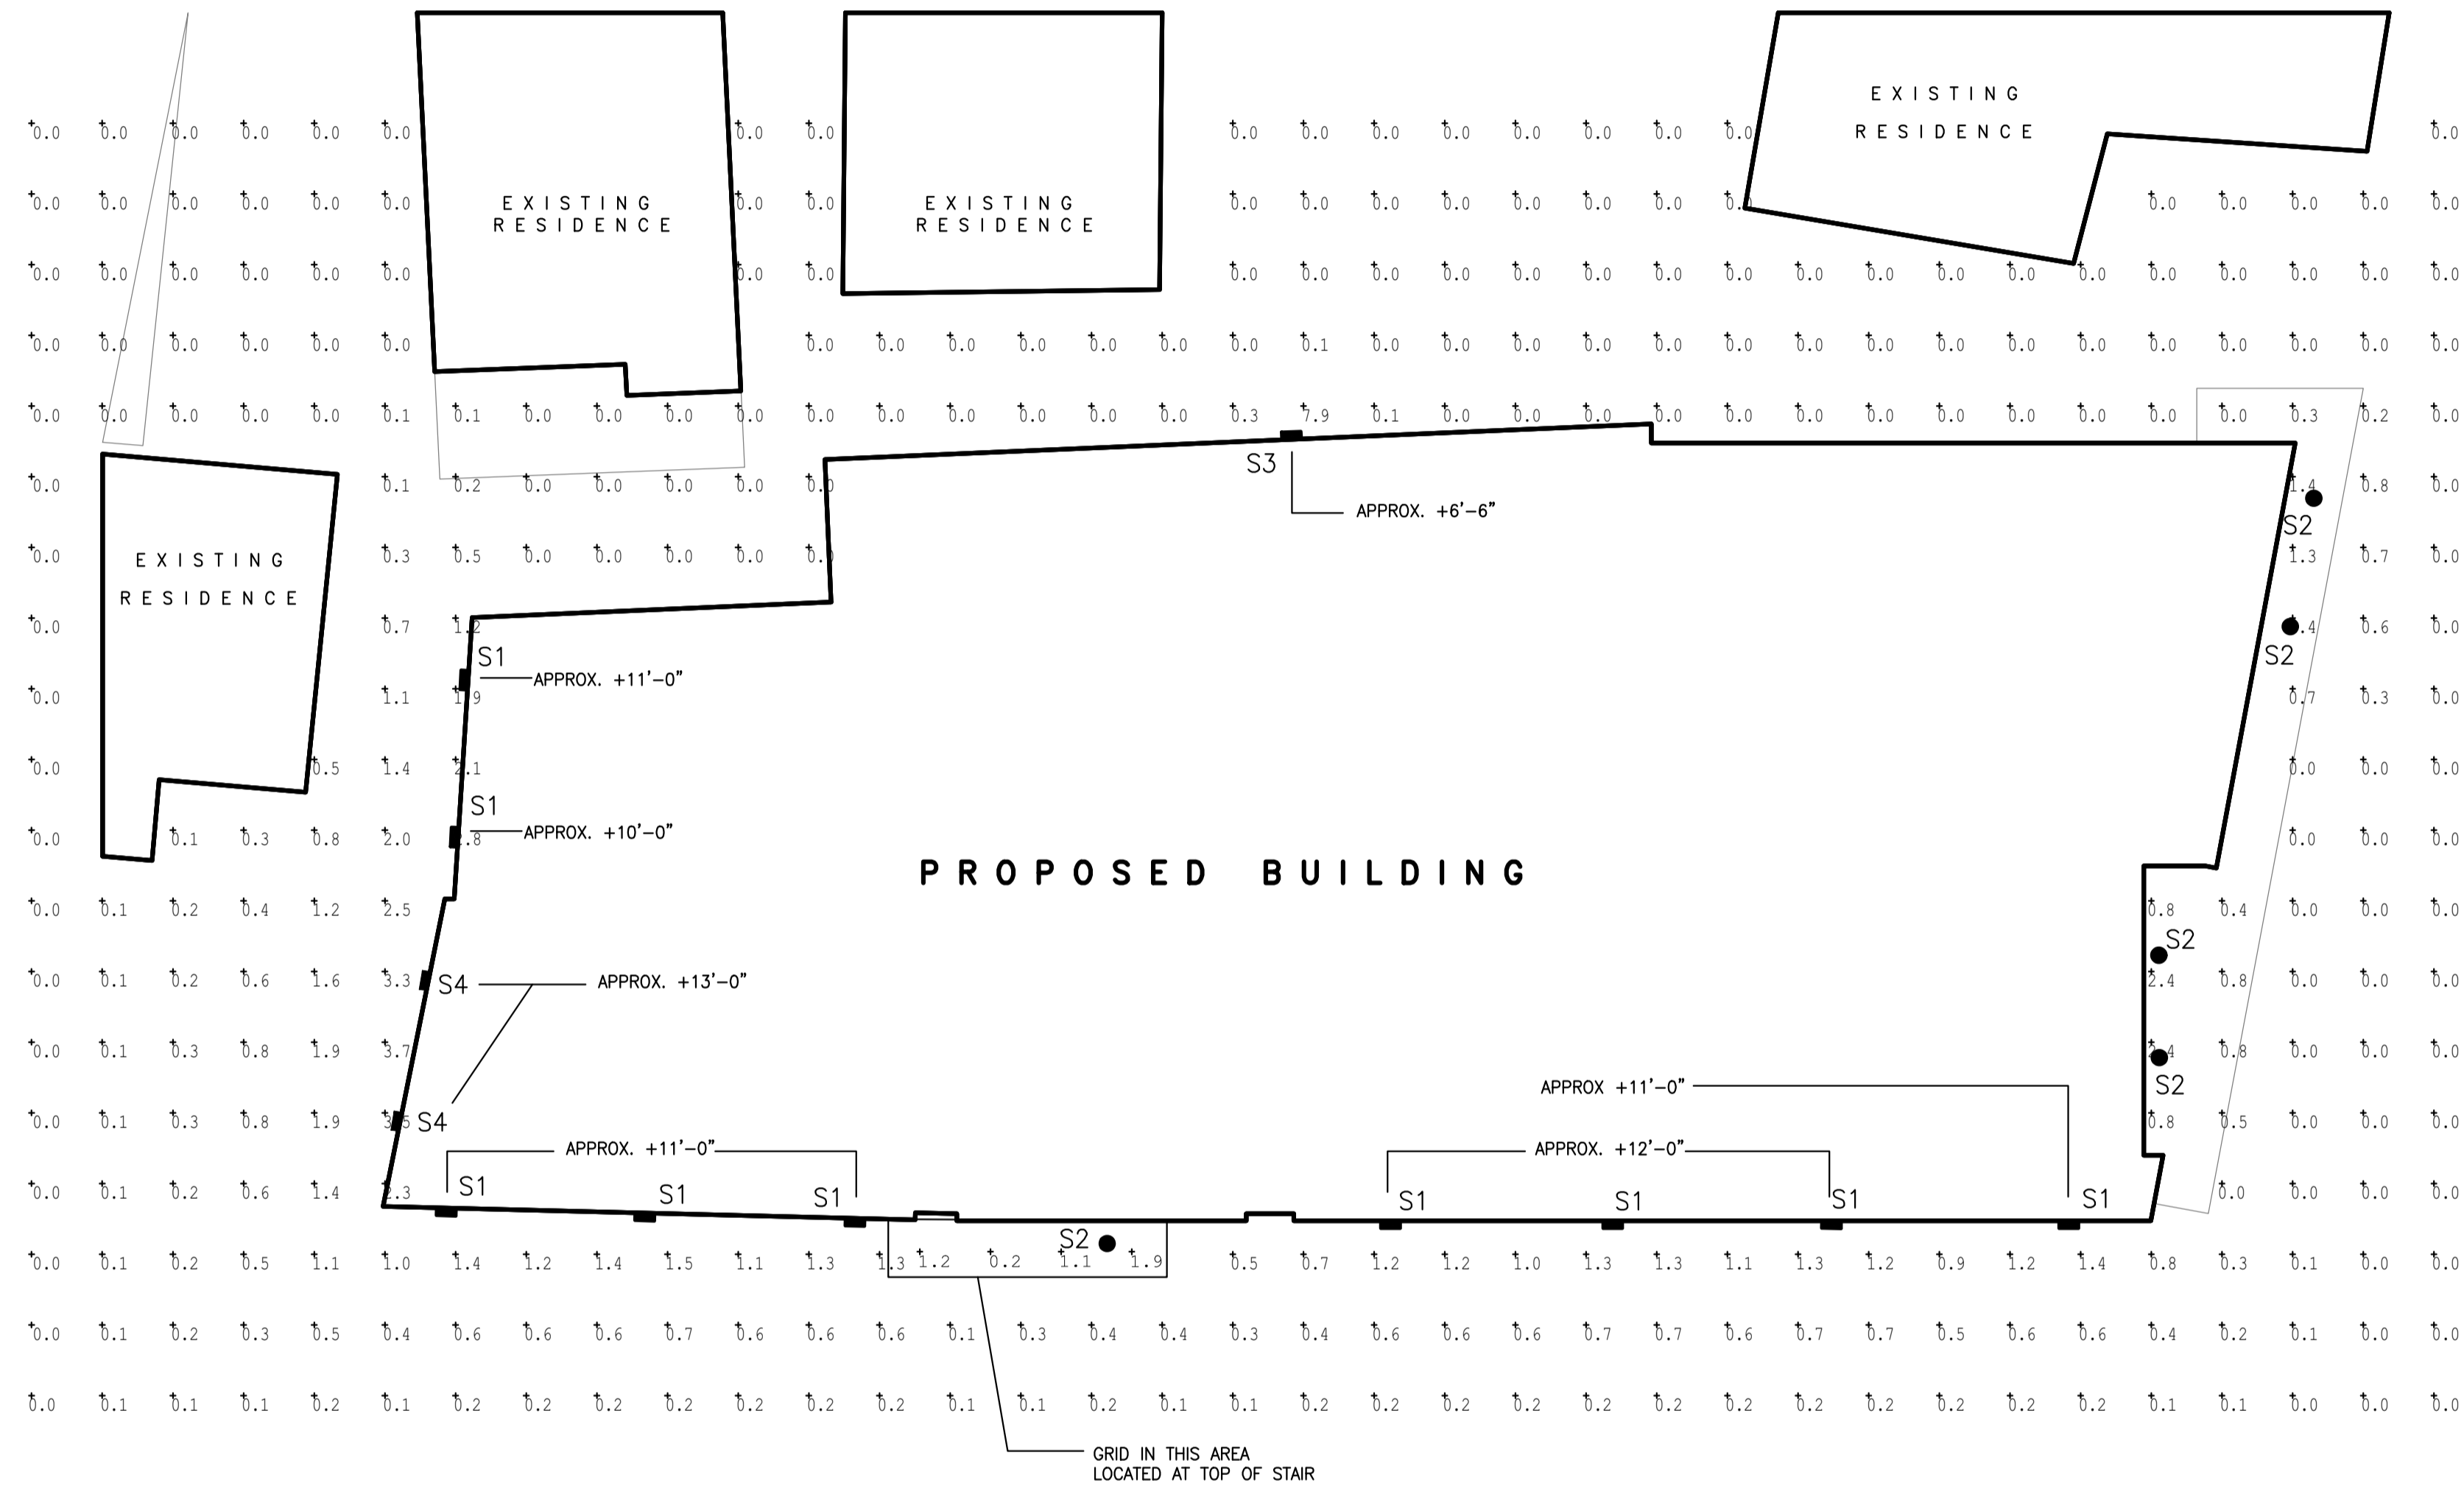

**TYPE S1:**  
 BEGA # 2261LED 6.6W 291 LUMENS  
 SURFACE WALL LUMINAIRE

**TYPE S2:**  
 BEGA # 6604LED 6.5W 127 LUMENS  
 RECESSED DOWNLIGHT LUMINAIRE

**TYPE S3:**  
 BEGA # 6516LED.537 26W 910 LUMENS  
 SURFACE WALL LUMINAIRE


**TYPE S4:**  
 BEGA # 22292 10.5W 657 LUMENS  
 SURFACE WALL LUMINAIRE

ILLUMINANCE VALUES INDICATED ARE INITIAL FOOTCANDLES LEVELS AT GRADE IN  
 EXACT MOUNTING HEIGHTS OF WALL MOUNTED LUMINAIRES ARE AS INDICATED ON ARCHITECTURAL ELEVATIONS

FRANKLIN ARTERIAL



48 Union Wharf Portland, Maine 04101  
 (207) 772-6022 Fax (207) 772-4056

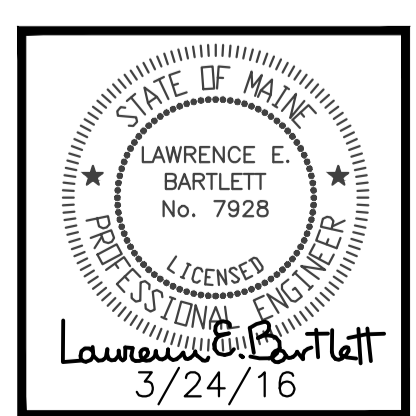

**Bartlett Design**  
 LIGHTING & ELECTRICAL ENGINEERING  
 942 WASHINGTON STREET, BATH, ME 04530  
 TEL (207) 443-5447 FAX (207) 443-5560

date drawn: 03/24/16  
 date issued: 03/24/16  
 drawn by: LEB  
 scale: 1" = 10'-0"

**LUMINATO CONDOMINIUMS**  
 169 NEWBURY STREET  
 PORTLAND, MAINE

project  
 drawing title

project no. 15-0044  
 revisions:

**E1**

SCALE: 1" = 10'-0"  
 SITE LIGHTING PLAN 1

CITY OF PORTLAND  
 et n... APPROVED SITE PLAN  
 Subject to Conditions of Approval  
 and Standard Conditions

DATE of APPROVAL: March 31, 2016  
 PLANNER: Caitlin Cameron  
 PROJECT NO.: 2016-021