


HAMPSHIRE STREET

FEDERAL STREET

NEWBURY STREET

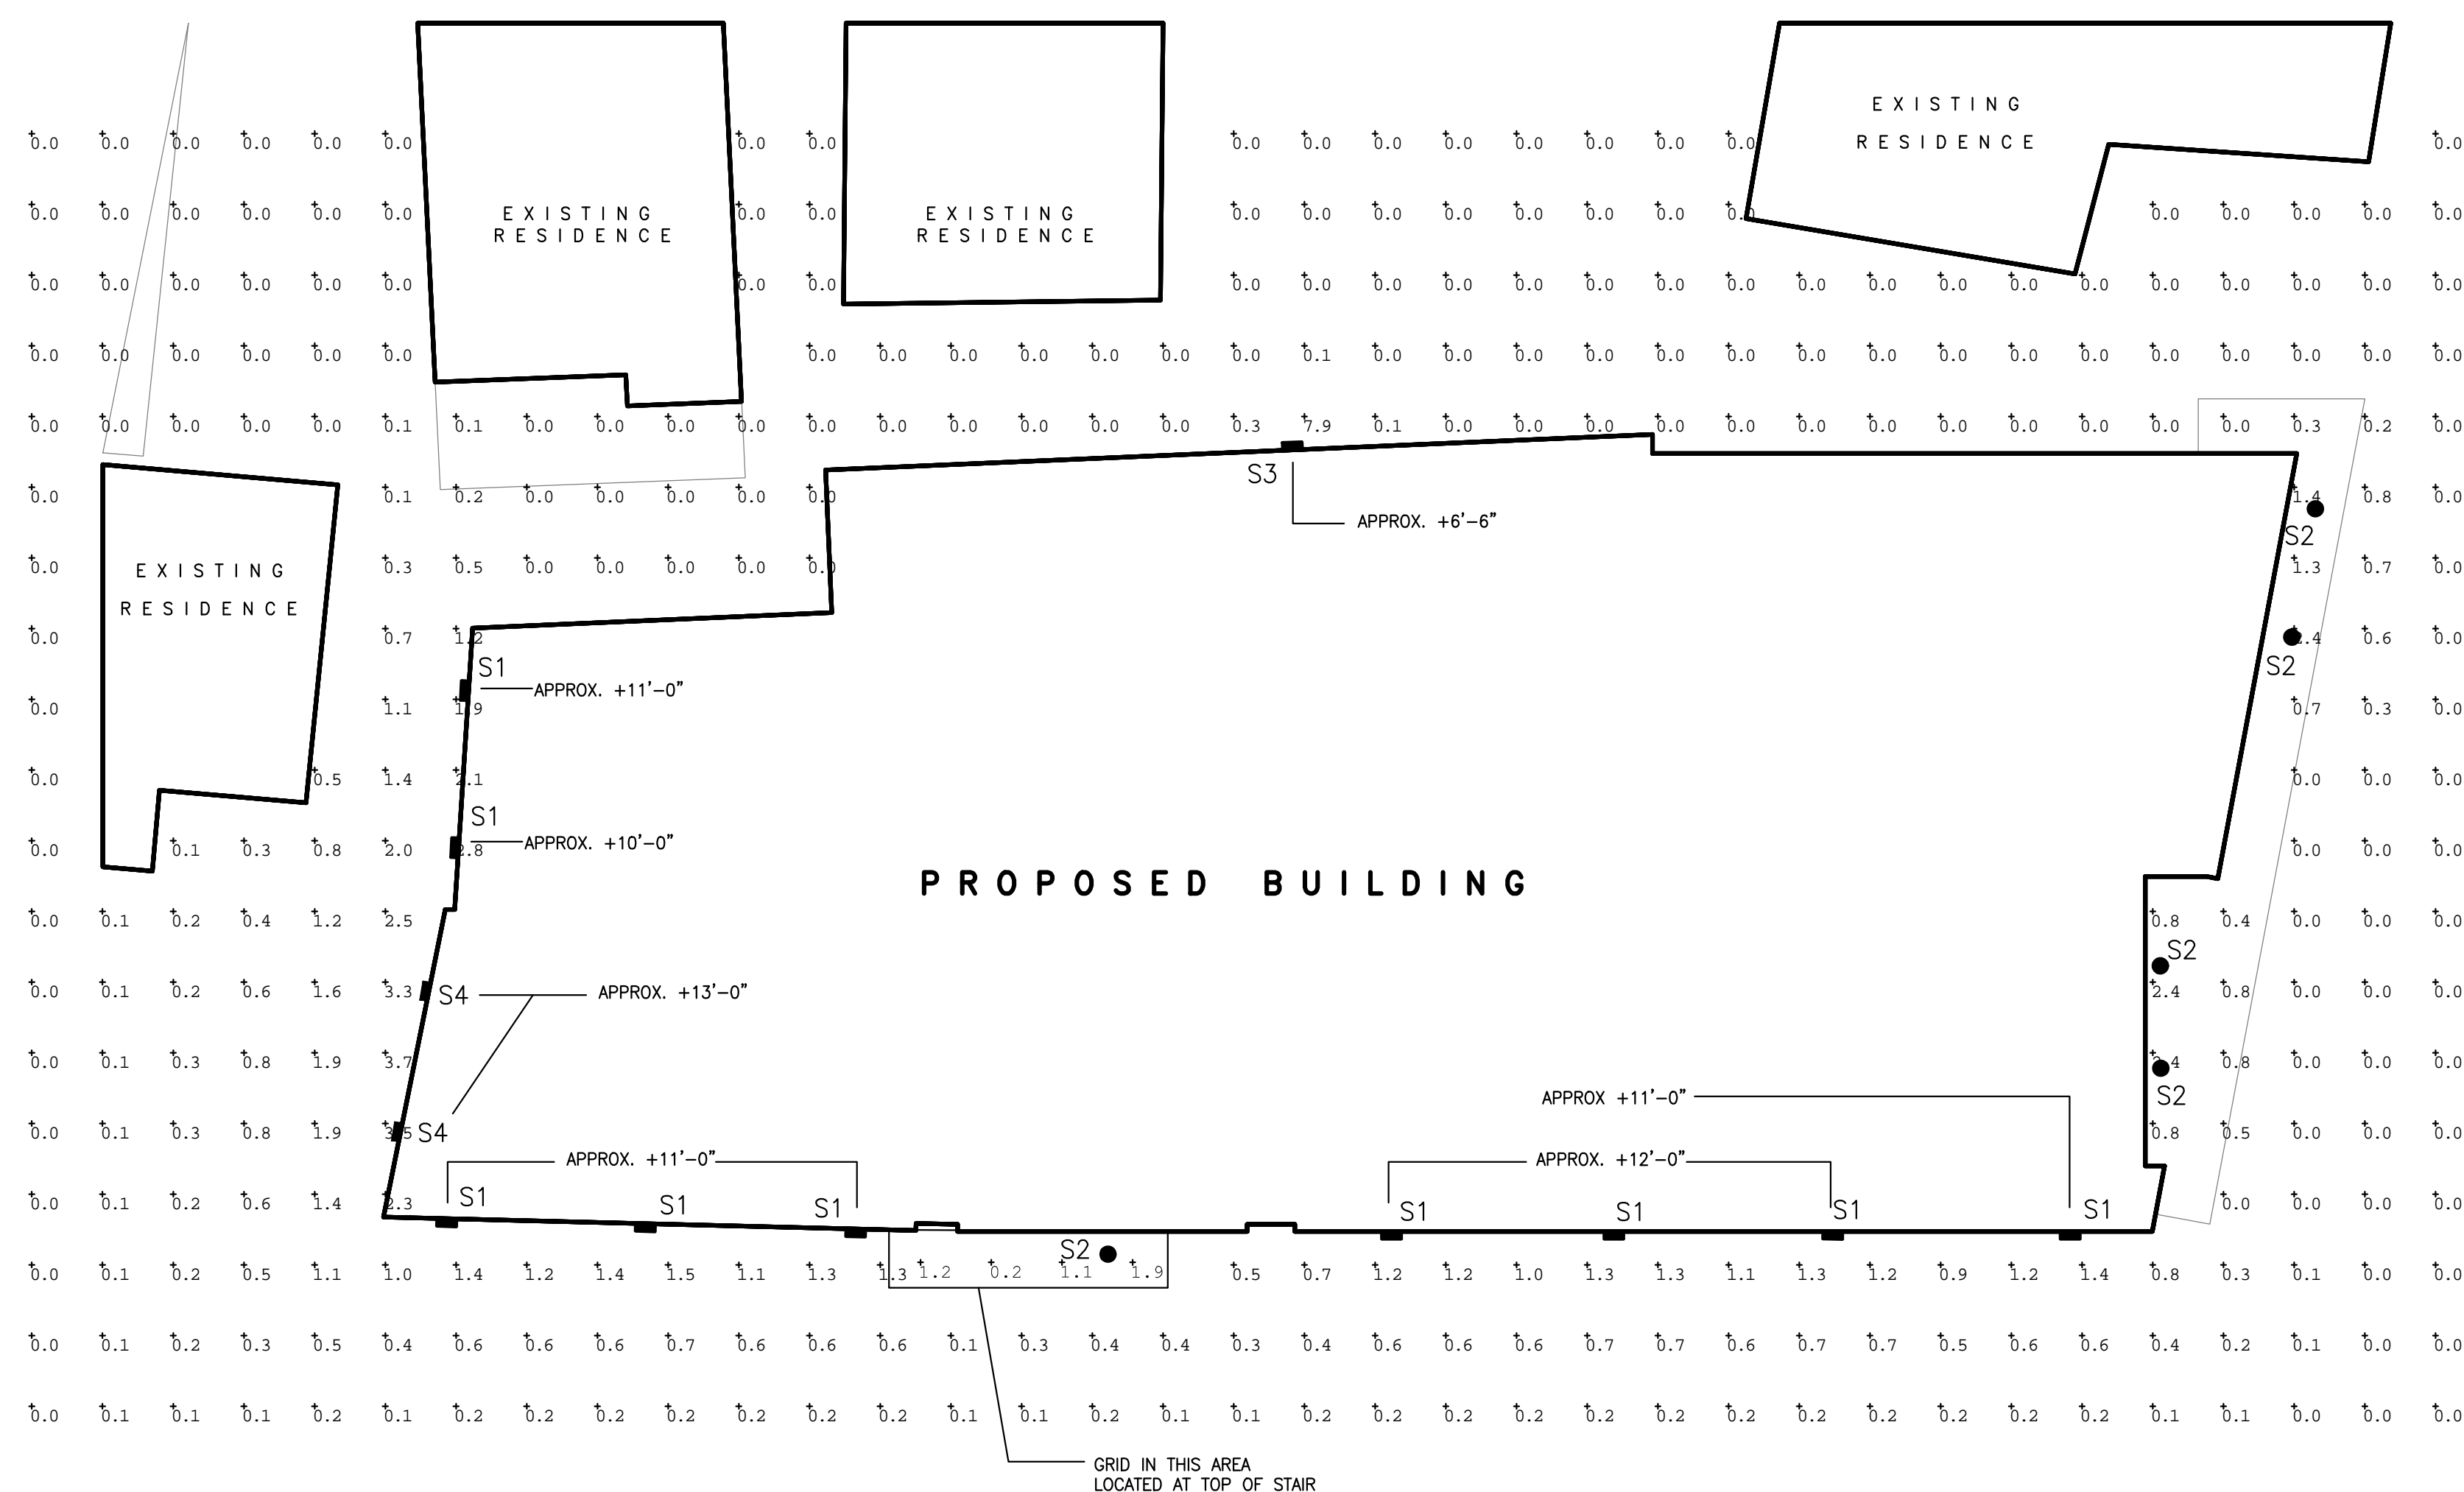


- TYPE S1:
BEGA # 2261LED 6.6W 291 LUMENS
SURFACE WALL LUMINAIRE
- TYPE S2:
BEGA # 6604LED 6.5W 127 LUMENS
RECESSED DOWNLIGHT LUMINAIRE
- TYPE S3:
BEGA # 6516LED.537 26W 910 LUMENS
SURFACE WALL LUMINAIRE
- TYPE S4:
BEGA # 22292 10.5W 657 LUMENS
SURFACE WALL LUMINAIRE

ILLUMINANCE VALUES INDICATED ARE INITIAL FOOTCANDLES LEVELS AT GRADE IN EXACT MOUNTING HEIGHTS OF WALL MOUNTED LUMINAIRES ARE AS INDICATED ON ARCHITECTURAL ELEVATIONS

FRANKLIN ARTERIAL



48 Union Wharf Portland, Maine 04101
(207) 772-6022 Fax (207) 772-4056

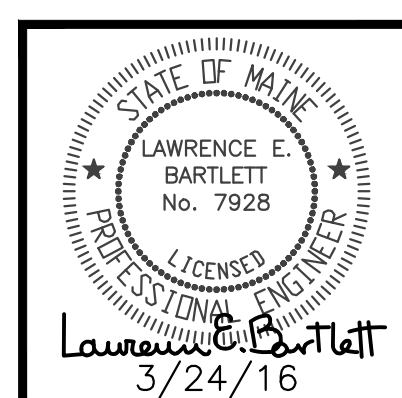

Bartlett Design
LIGHTING & ELECTRICAL ENGINEERING
942 WASHINGTON STREET, BATH, ME 04530
TEL (207) 443-5447 FAX (207) 443-5580

date drawn: 03/24/16
date issued: 03/24/16
drawn by: LEB
scale: 1" = 10'-0"

project: **LUMINATO CONDOMINIUMS**
169 NEWBURY STREET
PORTLAND, MAINE
drawing title: **LIGHTING CALCULATION PLAN**

project no. 15-0044
revisions:

E1
sheet number

SCALE: 1" = 10'-0"

SITE LIGHTING PLAN 1