




33 HAMPSHIRE ST. PORTLAND, MAINE 04103


DATE: 11/11/11
SCALE: 1/8" = 1'-0"
SHEET NO.: 11
PROJECT: 33 HAMPSHIRE ST. PORTLAND, MAINE 04103

33 HAMPSHIRE A102 THIRD AND FOURTH FLOOR PLAN

MECHANICAL

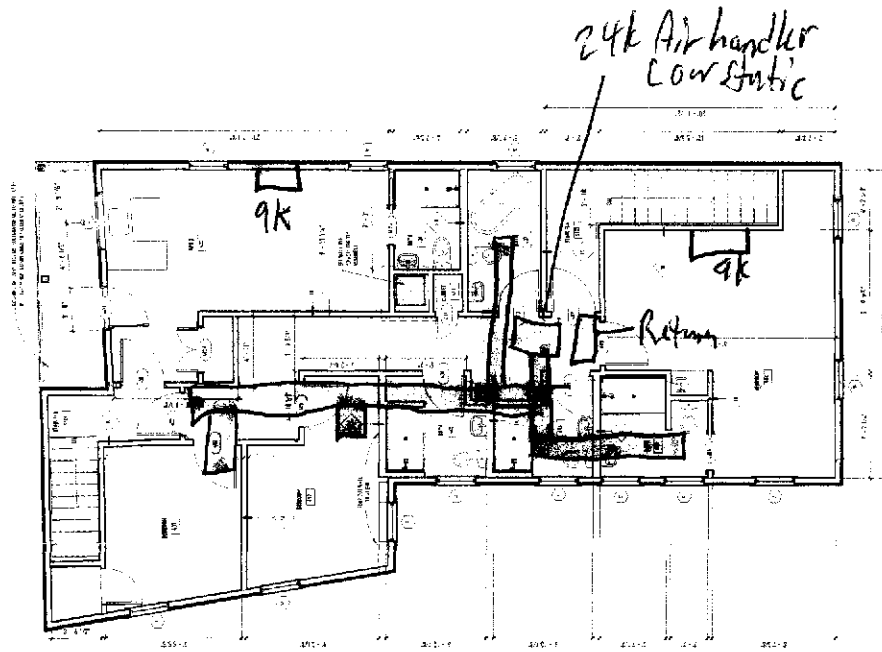

18 Gauge duct

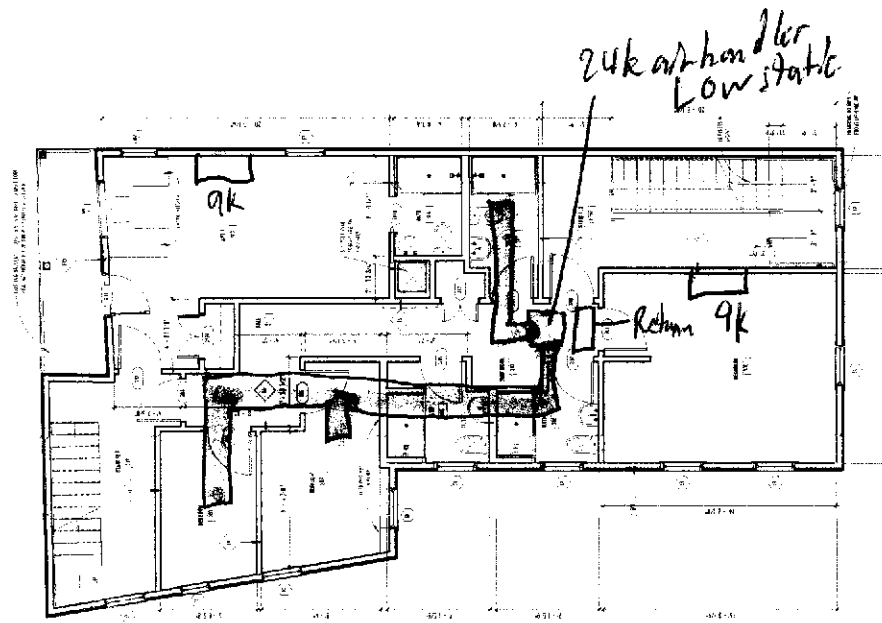

18 Gauge duct

MECHANICAL