



**KEY PLAN**

1/16"=1'-0"

**DEMOLITION NOTES:**

1. ALL WALLS AS SHOWN TO BE REMOVED. G.C. TO FIELD VERIFY & REPORT ANY DISCREPANCIES OR LOAD BEARING WALLS TO THE ARCHITECT.
2. ELECTRIC POWER TO THE TENANT SPACE ONLY SHALL BE DISCONNECTED PRIOR TO DEMOLITION. VERIFY WATER SHUT-OFF W/ BUILDING OWNER. EXISTING DUCT WORK TO REMAIN SHALL BE SEALED. SPRINKLER SYSTEMS, WHERE APPLICABLE, SHALL REMAIN OPERATIONAL UNLESS PERMITTED BY THE CITY BUILDING INSPECTOR. FIRE ALARM SYSTEMS TO REMAIN FULLY OPERATIONAL DURING DEMOLITION.
3. DUST BARRIER PARTITIONING SHALL BE INSTALLED @ TENANT SEPARATIONS.
4. ALL DEMOLITION SHALL BE REMOVED FROM THE REAR OF THE BUILDING ONLY.
5. REMOVE EXISTING CEILINGS IN THEIR ENTIRETY.
6. ALL FIRE PROTECTION, GYPSUM DRYWALL &/ OR FIRESPRAY ON STRUCTURAL MEMBERS; INCLUDING BEARING WALLS, FIRE SEPARATION WALLS, BEAMS, COLUMNS & FIRE RATED FLOOR/ CEILING ASSEMBLIES SHALL NOT BE REMOVED.
7. PROTECT ALL FINISHES, MATERIALS AND EQUIPMENT NOTED AS EXISTING TO REMAIN.
8. DIMENSIONS INDICATED +/- ARE EXISTING CONDITION DIMENSIONS TO BE VERIFIED IN FIELD.
9. REMOVE EXISTING PLUMBING FIXTURES IF ANY, VENTING AND ASSOCIATED EXHAUST FANS, CAP PLUMBING FLUSH WITH FLOOR.
10. G.C. TO VERIFY WITH 'DIG SAFE' PRIOR TO ANY SITE WORK.
11. FIELD VERIFY ALL STRUCTURAL COMPONENTS PRIOR TO DEMOLITION. REPORT ANY DISCREPANCIES IMMEDIATELY TO ARCHITECT.


AREA OF NEW  
TENANT  
SPACE WORK  
(SHADED)

AREA OF NEW  
ENTRY VESTIBULE  
@ FACADE



**1ST FLOOR EXISTING PLAN**

1/8"=1'-0"

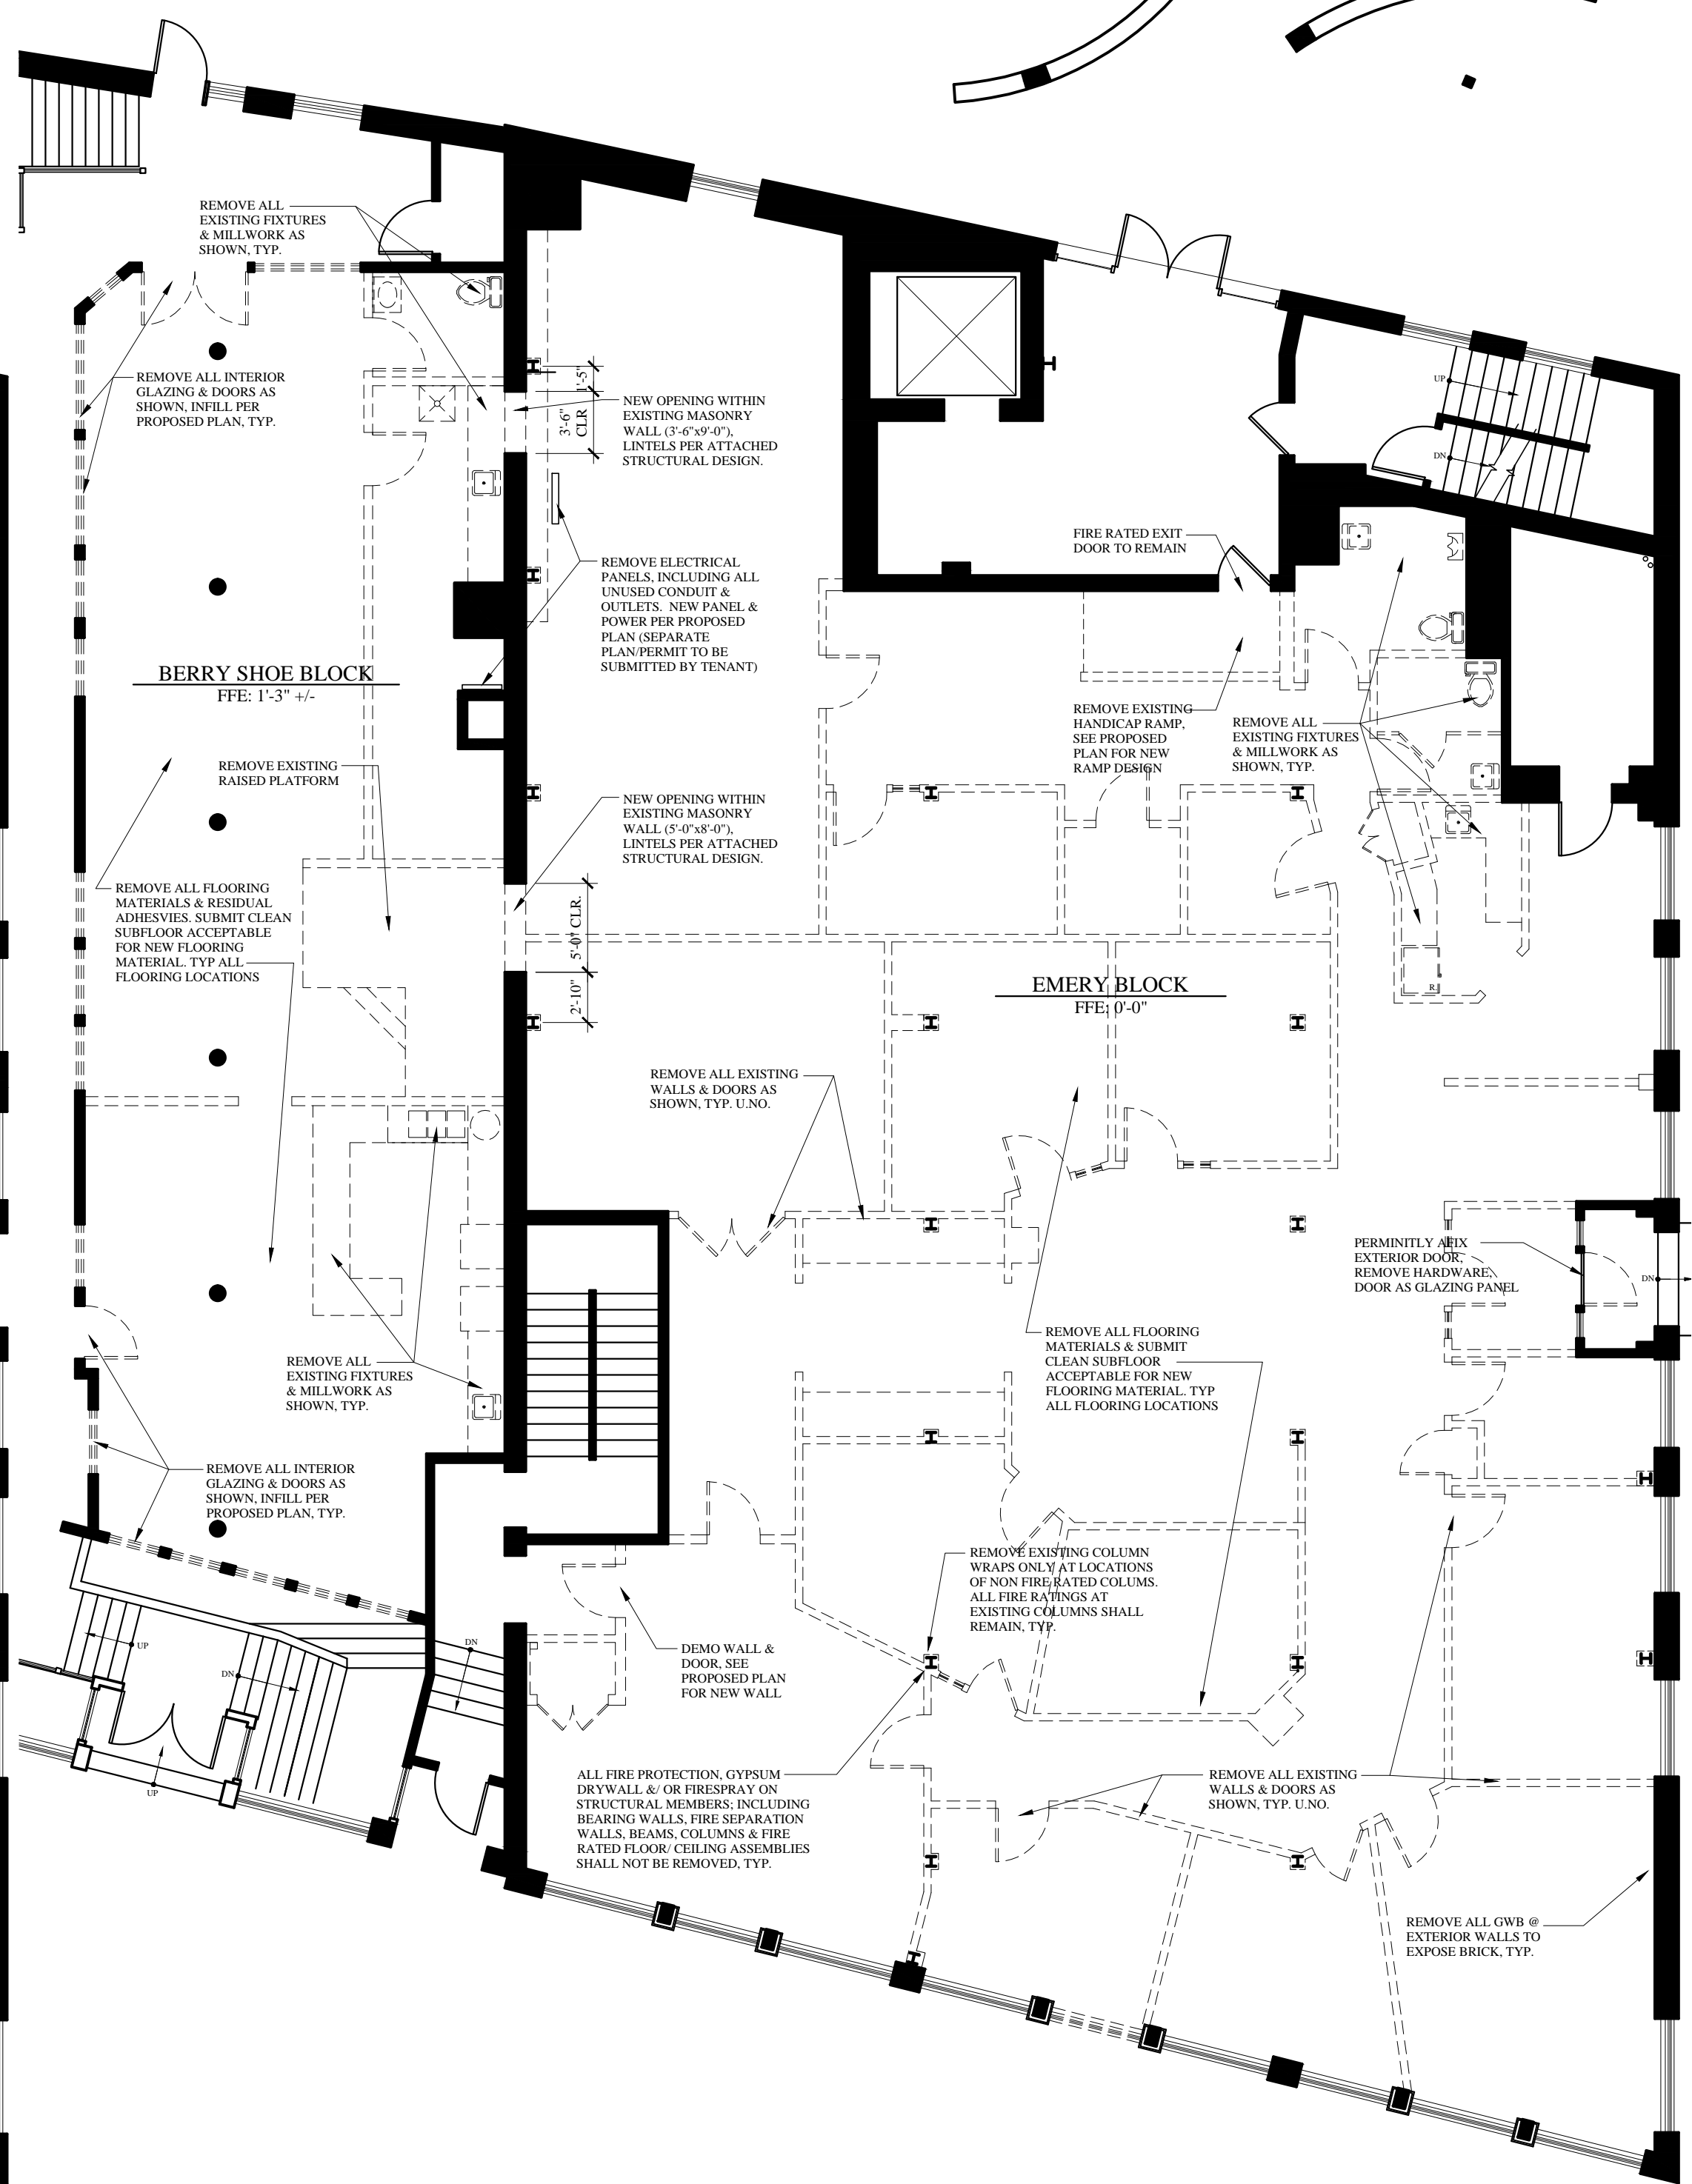

**1ST FLOOR DEMO PLAN**

1/8"=1'-0"

**WALL LEGEND**

EXISTING WALL	
NEW WALL	
FIRE RATED WALL	
BRICK WALL	
1 HOUR	
EXISTING WALL TO BE REMOVED	

**MARK MUELLER ARCHITECTS**  
A.I.A.  
100 Commercial Street  
Suite 205  
Portland, Maine 04101  
Phone: 207.774.9057  
Email: rfm@muellerarchitects.com


© COPYRIGHT 2014  
MARK MUELLER ARCHITECTS

**ANTHROPOLOGIE**  
66 PEARL STREET  
PORTLAND, MAINE

INTERIOR DEMOLITION

DEMOLITION PLAN

REVISIONS	DATE
	JULY 2014
PROJECT	ANTHROPOLOGIE
DRAWN BY	MRP
CHECK BY	MM

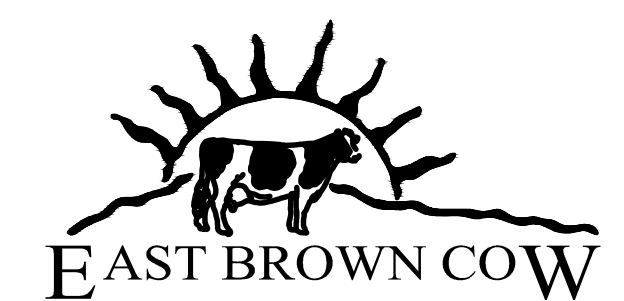

**EAST BROWN COW**

**ADDENDA SET: AUGUST 04, 2014**  
**BUILDING PERMIT SET: JULY 01, 2013**

**D-1.1**