


### REFLECTED CEILING PLAN NOTES

- 1.) PROVIDE EXIT AND EMERGENCY LIGHTING TO MEET ALL APPLICABLE CODES
- 2.) MODIFY EXISTING SPRINKLER SYSTEM AS REQUIRED TO MEET ALL APPLICABLE CODE FOR NEW SPACE LAYOUT AND CEILINGS.
- 3.) PROVIDE ALL REQUIRED (SMOKE, HEAT, CO, VISUAL, AUDIBLE) ALARMS AS REQUIRED BY ALL APPLICABLE CODES.

### LIGHT FIXTURE SCHEDULE

KEY	SYMBOL	DESCRIPTION
A		PENDANT FIXTURE HUNG FROM CEILING
B		CHANDELIER HUNG FROM CEILING
C		WALL SCONCE (ADA)
D		RECESSED
E		RECESSED WALL WASHER
F		RECESSED
G		WALL WASHER MOUNT TO EXISTING TRACK

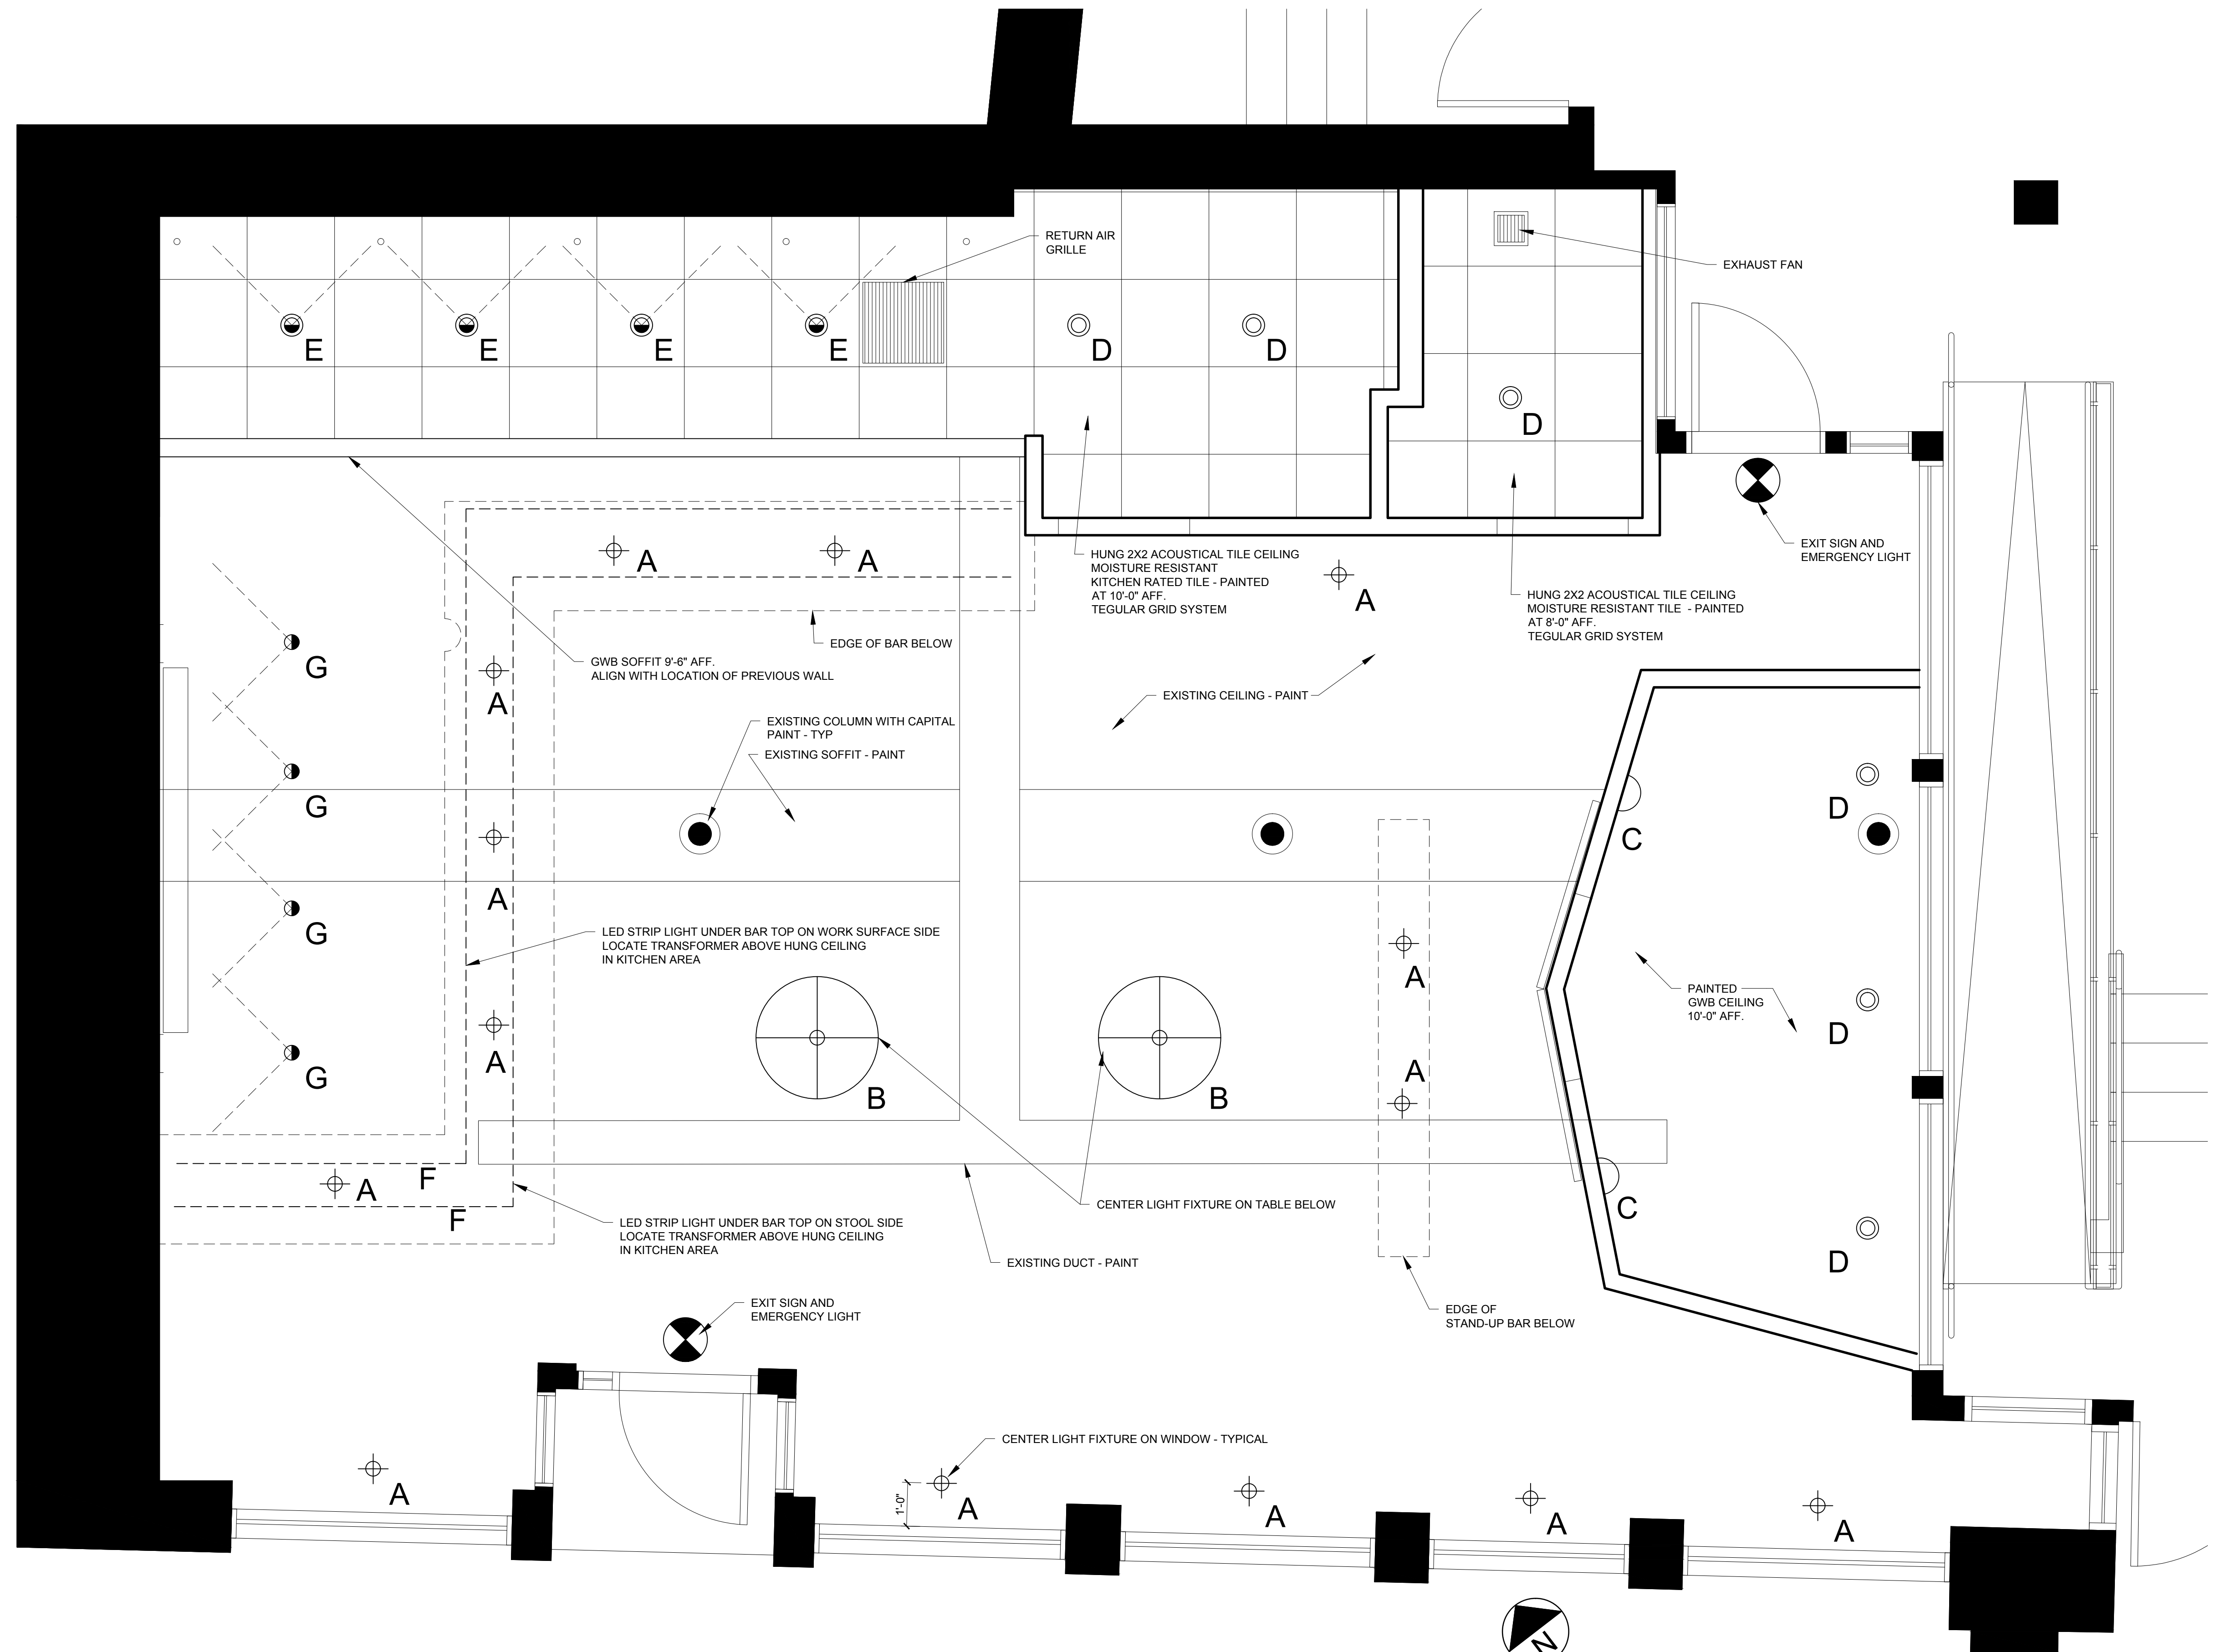

1 REFLECTED CEILING PLAN  
1/2" = 1'-0"



© 2013 RYAN SENATORE ARCHITECTURE

**PORTLAND HUNT AND ALPINE CLUB**  
75 MARKET STREET  
PORTLAND, MAINE



CONSULTANTS:

REVISIONS:

DATE: MAY 9, 2013  
PROJECT No.  
DRAWN BY:  
CHECKED BY: RJS  
SCALE: AS NOTED  
SHEET TITLE:  
REFLECTED CEILING PLAN

A1-1