

City of Portland
PUBLIC SAFETY BUILDING
 Crime Lab Project

Winton Scott Architects
 5 Milk Street
 Portland, ME 04101

Becker Structural Engineers, Inc.
 75 York Street
 Portland, Maine 04101

Mechanical Systems Engineers
 10 Royal River Center
 Yarmouth, Maine 04096


Bartlett Design
 942 Washington St.
 Bath, ME 04530

THIRD FLOOR
 PLUMBING PLAN
 AREA A

P2

M.S.E. Proj. 0811




Scale: 1/8"=1'-0" Date: 6/16/08

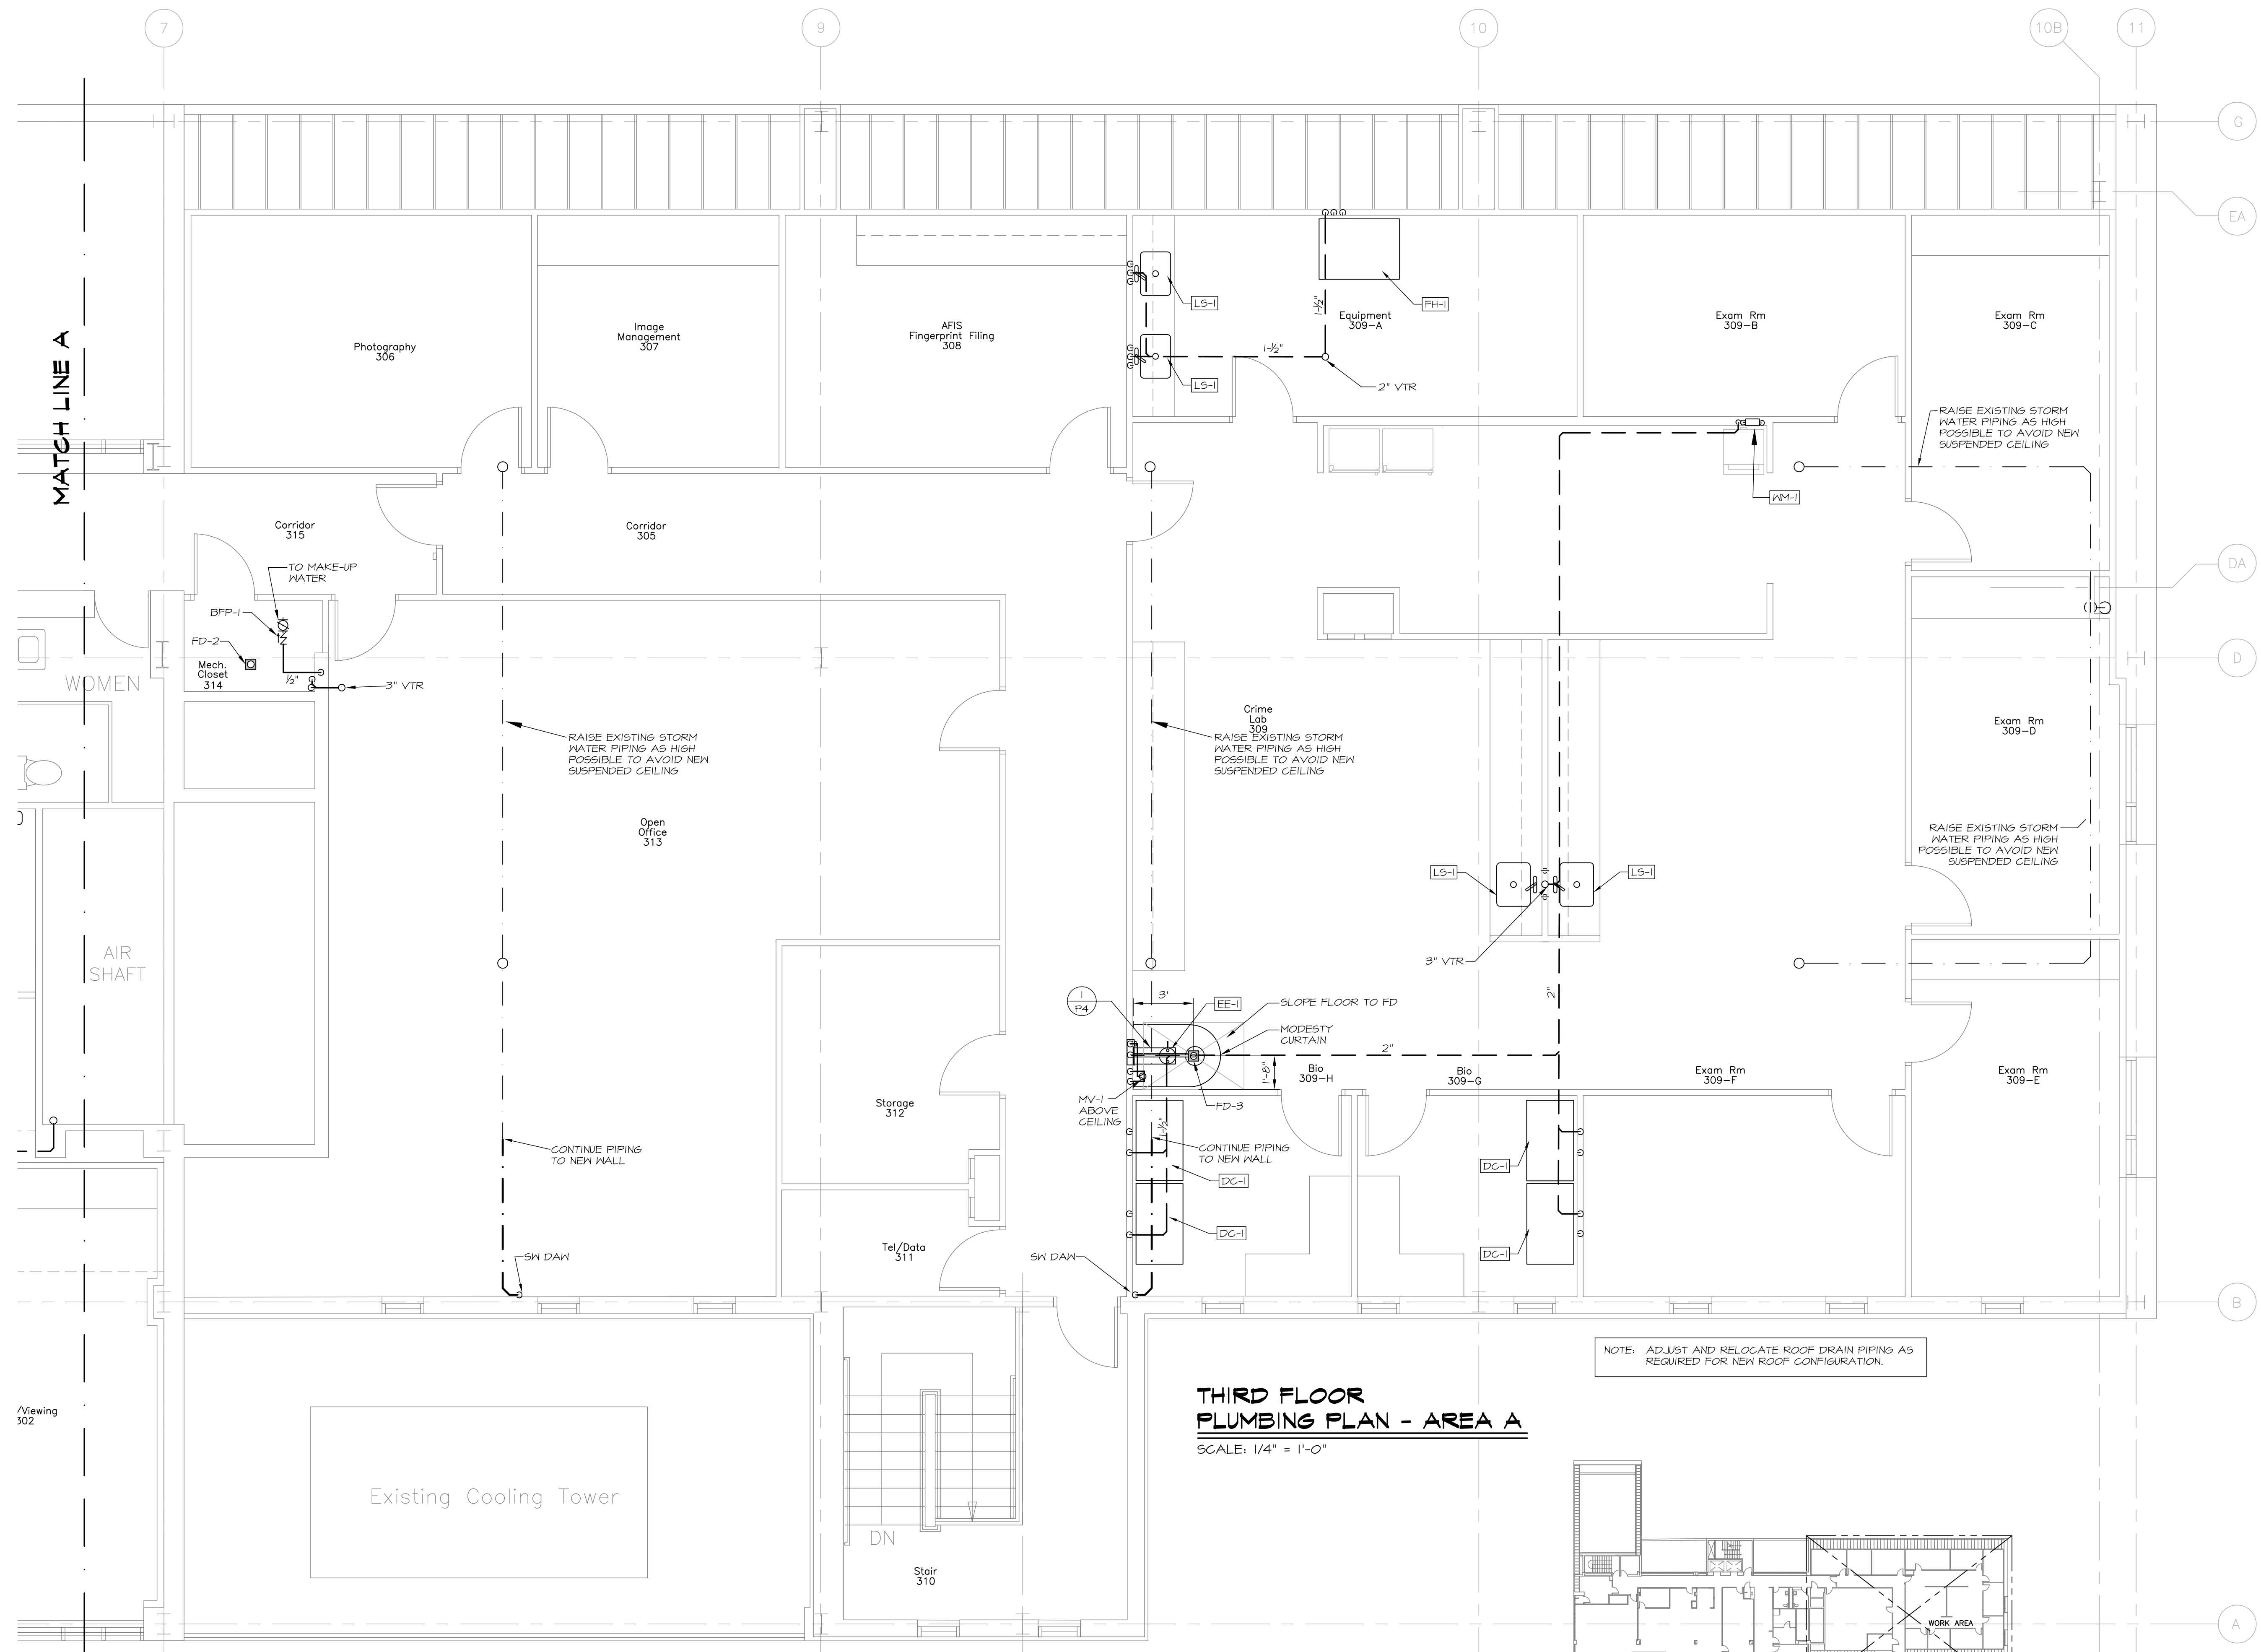

**THIRD FLOOR
 PLUMBING PLAN - AREA A**

SCALE: 1/4" = 1'-0"

NOTE: ADJUST AND RELOCATE ROOF DRAIN PIPING AS REQUIRED FOR NEW ROOF CONFIGURATION.

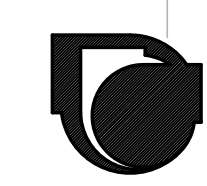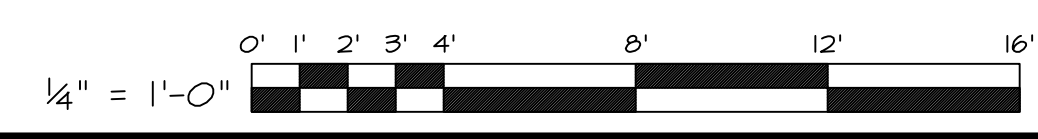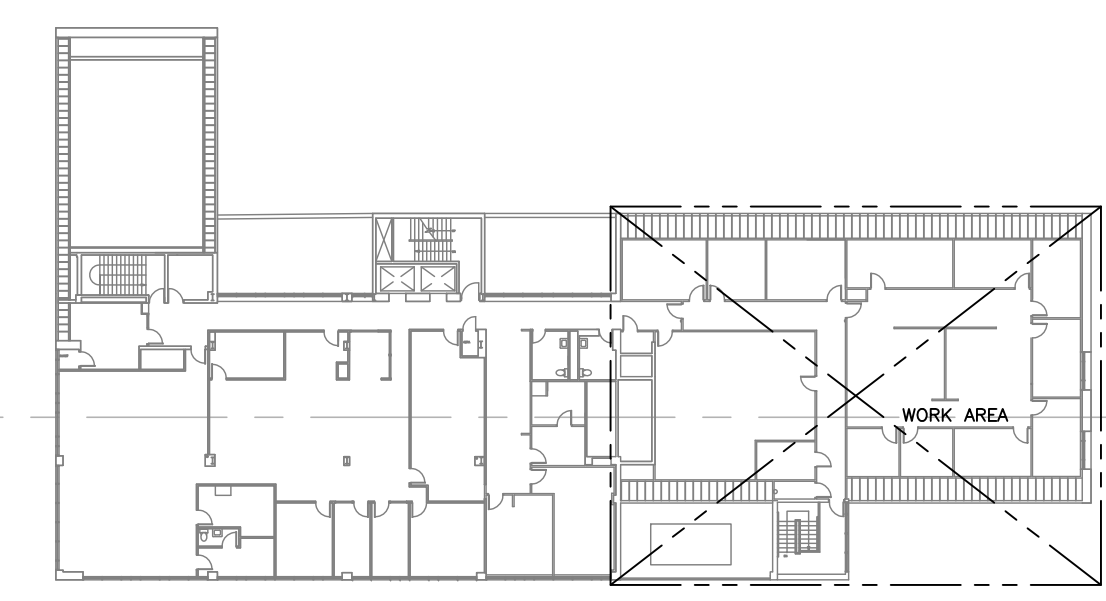

MECHANICAL SYSTEMS ENGINEERS
 ROYAL RIVER CENTER, UNIT #10
 10 FOREST FALLS DRIVE
 YARMOUTH, MAINE 04096
 VOICE: (207) 846-1441
 FAX: (207) 846-1443
 mechsys@maine.rr.com
 © COPYRIGHT 2008

June 18, 2008 - 7:56 am
 \\Mse\ps1\Projects\0811 - Portland Crime Lab\Drawings\0811 P1-P3.dwg

Viewing
 302