

City of Portland  
**PUBLIC SAFETY BUILDING**  
 Crime Lab Project

**Winton Scott Architects**  
 5 Milk Street  
 Portland, ME 04101

**Becker Structural Engineers, Inc.**  
 75 York Street  
 Portland, Maine 04101

**Mechanical Systems Engineers**  
 10 Royal River Center  
 Yarmouth, Maine 04096


**Bartlett Design**  
 942 Washington St.  
 Bath, ME 04530

THIRD FLOOR  
 MECHANICAL  
 PIPING PLAN



**M5**

M.S.E. Proj. 0811

Scale: 1/8"=1'-0" Date: 6/16/08

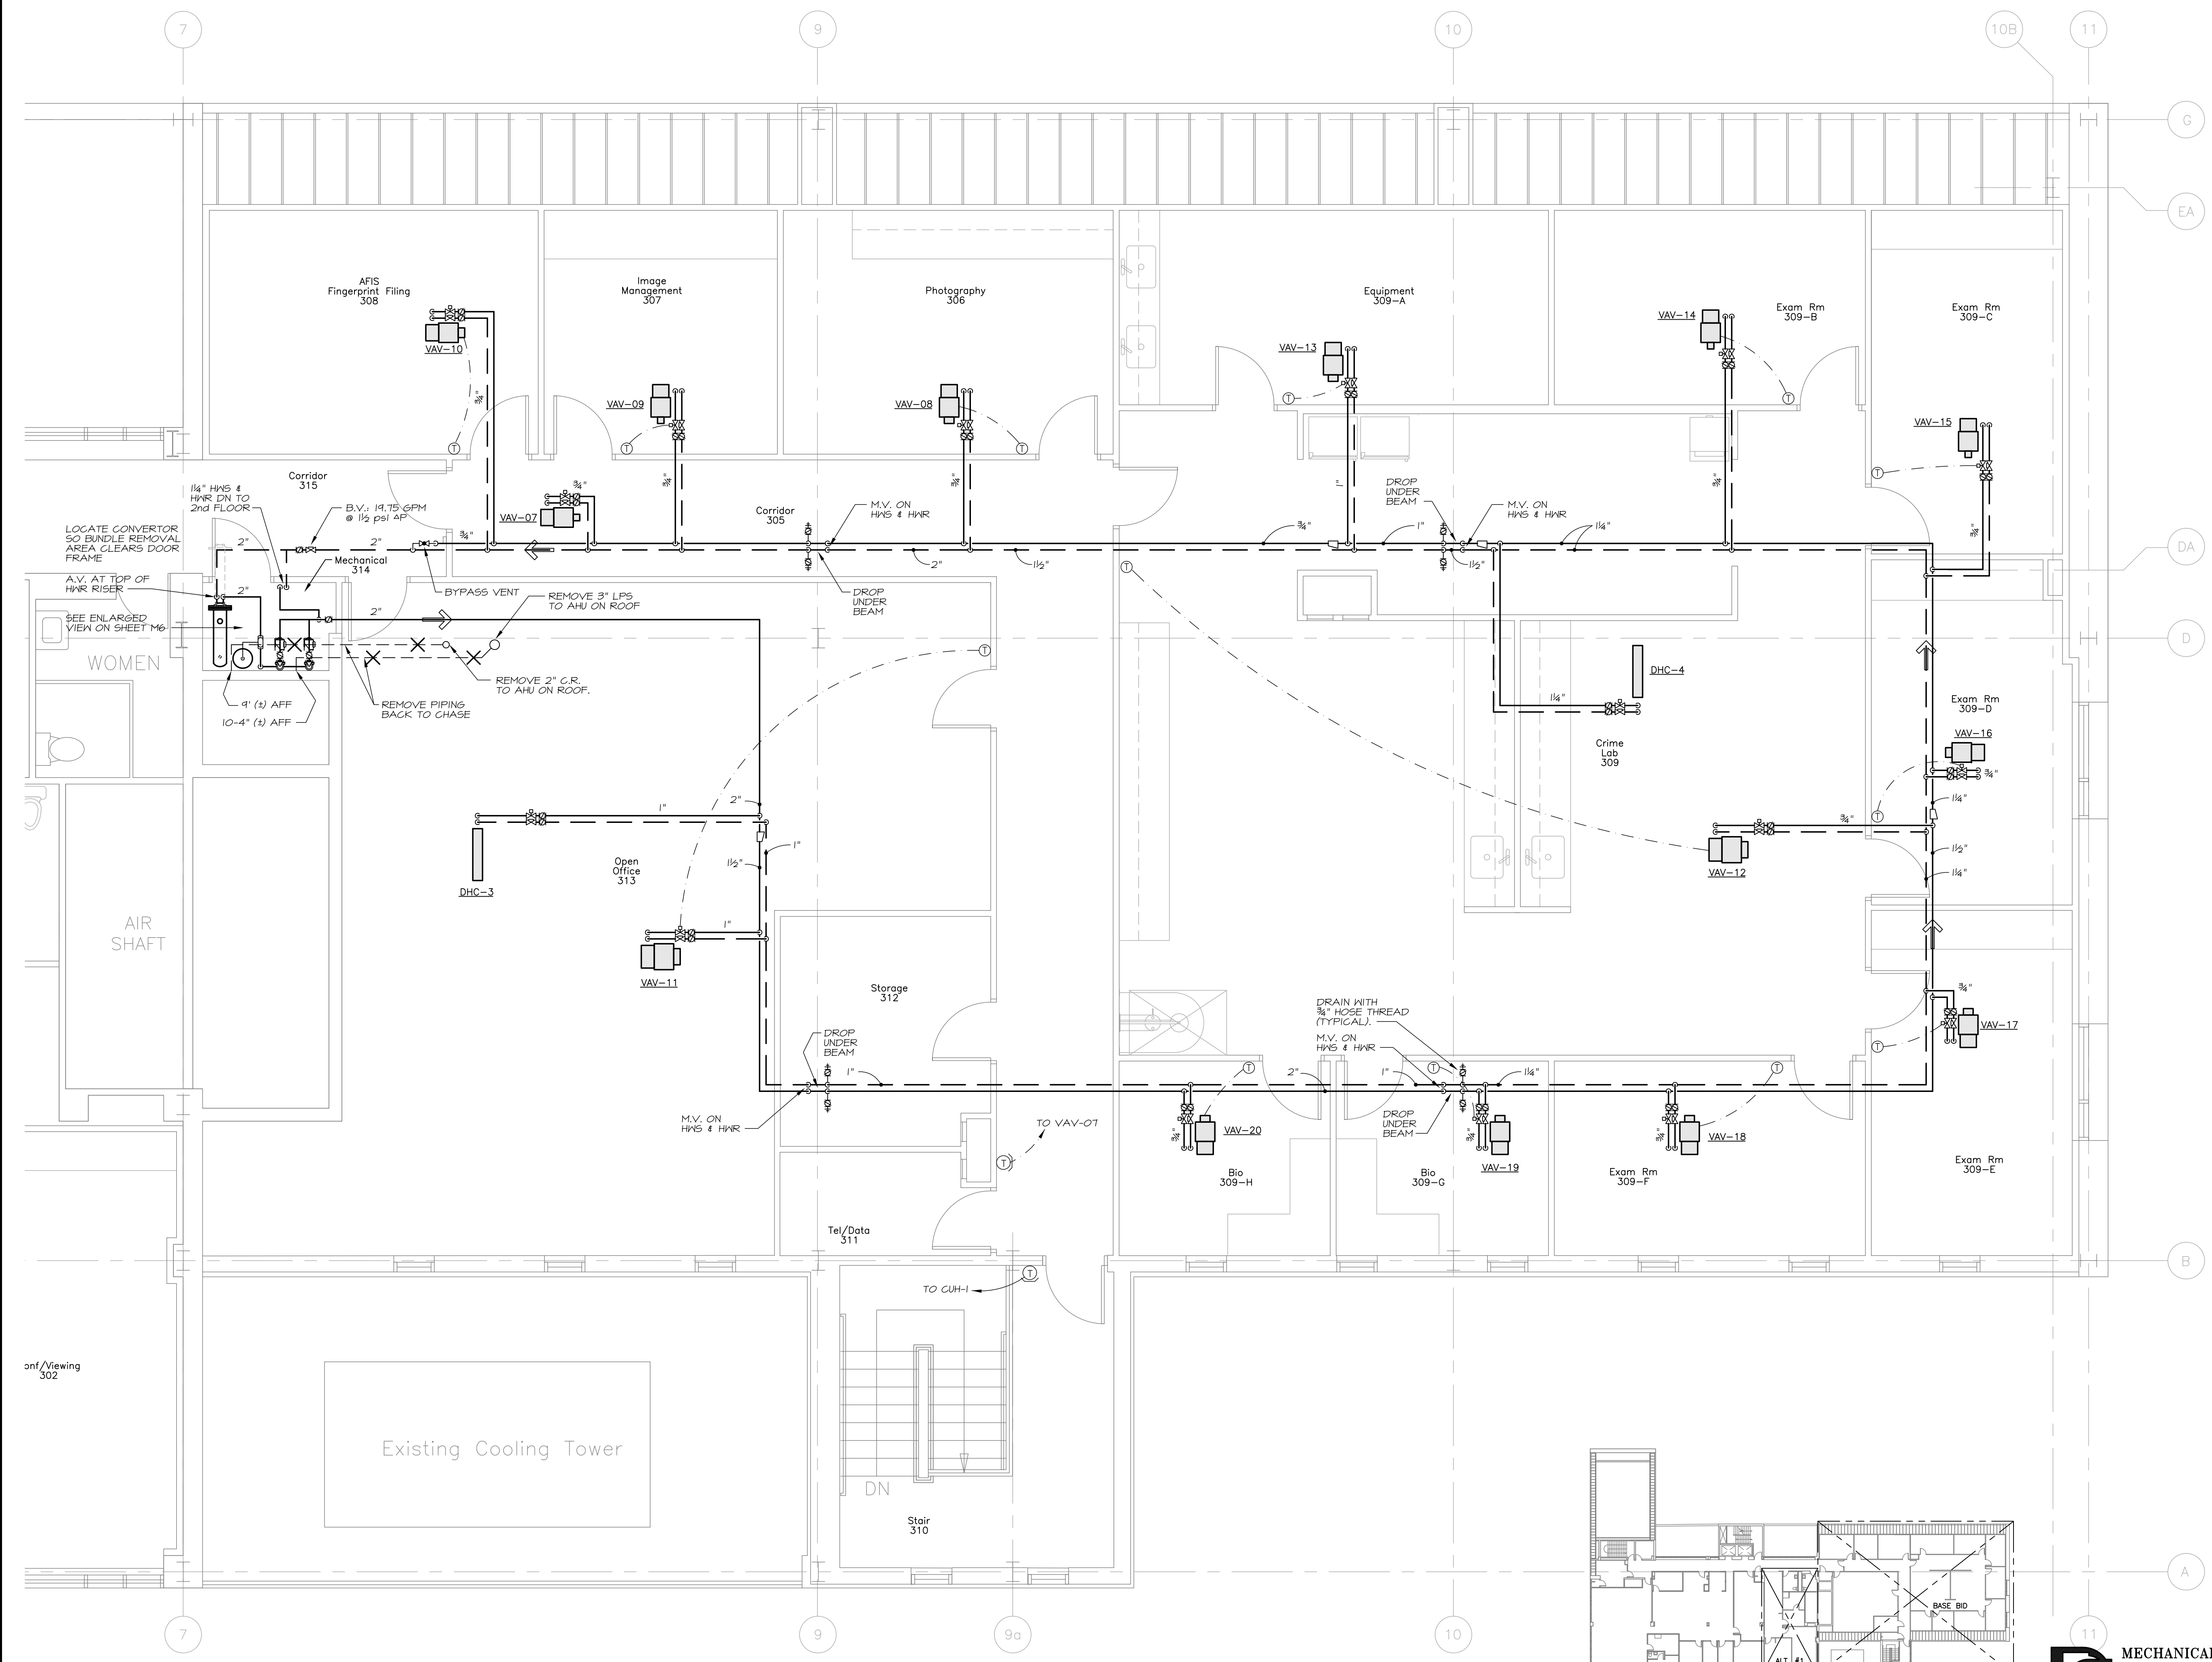

Existing Cooling Tower

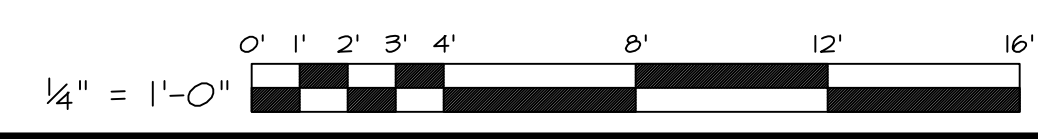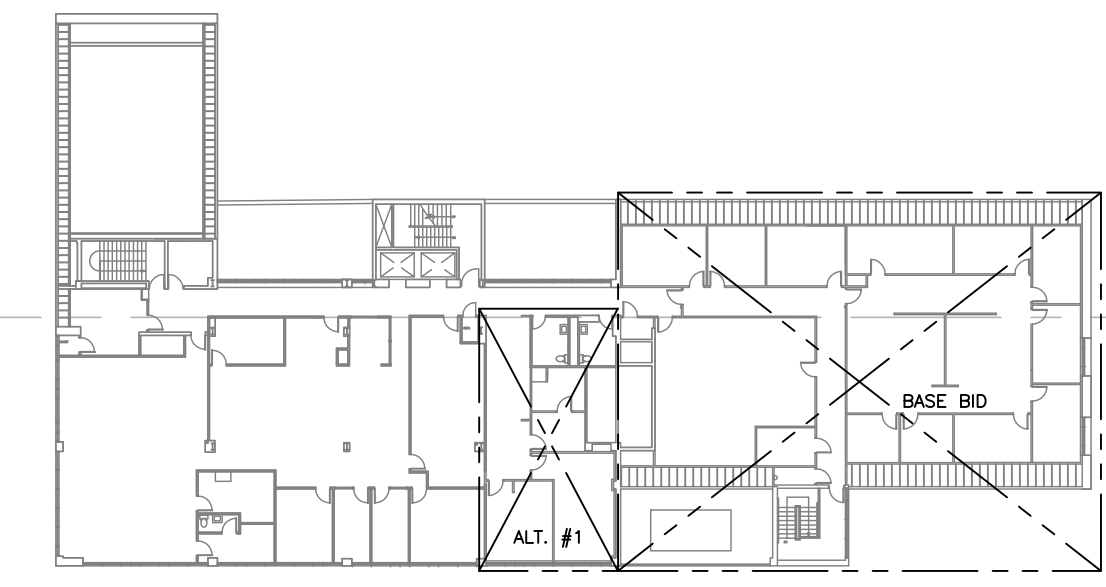

**MECHANICAL SYSTEMS ENGINEERS**  
 ROYAL RIVER CENTER, UNIT #10  
 10 FOREST FALLS DRIVE  
 YARMOUTH, MAINE 04096  
 VOICE: (207) 846-1441  
 FAX: (207) 846-1443  
 mech Syst@maine.rr.com  
 © COPYRIGHT 2008

June 16, 2008 - 12:19 pm  
 \\Msefpa1\Projects\0811\Portland Crime Lab\Drawings\0811 M4-M5.dwg