


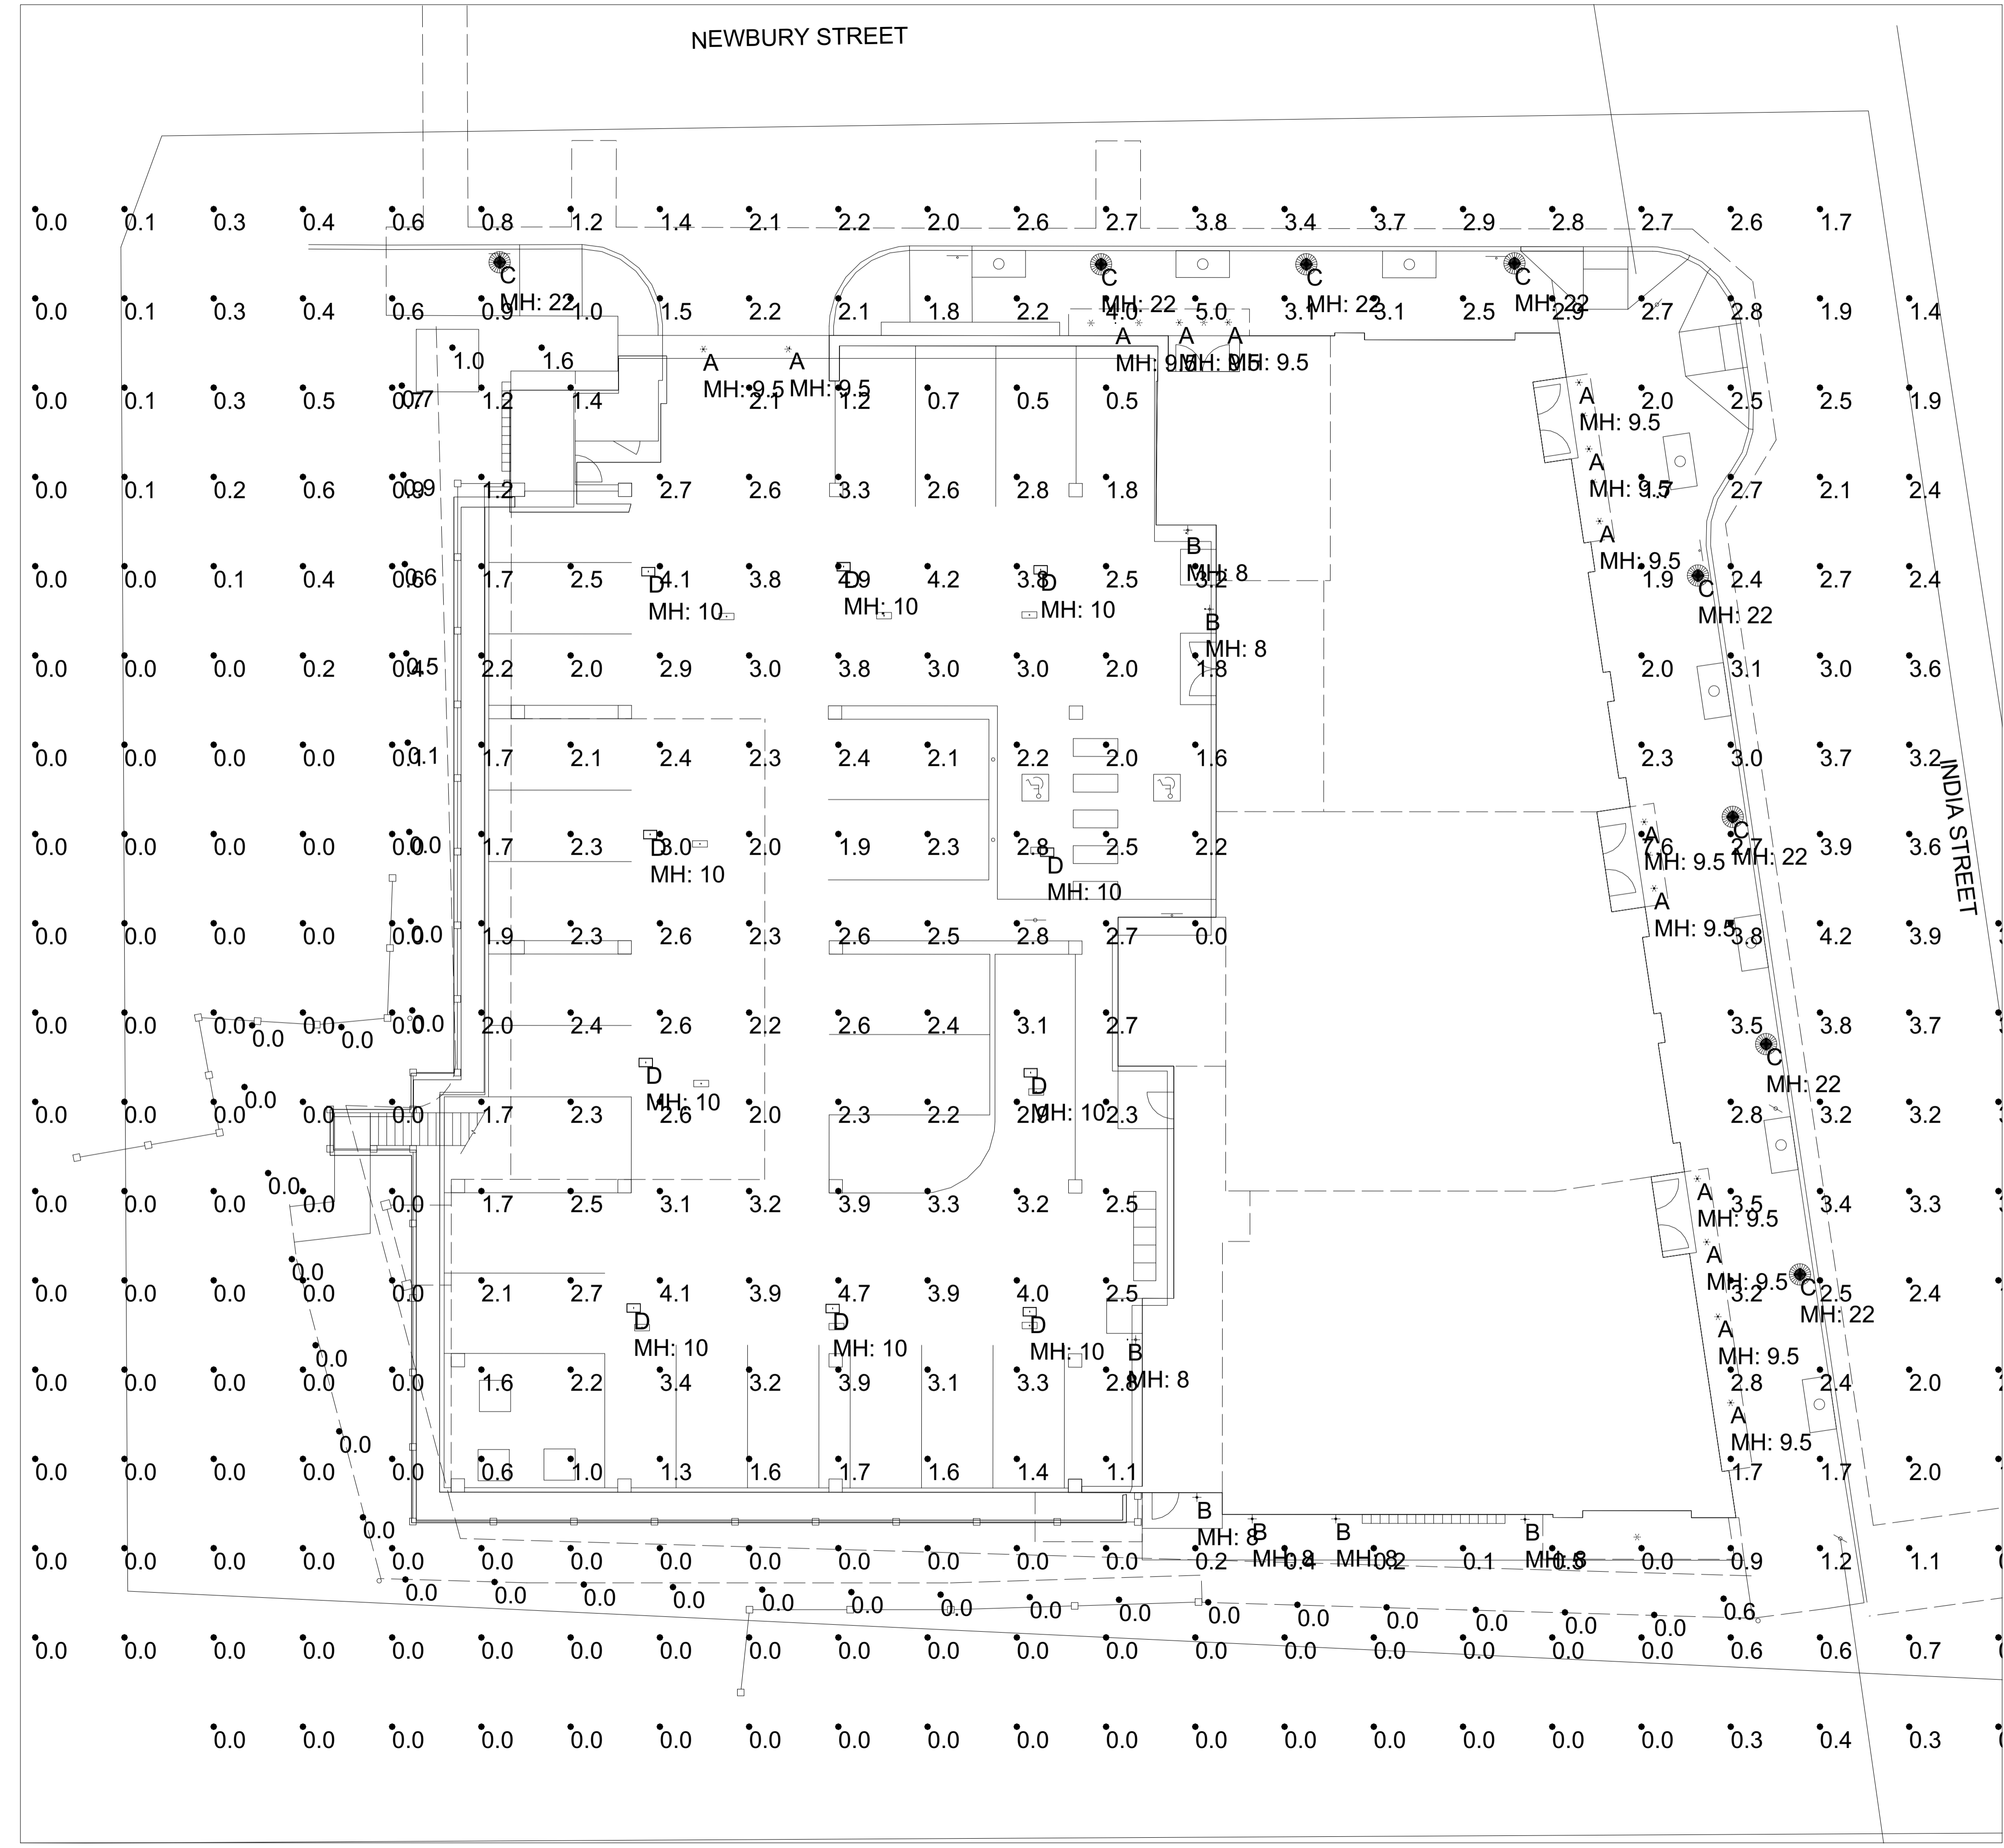

NOTES:
 1) EXACT MOUNTING DETAILS TO BE DETERMINED BY BUILDINGS AND OTHERS.
 2) CALCULATIONS MAY SHOW THE EFFECT OF OBJECTS WITHIN THE CALCULATED SPACE ON A FLAT SITE.
 3) READINGS SHOWN ARE INITIAL HORIZONTAL UNLESS OTHERWISE INDICATED.
 4) THIS CALCULATION IS BASED ON LIMITED INFORMATION SUPPLIED BY OTHERS TO SWANEY LIGHTING ASSOCIATES AND STANDARD ASSUMPTIONS OF THE SPACE AND/OR SITE.
 5) CONFORMANCE TO CODES AND OTHER LOCAL REQUIREMENTS AS DETERMINED BY THE AHJ ARE THE RESPONSIBILITY OF THE OWNER AND THE OWNER'S REPRESENTATIVE.
 6) THIS LAYOUT DRAWING MUST BE COORDINATED WITH THE SITE LOCATION FOR CORRECT FIXTURE ORIENTATION.
 7) CHECK GRAPHIC SCALE. DOCUMENTS PRINTED OR PLOTTED FROM ELECTRONIC FILES MAY OCCUR AT OTHER THAN THE DESIRED OR ASSUMED GRAPHIC SCALES. IT IS THE RESPONSIBILITY OF THE RECIPIENT TO VERIFY THAT THE PRINTED OR PLOTTED-TO-SCALE DRAWING IS PRINTED TO SCALE.



Luminaire Schedule (note fixture catalogue numbers are not complete)

Type	Symbol	Qty	Lum.	Lumens	Watts	Description
D	□	10	3111	0.900	27	EDR-24NB-27-4K-T5R
A	○	14	176	0.900	2.56	DM-LED-e72-MFL-12-C
B	○	7	176	1.000	2.56	YM-LED-e72-MFL-12-C
C	●	8	6220	0.900	109	ESL 110 4K AS X 7 DS

Calculation Summary

Label	Avg	Max	Min	Avg/Min	Max/Min
full site	1.52	7.6	0.0	N.A.	N.A.
garage	2.68	5.0	0.5	5.36	10.00
property line	0.18	1.6	0.0	N.A.	N.A.

PLAN VIEW

NEWBURY STREET GARAGE
 PORTLAND, ME
 GARAGE LIGHTING LAYOUT

SEBAGO TECH
 SCALE NOT TO SCALE
 Garage 4-11-16.rvt



NOTICE: THIS DRAWING IS THE EXCLUSIVE PROPERTY OF SWANEY LIGHTING ASSOCIATES, INC. AND IS CONFIDENTIAL. THIS DRAWING IS TO BE USED FOR NO PURPOSE OTHER THAN AS DETAILED HEREIN. NO REPRODUCTION OR TRANSMISSION OF THIS DRAWING IS TO BE MADE WITHOUT THE WRITTEN CONSENT OF SWANEY LIGHTING ASSOCIATES, INC. SWANEY LIGHTING ASSOCIATES, INC. IS NOT RESPONSIBLE FOR ANY VARIATION IN PERFORMANCE FROM THAT SHOWN IN THIS DRAWING. ANY VARIATION IN PERFORMANCE FROM THAT SHOWN IN THIS DRAWING IS NOT THE RESPONSIBILITY OF SWANEY LIGHTING ASSOCIATES, INC. FOR ANY OTHER PURPOSE IS NOT AUTHORIZED BY SWANEY LIGHTING ASSOCIATES, INC.

GENERATED FOR: SEBAGO TECH
 DATE: 4/11/2016
 PROJECT: NEWBURY STREET GARAGE
 SHEET: 4-11-16.rvt
 SCALE: NOT TO SCALE
 PAGE 1 OF 1
 GENERATED BY SWANEY LIGHTING, SCARBOROUGH, ME - 207-883-7100 - swaneylighting.com