


K1 ELEVATOR MACHINE ROOM DETAIL  
1/4" = 1'-0"

K6 ELEVATOR PIT DETAIL  
1/4" = 1'-0"

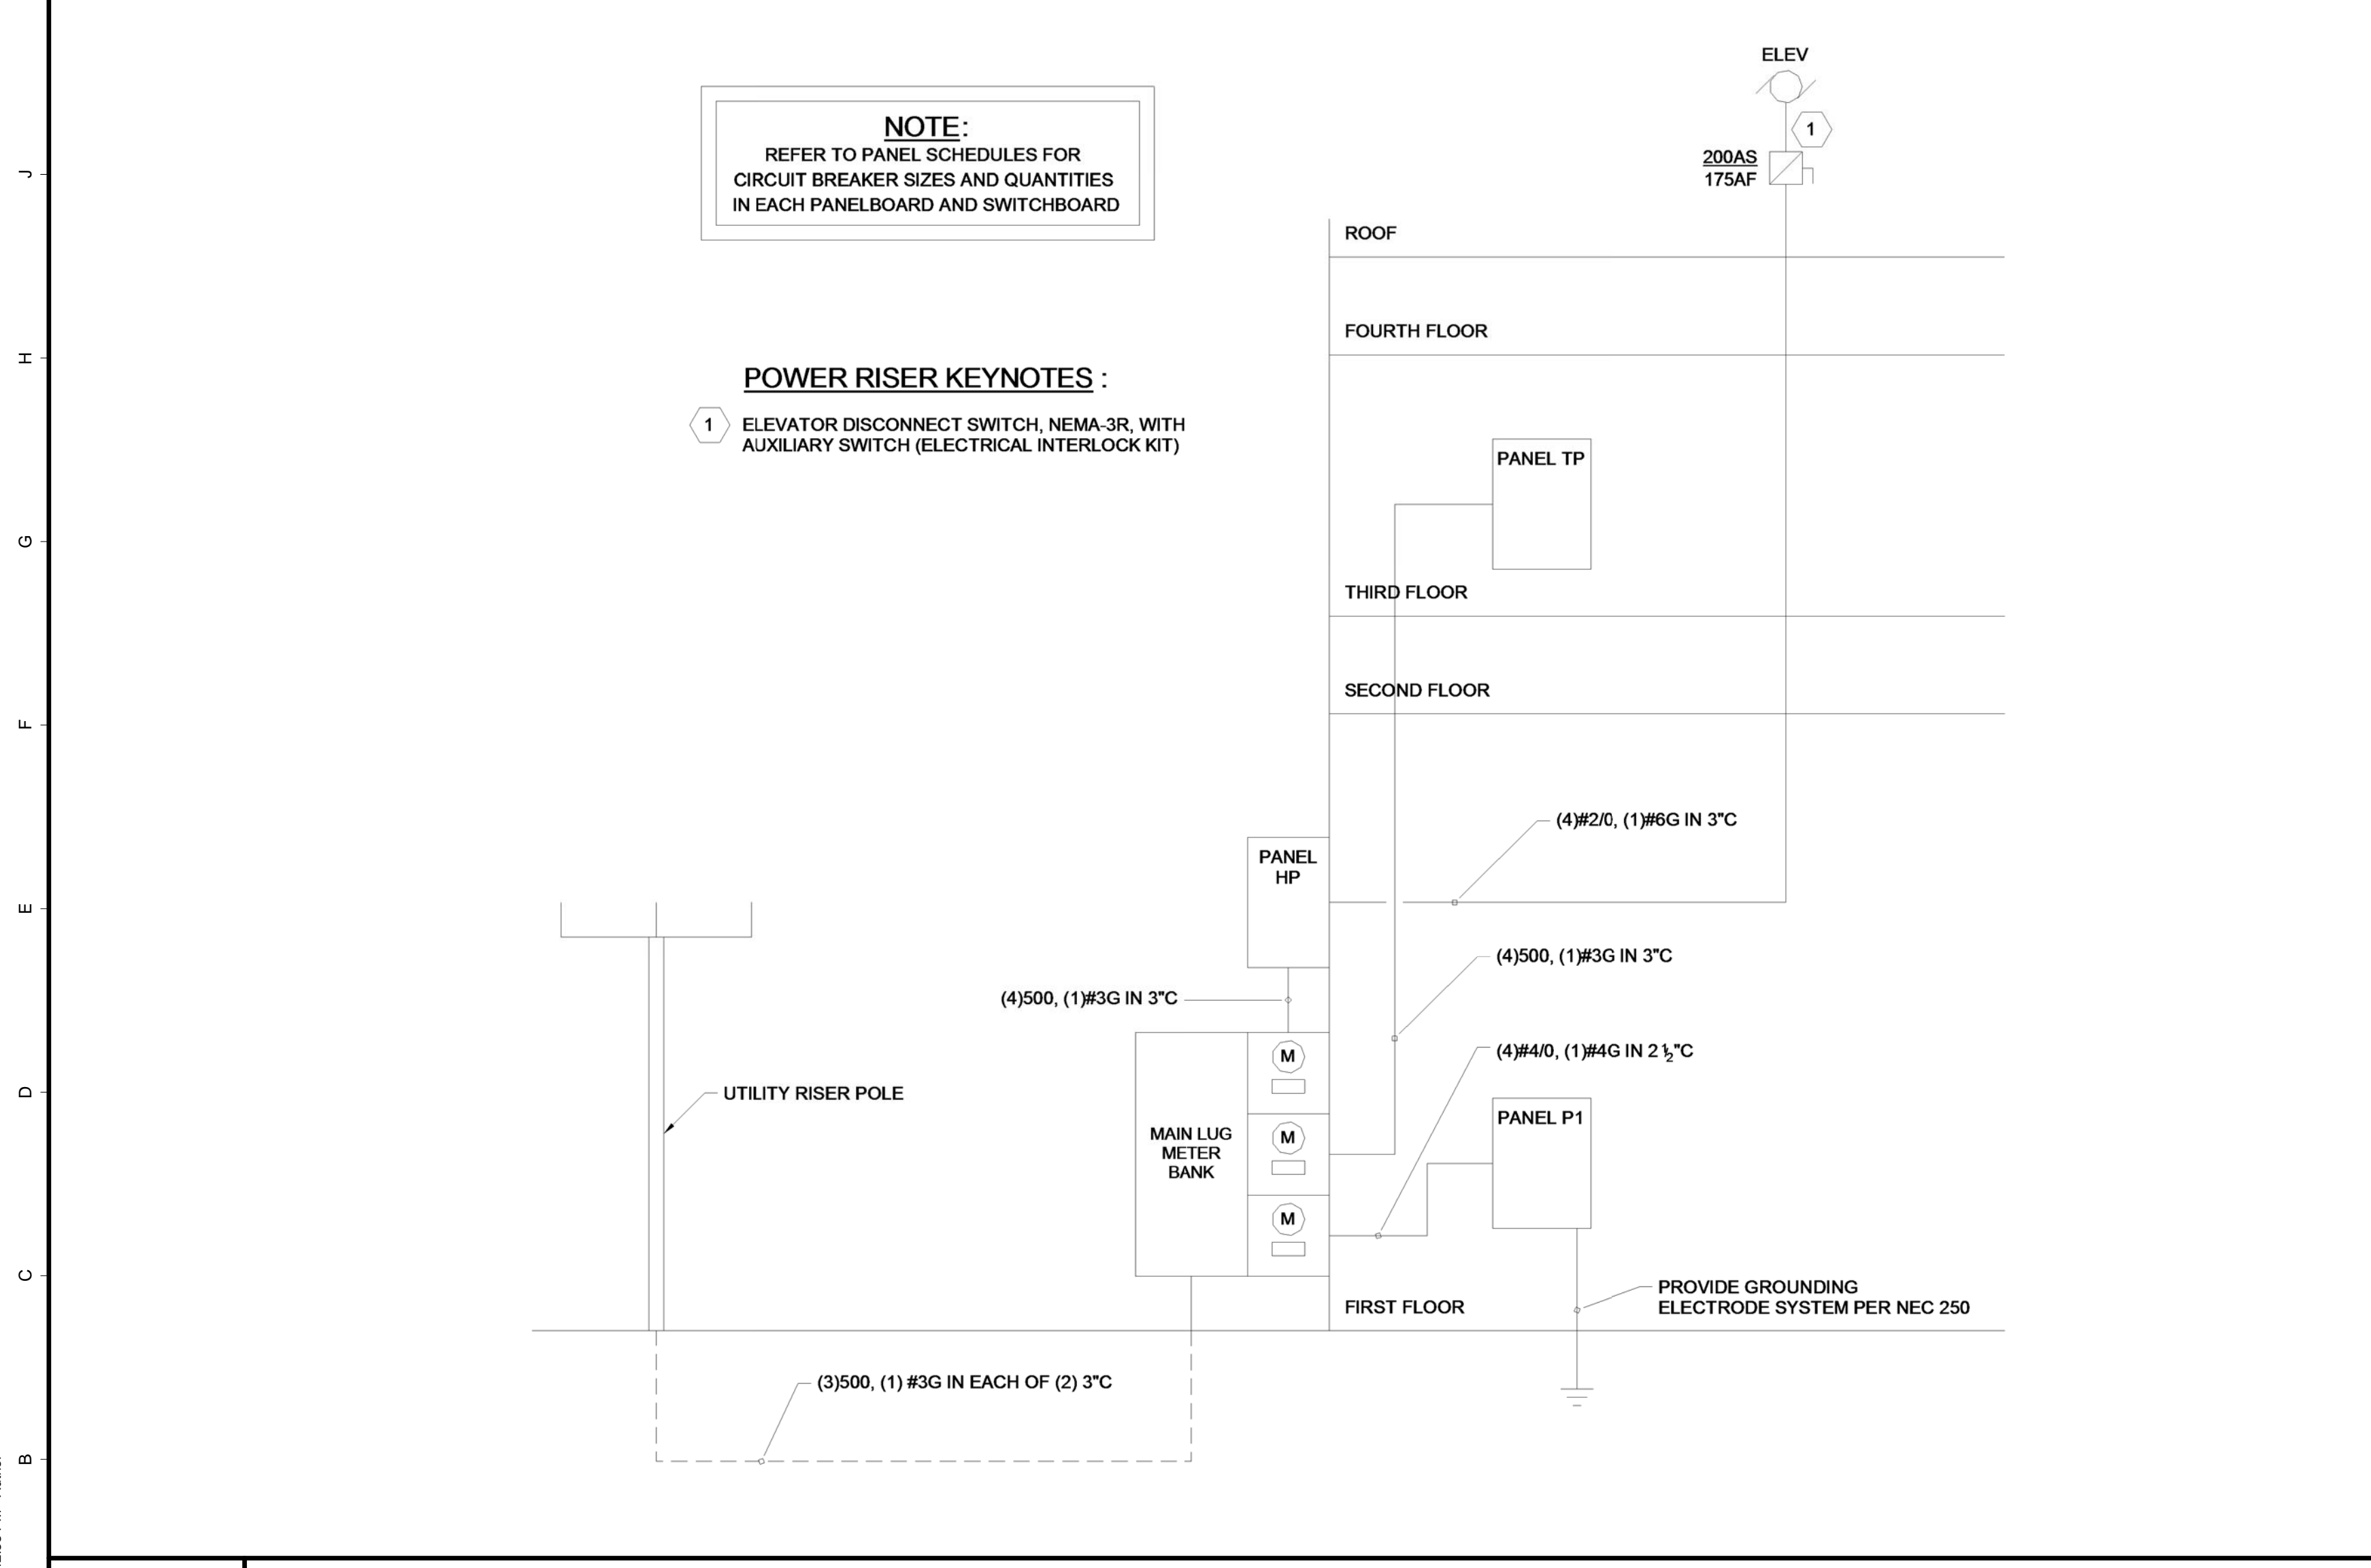

A1 POWER RISER DIAGRAM

29 BLACK POINT ROAD  
SCARBOROUGH, MAINE 04074  
207-883-4307  
WWW.GAWRONTURGEON.COM

**GAWRON  
TURGEON  
ARCHITECTS, P.C.**

**cPort Credit Union**  
50 India Street  
Portland, Maine

**REVISIONS**

#	DATE	DESCRIPTION
1	09.14.17	PERMIT SET NOT FOR CONSTRUCTION

DATE:	09.14.17
PROJECT #	010416
DRAWN BY:	Author
CHECKED BY:	Checker
DRAWING SCALE	AS NOTED

**SHEET TITLE**  
ELECTRICAL  
DETAILS

**E500**

**Allied Engineering**  
Structural Mechanical Electrical Commissioning  
160 Veranda Street  
Portland, Maine 04103  
T: 207-221-2200  
F: 207-221-2266  
Web: www.allied-eng.com

AEI PROJECT NO.: 16025 CAD FILE: 16025\_E.rvt

© COPYRIGHT 1985-2017  
REPRODUCTION OR RELEASE OF  
THIS DOCUMENT WITHOUT  
WRITTEN PERMISSION OF  
GAWRON ARCHITECTS IS PROHIBITED

9/14/2017 1:42:38 PM Author