


LIGHTING CONTROL NOTES SCHEDULE		
TAG/ NOTE	DESCRIPTION OF LIGHTING CONTROL DEVICES AND OPERATION	DETAIL NUMBER
1	WALL SWITCH - MANUAL ON/MANUAL OFF	NO DETAIL
2	WALL SWITCH WITH OCCUPANCY SENSOR - MANUAL ON AND OFF/AUTO OFF	NO DETAIL
3	WALL SWITCH - MANUAL ON AND OFF; AUTO OFF VIA OCCUPANCY SENSORS; DIMMING VIA DAYLIGHT HARVESTING SENSOR FOR FIXTURES INDICATED	
4	LIGHTING CONTROLLED BY LCP - REFER TO LIGHTING CONTROL PANEL SCHEDULE	NO DETAIL
5	AUTO ON/AUTO OFF VIA OCCUPANCY SENSOR(S)	
6	WALL SWITCH(ES) - MANUAL ON AND OFF; AUTO OFF VIA OCCUPANCY SENSOR(S)	
7	WALL SWITCH WITH DIMMER AND OCCUPANCY SENSOR - MANUAL ON AND OFF/MANUAL DIMMING/AUTO OFF	NO DETAIL
8	WALLSTATION(S) - MANUAL ON AND OFF - WHERE NOTED ON PLANS; WALLSTATION(S) WITH DIMMER(S) - MANUAL ON AND OFF/MANUAL DIMMING; AUTO OFF VIA OCCUPANCY SENSORS	
9	NOT USED	
10	WALLSTATION(S) - MANUAL ON AND OFF - WHERE NOTED ON PLANS; WALLSTATION(S) WITH DIMMER(S) - MANUAL ON AND OFF/MANUAL DIMMING; AUTO OFF VIA OCCUPANCY SENSORS; DIMMING VIA DAYLIGHT HARVESTING SENSOR FOR FIXTURES INDICATED	
11	PHOTOCELL CONTROLLED	
12	WALL SWITCH- MANUAL ON AND OFF; WALL SWITCH WITH MANUAL DIMMER-RAISE/LOWER, AND ON/OFF; AUTO OFF VIA OCCUPANCY SENSORS	
13	AUTO ON/OFF VIA OCCUPANCY SENSORS; DIMMING VIA DAYLIGHT HARVESTING SENSOR FOR FIXTURES INDICATED	
14	LIGHTING SHALL BE CONTROLLED BY DIMMING RACK	

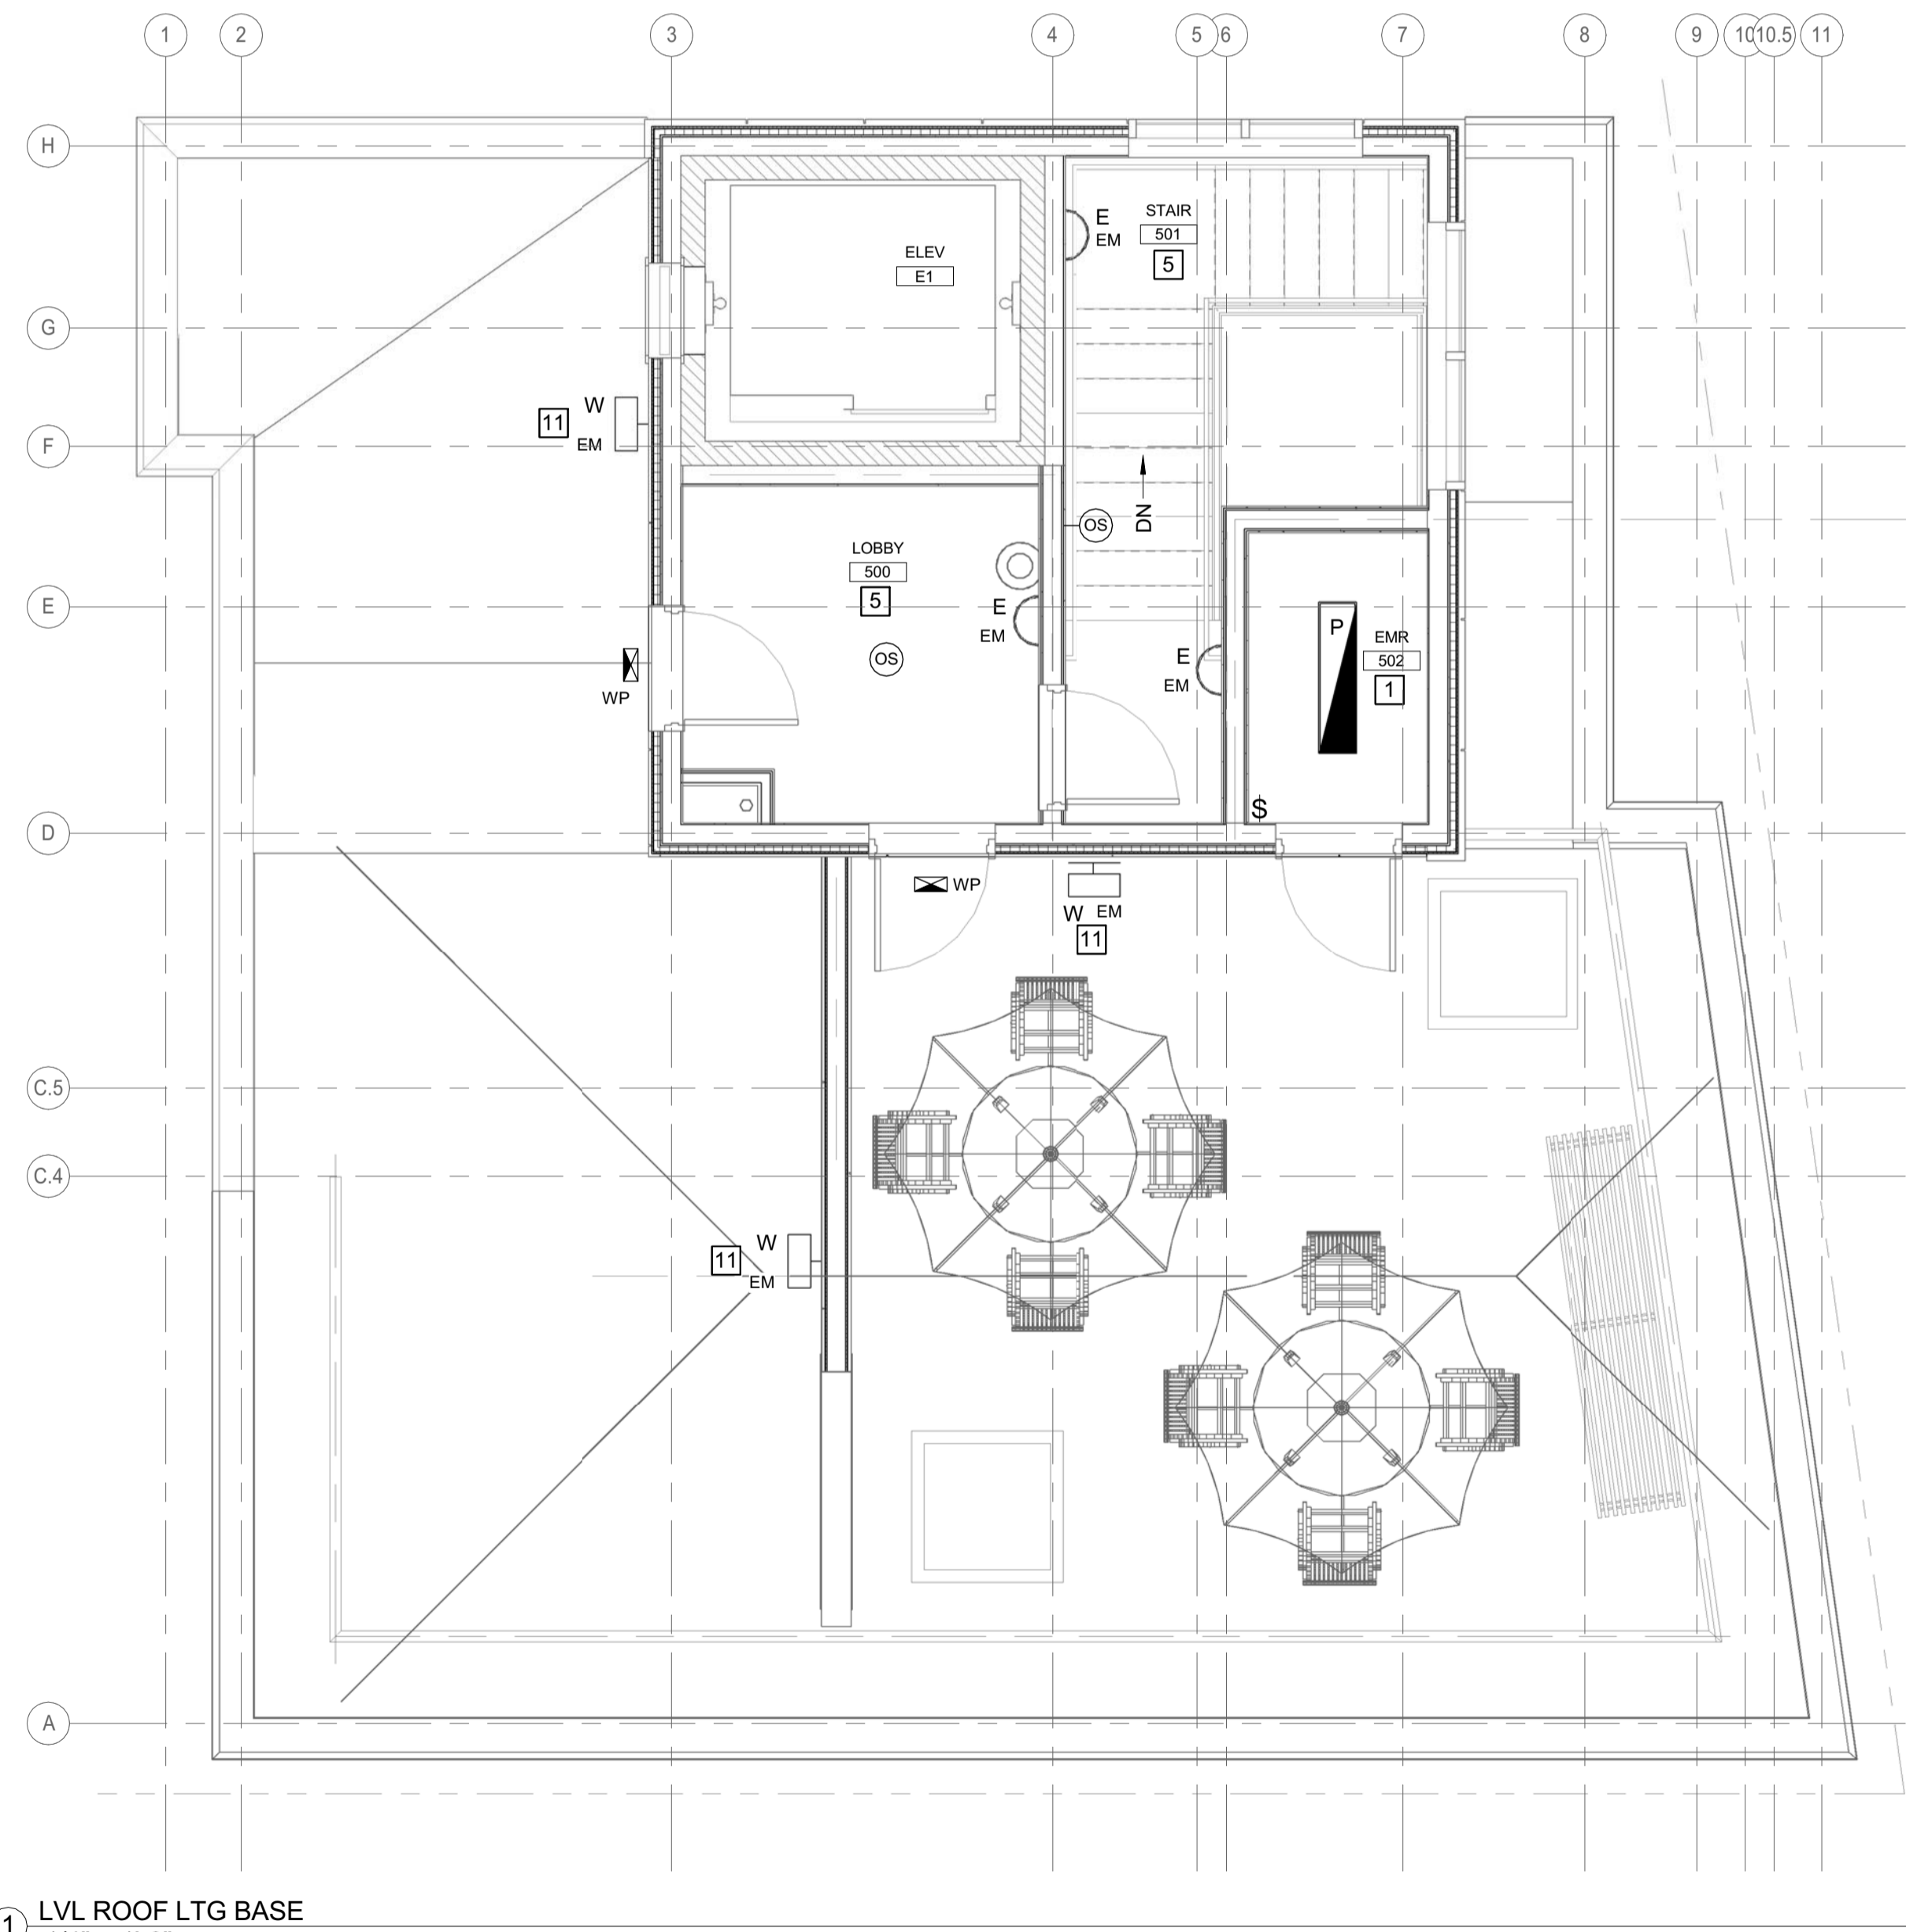

1 LVL ROOF LTG BASE
1/4" = 1'-0"



 
CITY OF PORTLAND
APPROVED SITE PLAN
Subject to Conditions of Approval
and Standard Conditions

DATE OF APPROVAL: October 12, 2017
PLANNER: Caitlin Cameron
PROJECT NO.: 2017-130

ING PLAN


Allied Engineering
Structural Mechanical Electrical Commissioning
160 Veranda Street
Portland, Maine 04103
Tel: 207.221.2268
Fax: 207.221.2266
Web: www.allied-eng.com

AEI PROJECT NO.: 16025 CAD FILE: 16025_E.rvt



29 BLACK POINT ROAD
SCARBOROUGH, MAINE 04074
207.883-4307
WWW.GAWRONTURGEON.COM

 **GAWRON
TURGEON**
ARCHITECTS, P.C.



cPort Credit Union
50 India Street
Portland, Maine

REVISIONS		
#	DATE	DESCRIPTION

DATE:	
PROJECT #	010416
DRAWN BY:	GMC
CHECKED BY:	SRM
DRAWING SCALE	AS NOTED

SHEET TITLE
ELECTRICAL ROOF
LIGHTING PLAN

EL103

© COPYRIGHT 1985-2017
REPRODUCTION OR RESALE OF
THIS DOCUMENT WITHOUT
WRITTEN PERMISSION OF
GAWRON ARCHITECTS IS PROHIBITED

25 JULY 2017 ~ NOT FOR CONSTRUCTION