

CASHWRAP GENERAL NOTES

- CASHWRAPS ARE TO BE WIRED ON SITE.
- ELECTRICAL CONTRACTOR SHALL PROVIDE POWER, WIRING AND FINAL CONNECTIONS. CONNECT, TEST AND REPAIR ALL DEVICES AS REQUIRED FOR A COMPLETE CODE-COMPLIANT SYSTEM.
- REFER TO CONDUIT RISER DIAGRAM FOR EMPTY CONDUIT SIZES.
- FINAL CONNECTIONS, HUBS AND WIRING FOR POS AND TELEPHONE SYSTEMS ARE PROVIDED AND INSTALLED BY SPENCER ENGINEERING AND LUCENT TECHNOLOGY RESPECTIVELY.
- FINAL CONNECTIONS AND WIRING FOR MUSIC SYSTEM ARE PROVIDED AND INSTALLED BY PLAY NETWORK.

CASHWRAP CODED NOTES

- (200) ISOLATED GROUND QUADRAPLEX RECEPTACLE FOR POS EQUIPMENT POWER.
- (201) CONVENIENCE DUPLEX RECEPTACLE FOR GENERAL USE POWER.
- (202) DELIVERY DOOR BUZZER AND BUZZER SYSTEM TRANSFORMER. INSTALL LOW VOLTAGE WIRING TO BUZZER IN MGR'S OFFICE AND PUSHBUTTON AT DELIVERY DOOR. REFER TO BUZZER SYSTEM DETAIL FOR ADDITIONAL REQUIREMENTS.
- (203) FLOOR MOUNTED JUNCTION BOXES FOR CONDUIT STUB-UPS. COORDINATE EXACT LOCATION WITH G.C. PRIOR TO ROUGH-IN. SEE ARCHITECTURAL DETAILS AND FLOOR PLAN FOR ELECTRICAL STUB-UP OPENING IN CASHWRAP.
- (204) 3/4" CONDUIT WITH ONE (1) PULLWIRE TO ACCESSIBLE CEILING FOR DOOR BUZZER WIRING.
- (205) 1-1/2" CONDUIT WITH TWO (2) PULLWIRES TO NETWORK RACK.
- (206) SINGLE GANG BOX WITH WHITE COVERPLATE FOR TELEPHONE/DATA CONNECTION. INSTALL CONDUIT WITH (1) PULLWIRE TO POS SWIP CABINET. REFER TO CONDUIT RISER DIAGRAM. (2) DATA (POS & CREDIT TERMINAL). (2) VOICE (PHONE & CREDIT TERMINAL BACKUP). ALL LOW VOLTAGE WIRING SHALL BE INSTALLED BY OTHERS.
- (207) CONTRACTOR TO CONNECT VENDOR SUPPLIED LED TO PRE-INSTALLED SWITCH AT CASHWRAP. CONNECT THE PLUG/POWER CABLE TO THE DRIVER AND CONNECT DRIVER TO LED STICK.

NEW STORE



GAP INC.
CORPORATE ARCHITECTURE
1 HARRISON STREET
SAN FRANCISCO, CA 94105

STORE NO.: 7641

STORE NAME:
PORTLAND

STORE LOCATION:
152 MIDDLE STREET
PORTLAND, ME 04101

PROJ. I.D.: 0000053405

PROTOTYPE DATE: 09/4/15
PROTOTYPE VERSION 4.1




DICKERSON ENGINEERING, INC.
Professional Electrical Engineers
8101 NORTH MILWAUKEE AVENUE
NILES, ILLINOIS 60714
TEL (847) 966-0290

PROFESSIONAL STAMP:


1-TERMINAL CASHWRAP ELEVATION LAYOUT

NOT TO SCALE
202

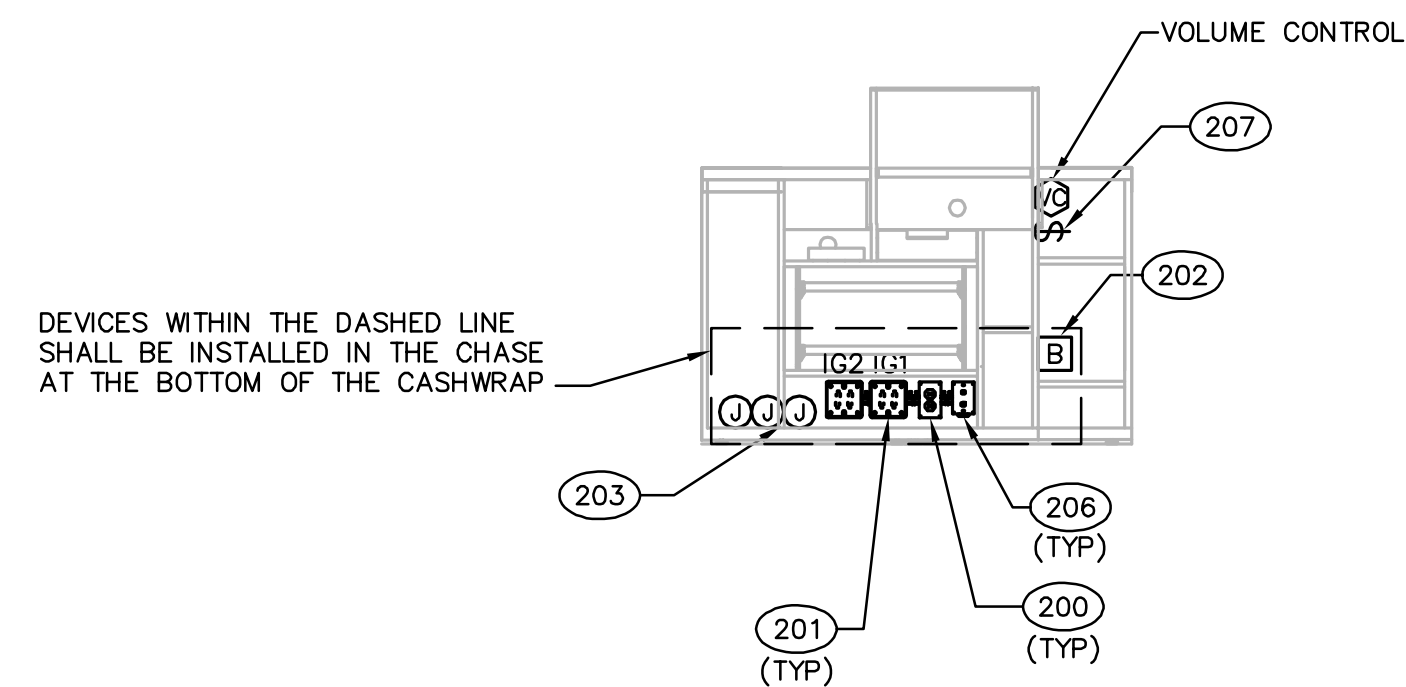

1-TERMINAL CASHWRAP PLAN LAYOUT

NOT TO SCALE
201

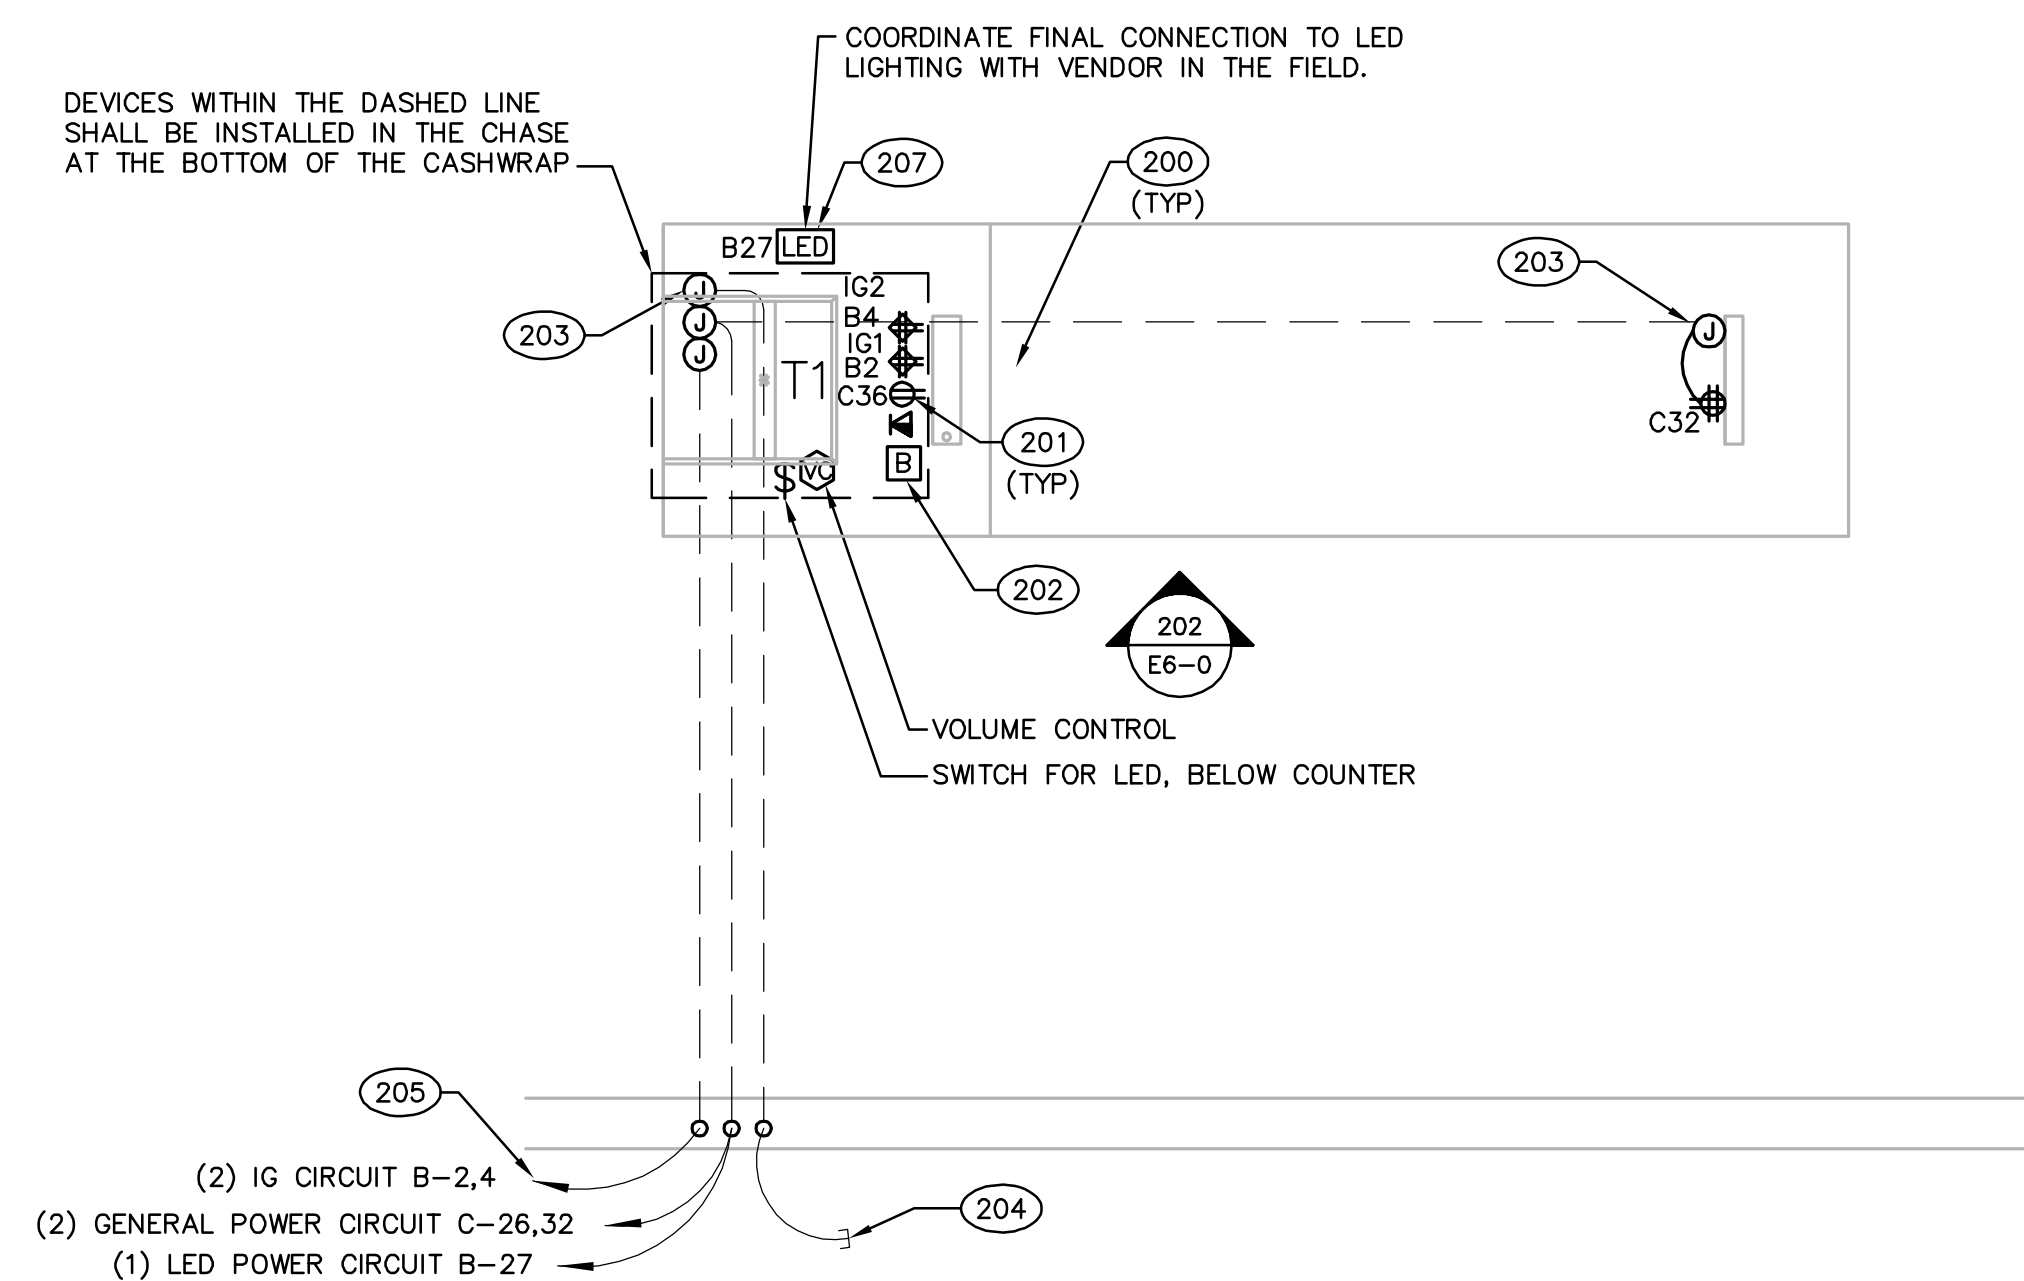

THIS IS A NON-PROTOTYPICAL CUSTOM CASHWRAP. CONTRACTOR SHALL FULLY COORDINATE EXACT REQUIREMENTS IN THE FIELD WITH CASHWRAP/MILLWORK VENDOR. PROVIDE ALL NECESSARY APPURTENANCES REQUIRED FOR A COMPLETE AND CODE COMPLIANT INSTALLATION.

ARCHITECT INFO:



ISSUE TYPE:
100% CD CHECKSET 5/20/16
PERMIT / BID
LL APPROVAL

DRAWN BY: PR
A&E JOB NO.: 16-5433

SHEET TITLE:
CASHWRAP DETAILS

SHEET NUMBER:

E6-0