

CASHWRAP GENERAL NOTES

1. CASHWRAPS ARE TO BE WIRED ON SITE.
2. ELECTRICAL CONTRACTOR SHALL PROVIDE POWER, WIRING AND FINAL CONNECTIONS. CONNECT, TEST AND REPAIR ALL DEVICES AS REQUIRED FOR A COMPLETE CODE-COMPLIANT SYSTEM.
3. REFER TO CONDUIT RISER DIAGRAM FOR EMPTY CONDUIT SIZES.
4. FINAL CONNECTIONS, HUBS AND WIRING FOR POS AND TELEPHONE SYSTEMS ARE PROVIDED AND INSTALLED BY SPENCER ENGINEERING AND LUCENT TECHNOLOGY RESPECTIVELY.
5. FINAL CONNECTIONS AND WIRING FOR MUSIC SYSTEM ARE PROVIDED AND INSTALLED BY PLAY NETWORK.

CASHWRAP CODED NOTES

- (200) ISOLATED GROUND QUADRAPLEX RECEPTACLE FOR POS EQUIPMENT POWER.
- (201) CONVENIENCE DUPLEX RECEPTACLE FOR GENERAL USE POWER.
- (202) DELIVERY DOOR BUZZER AND BUZZER SYSTEM TRANSFORMER. INSTALL LOW VOLTAGE WIRING TO BUZZER IN MGR'S OFFICE AND PUSHBUTTON AT DELIVERY DOOR. REFER TO BUZZER SYSTEM DETAIL FOR ADDITIONAL REQUIREMENTS.
- (203) FLOOR MOUNTED JUNCTION BOXES FOR CONDUIT STUB-UPS. COORDINATE EXACT LOCATION WITH G.C. PRIOR TO ROUGH-IN. SEE ARCHITECTURAL DETAILS AND FLOOR PLAN FOR ELECTRICAL STUB-UP OPENING IN CASHWRAP.
- (204) 3/4" CONDUIT WITH ONE (1) PULLWIRE TO ACCESSIBLE CEILING FOR DOOR BUZZER WIRING.
- (205) 1-1/2" CONDUIT WITH TWO (2) PULLWIRES TO NETWORK RACK.
- (206) SINGLE GANG BOX WITH WHITE COVERPLATE FOR TELEPHONE/DATA CONNECTION. INSTALL CONDUIT WITH (1) PULLWIRE TO POS SWIP CABINET. REFER TO CONDUIT RISER DIAGRAM. (2) DATA (POS & CREDIT TERMINAL). (2) VOICE (PHONE & CREDIT TERMINAL BACKUP). ALL LOW VOLTAGE WIRING SHALL BE INSTALLED BY OTHERS.
- (207) CONTRACTOR TO CONNECT VENDOR SUPPLIED LED TO PRE-INSTALLED SWITCH AT CASHWRAP. CONNECT THE PLUG/POWER CABLE TO THE DRIVER AND CONNECT DRIVER TO LED STICK.

NEW STORE



GAP INC.
CORPORATE ARCHITECTURE
1 HARRISON STREET
SAN FRANCISCO, CA 94105

STORE NO.: 7641

STORE NAME:
PORTLAND

STORE LOCATION:
152 MIDDLE STREET
PORTLAND, ME 04101

PROJ. I.D.: 0000053356

PROTOTYPE DATE: 09/4/15
PROTOTYPE VERSION 4.1



DICKERSON ENGINEERING, INC.
Professional Electrical Engineers
8101 NORTH MILWAUKEE AVENUE
NILES, ILLINOIS 60714
TEL (847) 966-0290

PROFESSIONAL STAMP:



SIGNATURE
DATE: 05/20/2016
EXPIRATION DATE: 12/31/2017

ARCHITECT INFO:
Chipman Design
Architecture Group P.C.
2105 S. River Road, Suite 400
2nd Floor, Portland, ME 04106
T 847.298.4900 F 847.298.4944


ISSUE TYPE:
100% CD CHECKSET 5/20/16
PERMIT / BID
LL APPROVAL

DRAWN BY: PR
A&E JOB NO.: 16-5433

SHEET TITLE:
CASHWRAP DETAILS


SHEET NUMBER:

E6-0

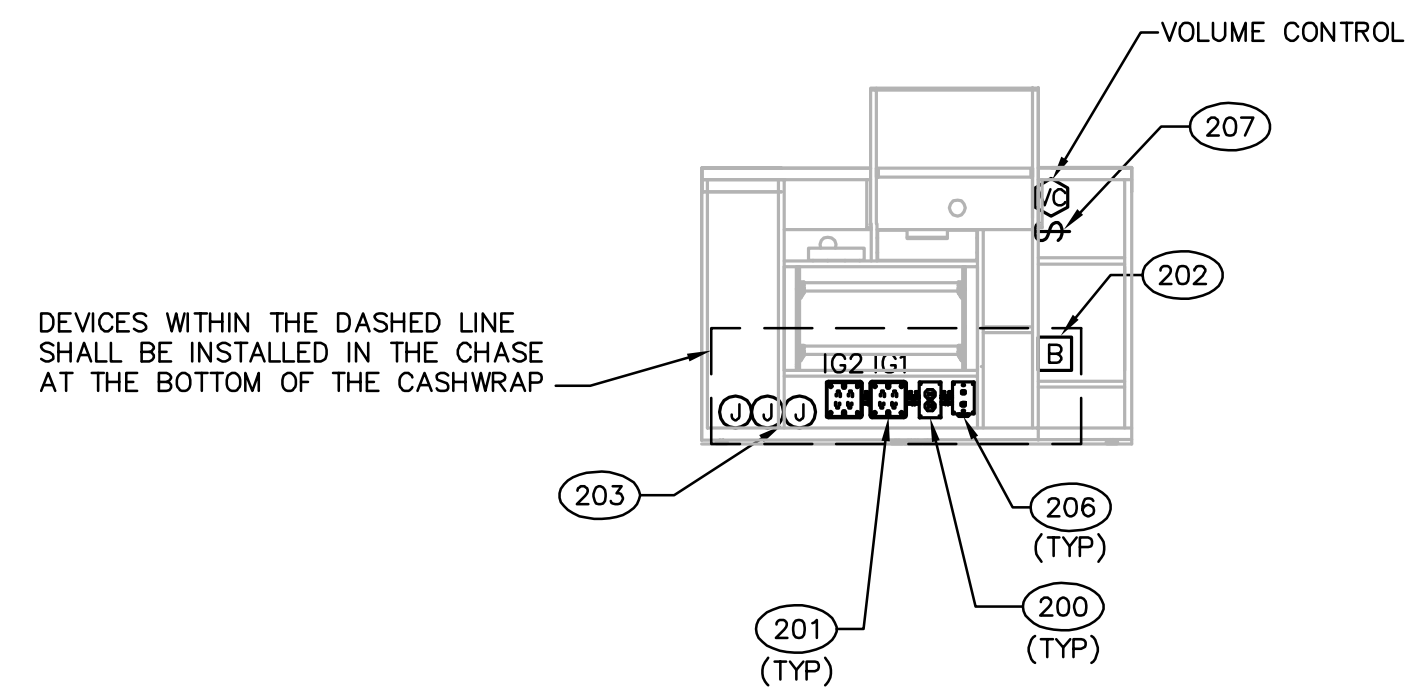

1-TERMINAL CASHWRAP ELEVATION LAYOUT

NOT TO SCALE
202

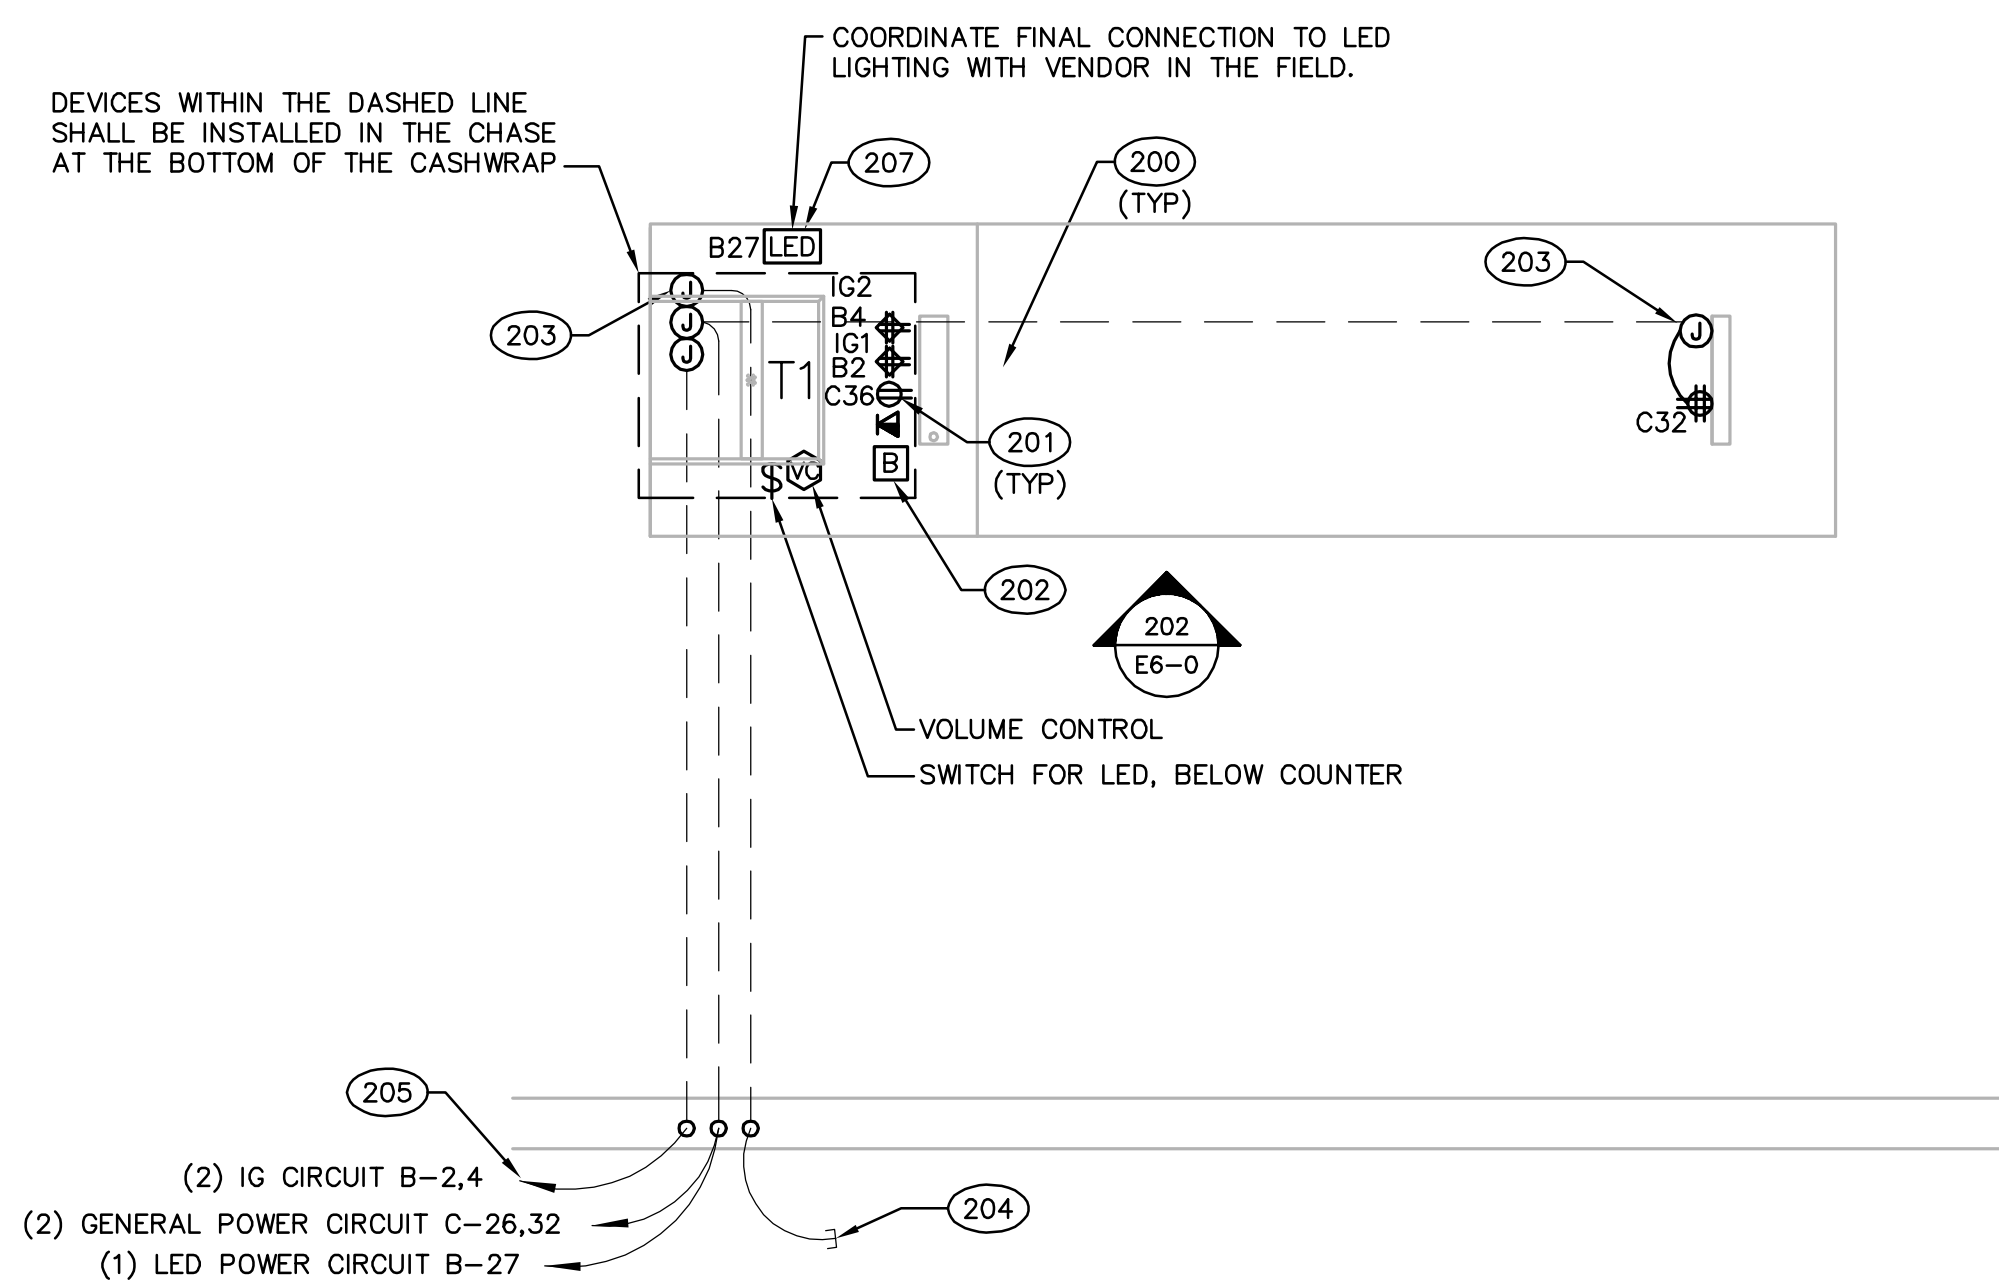

1-TERMINAL CASHWRAP PLAN LAYOUT

NOT TO SCALE
201