

NEW STORE



GAP INC.  
CORPORATE ARCHITECTURE  
1 HARRISON STREET  
SAN FRANCISCO, CA 94105

STORE NO.: 7641

STORE NAME:  
PORTLAND

STORE LOCATION:  
152 MIDDLE STREET  
PORTLAND, ME 04101


PROJ. I.D.: 0000053405

PROTOTYPE DATE: 09/4/15  
PROTOTYPE VERSION 4.1

CONSULTANT INFO:



PROFESSIONAL STAMP:

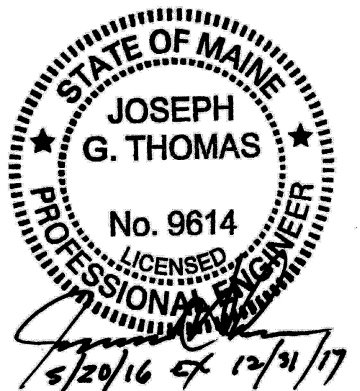

ARCHITECT INFO:



HEREBY CERTIFY THAT THESE PLANS HAVE BEEN PREPARED BY MY OFFICE AND UNDER MY SUPERVISION AND THAT TO THE BEST OF MY KNOWLEDGE, THE SAME COMPLY WITH ALL LAWS, RULES, REGULATIONS AND ORDINANCES OF PORTLAND, ME RELATING TO STRUCTURES AND BUILDINGS.


ISSUE TYPE:  
100% CD CHECKSET 5/20/16  
PERMIT / BID  
LL APPROVAL

DRAWN BY: DG  
A&E JOB NO.: 16-5433

SHEET TITLE:  
PLUMBING DETAILS  
AND RISERS


SHEET NUMBER:

P5-0

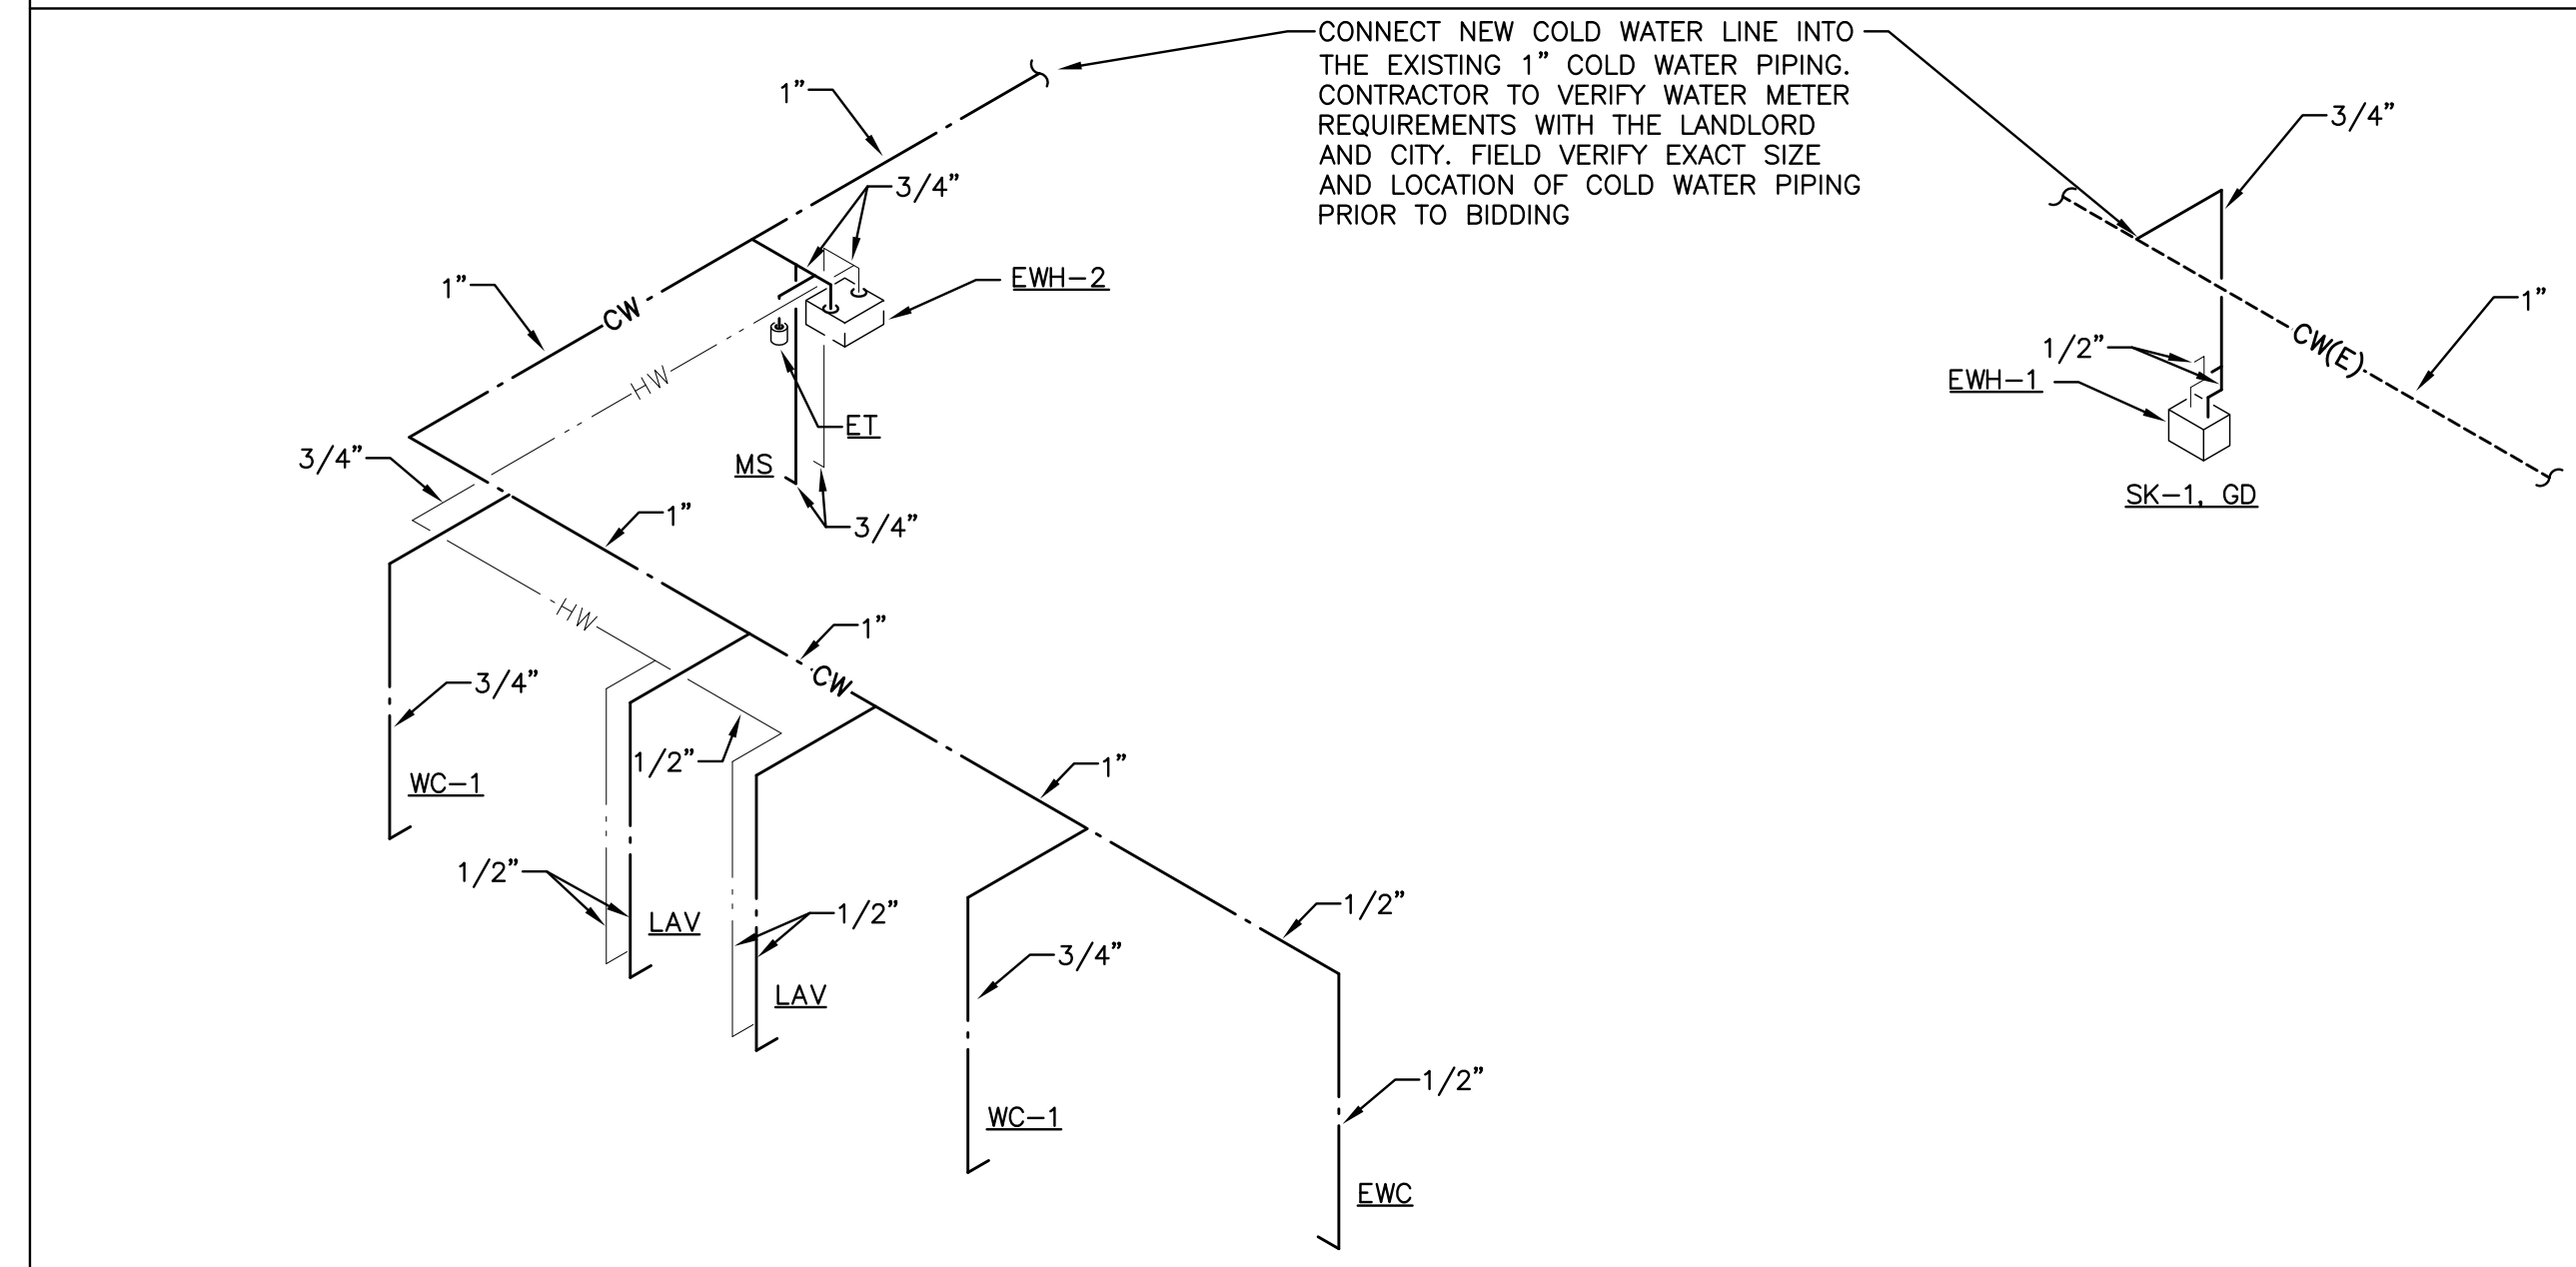


COLD AND HOT WATER RISER DIAGRAM

NOT TO SCALE  
401

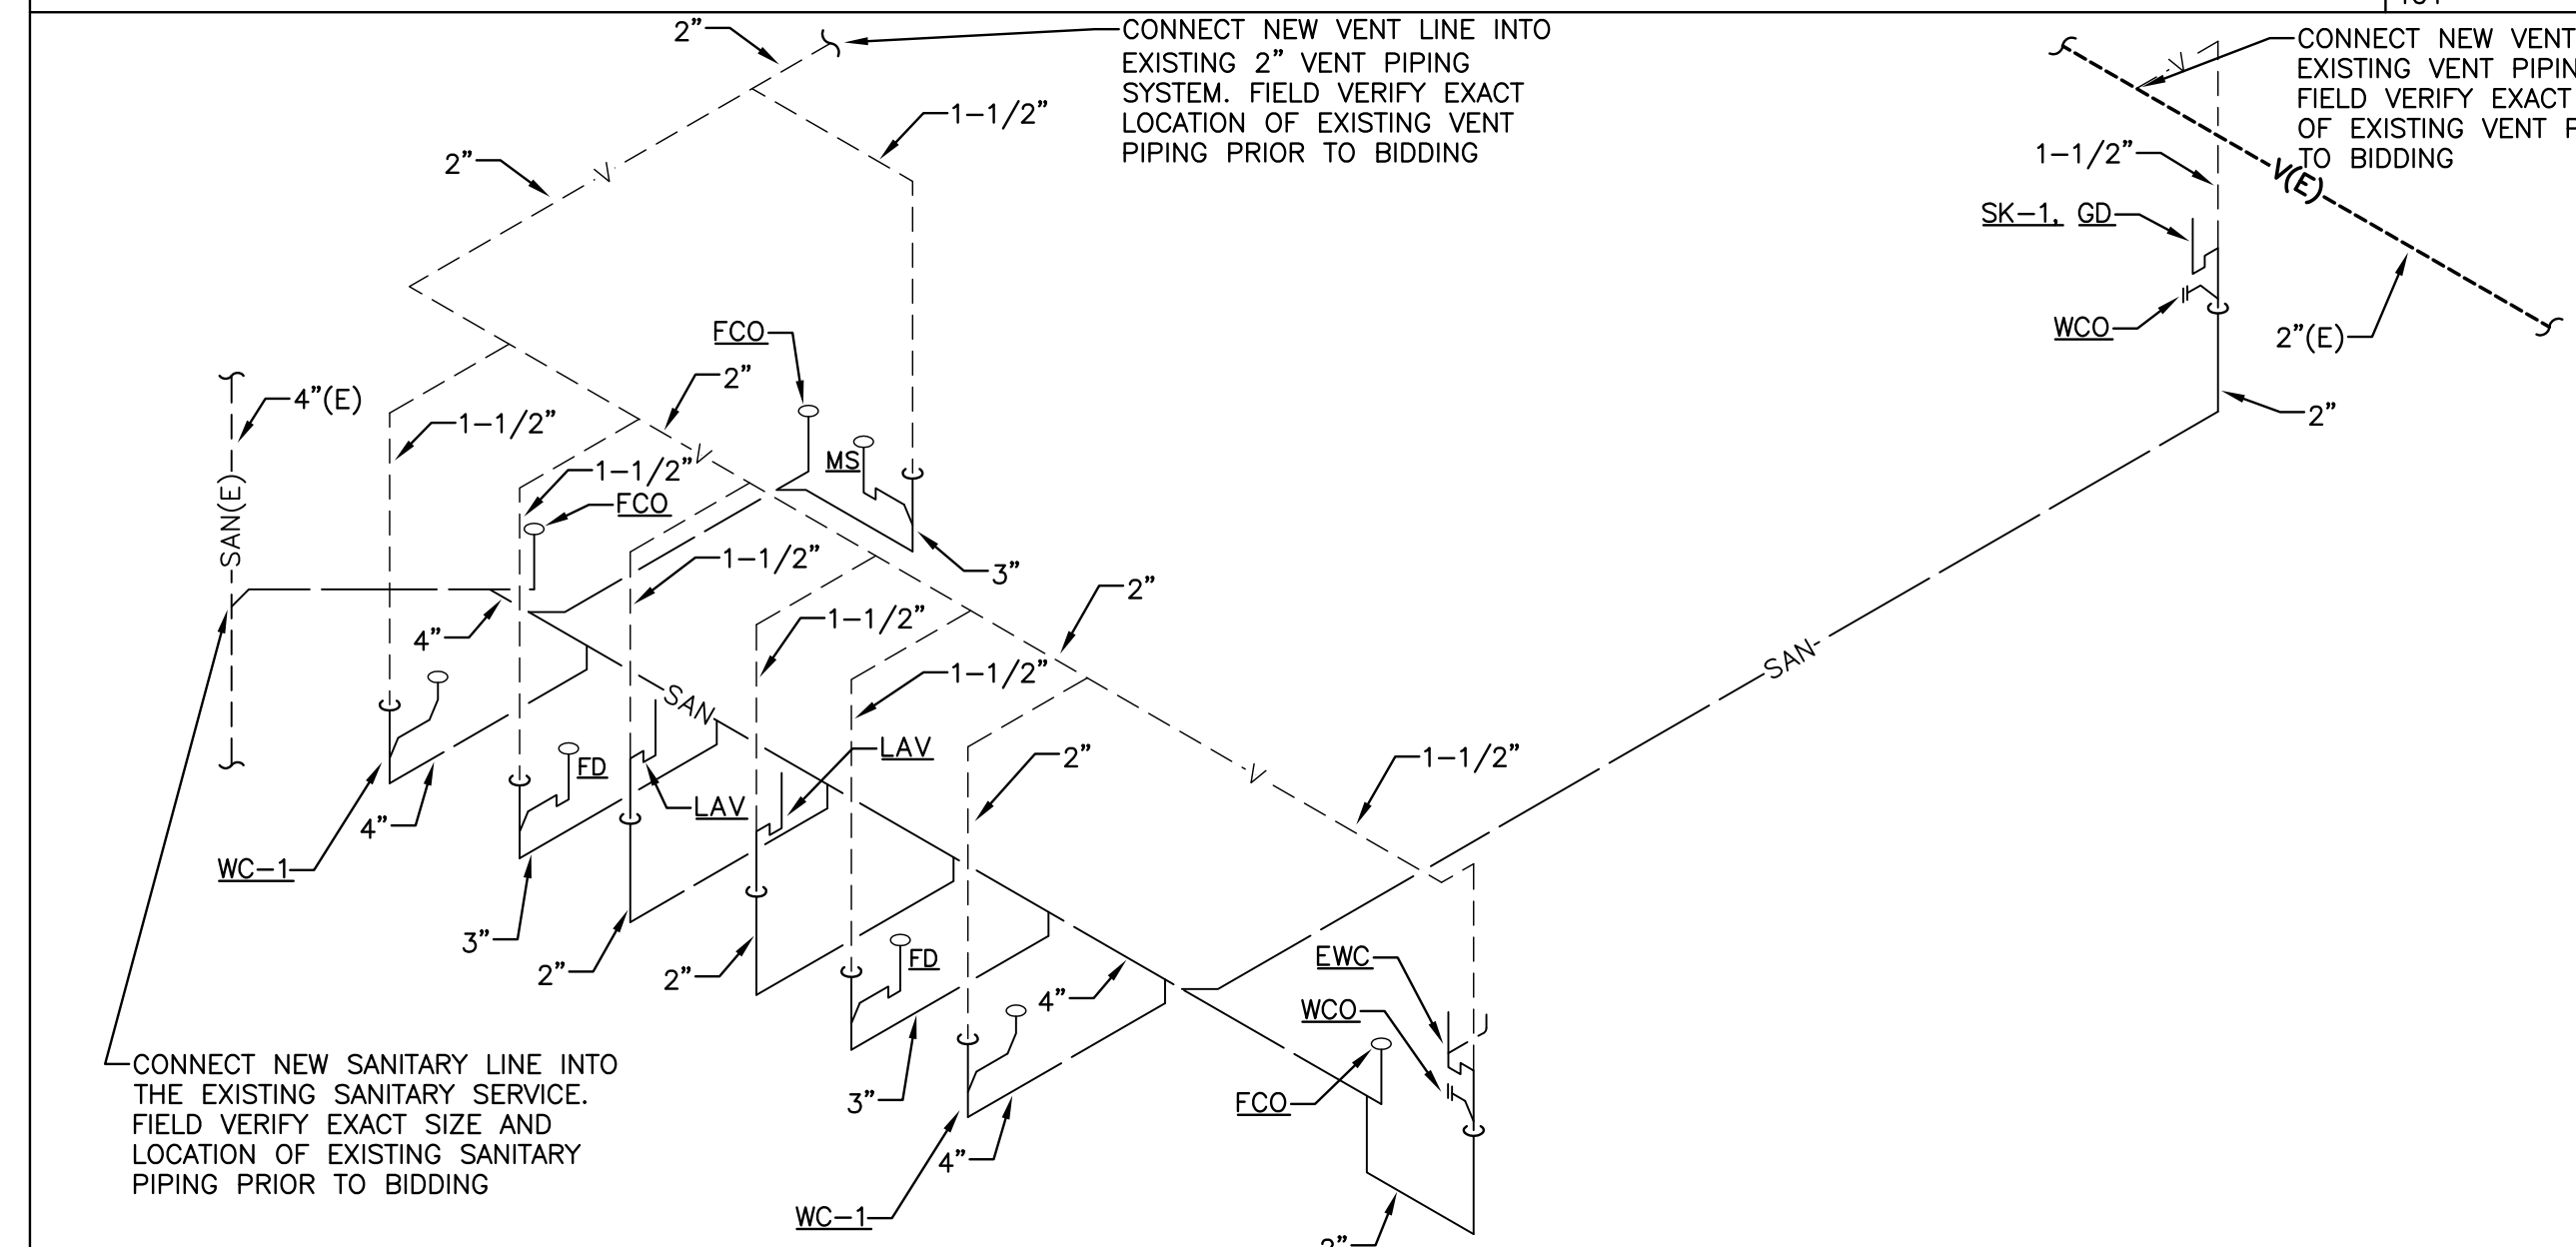

WASTE AND VENT RISER DIAGRAM

NOT TO SCALE  
400

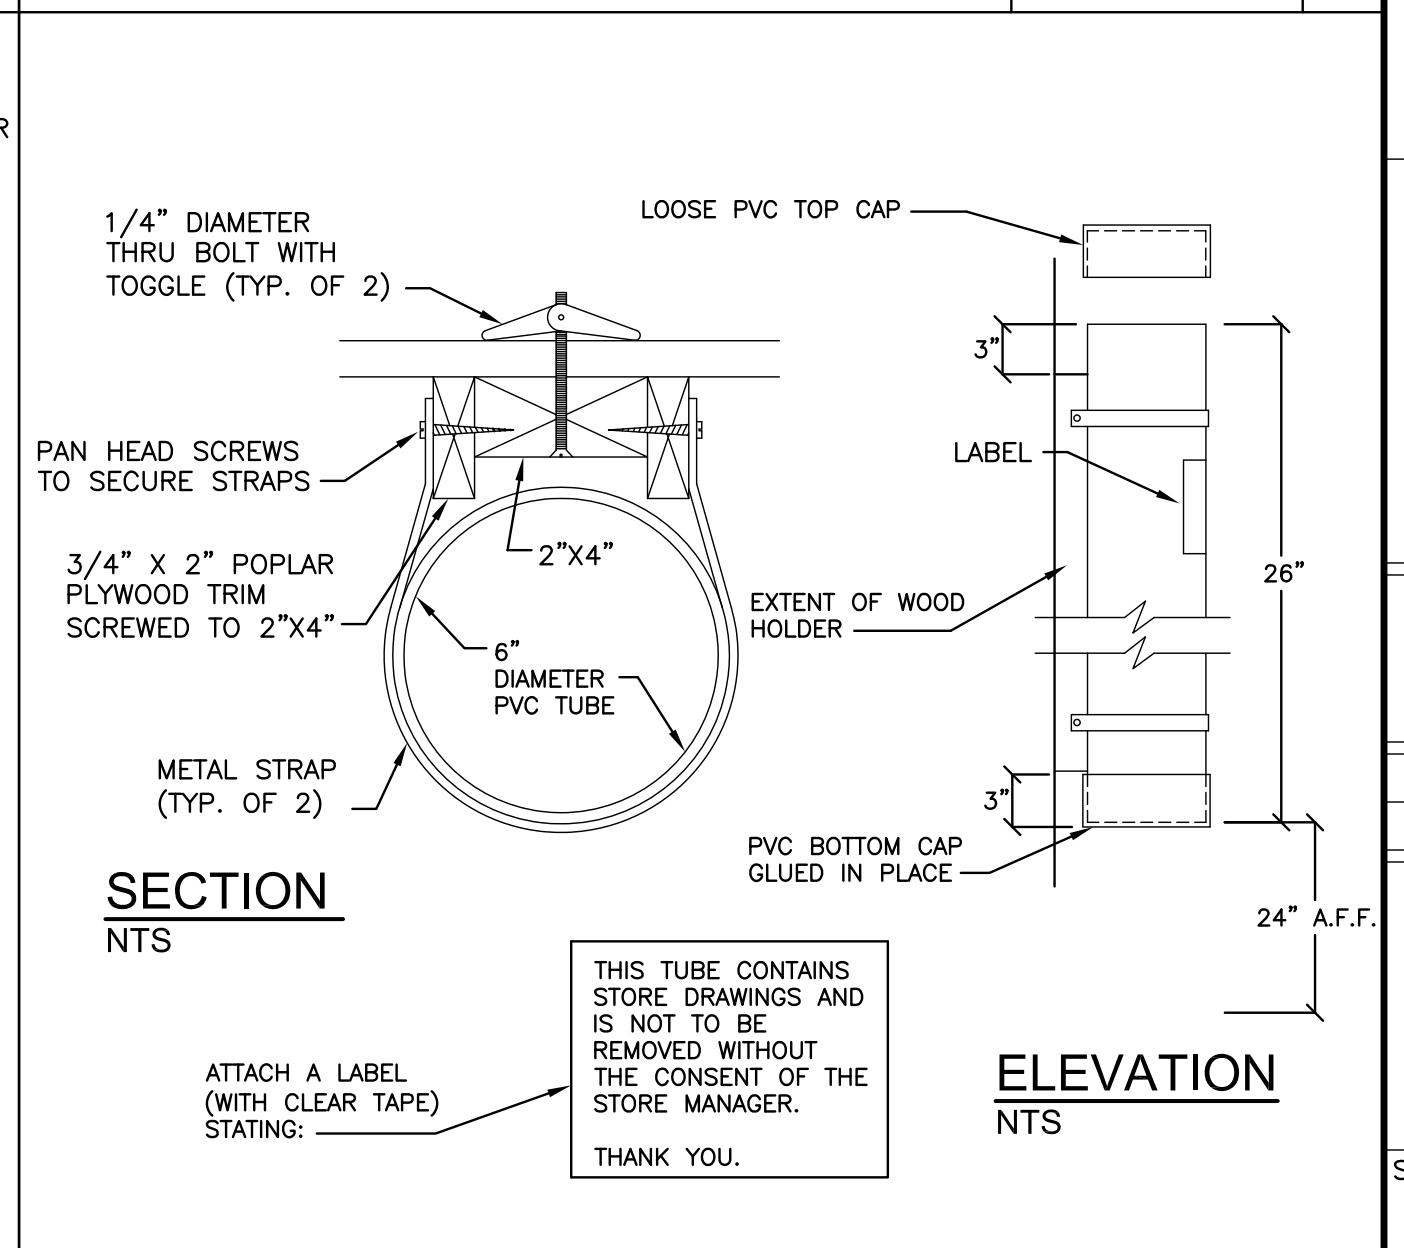

DRAWING TUBE

NOT TO SCALE  
102

H:\16068\Draws\CAD\CAD\_7641\_08\_P5-0.dwg, P5-0, 5/20/2016 4:07:36 PM, 1:1