

- C1 CHANDELIERS**  
 MANUFACTURER: ROOMBOARD  
 STYLE: OCTOPUS CHANDELER EE1-226-WH  
 COLOR: WHITE  
 NOTE: PROVIDE 1\"/>

**C1 SUSPENDED LIGHT FIXTURE**  
 MANUFACTURER: ROOMBOARD  
 STYLE: 25\"/>

**L1 RECESSED LED DOWNLIGHT**  
 MANUFACTURER: TSD  
 STYLE: TSD  
 COLOR: TSD

**L2 RECESSED LED DOWNLIGHT**  
 MANUFACTURER: TSD  
 STYLE: TSD  
 COLOR: TSD

**EX1 EXTERIOR WALL SCONCE**  
 MANUFACTURER: MODERN FORM  
 STYLE: HELIX  
 COLOR: GRANITE  
 NOTE: PROVIDE EXTERIOR GRADE LIGHT FIXTURE.  
 NOTE: REFER TO M11A300

**AH CEILING ACCESS PANEL**  
 MANUFACTURER: GLOBAL  
 STYLE: CONCEALED FRAME  
 COLOR: WHITE  
 NOTE: SIZE, LOCATION & QUANTITY AS REQUIRES FOR EQUIPMENT ACCESS.  
 REFER TO DESIGN / BUILD MECHANICAL (SWS)

**ACT-1 CEILING TILE**  
 MANUFACTURER: TSD  
 STYLE: TSD  
 COLOR: TSD

**GWB GIBB**  
 TYPE: C, GWB - PAINTED

**EXT-GWB EXISTING GIBB**  
 PATCH & FILL AS REQUIRED TO PROVIDE A SMOOTH LEVEL. BASE FOR APPLICATION OF SCHEDULED FINISH


**NOTE:**  
 1. REFER TO ELECTRICAL DESIGN / BUILD DRAWINGS FOR LIGHTING FIXTURE SCHEDULE  
 2. REFER TO INTERIOR ELEVATIONS FOR WALL SCONCE HEIGHTS  
 3. EXISTING CONDITIONS MAY BE UNOCCUPY DURING DEMOLITION THAT MAY REQUIRE MODIFICATIONS OF CEILING CONSTRUCTION & CEILING HEIGHTS. GENERAL CONTRACTOR SHALL REPORT ALL POTENTIAL OBSTACLES & CONCERNS TO ARCHITECT PRIOR TO PROCEEDING.

M1 CEILING DETAIL - 1

2 EX1 - EXTERIOR SCONCE

M11 EXTERIOR LIGHTING PLAN

M15 RCP LEGEND

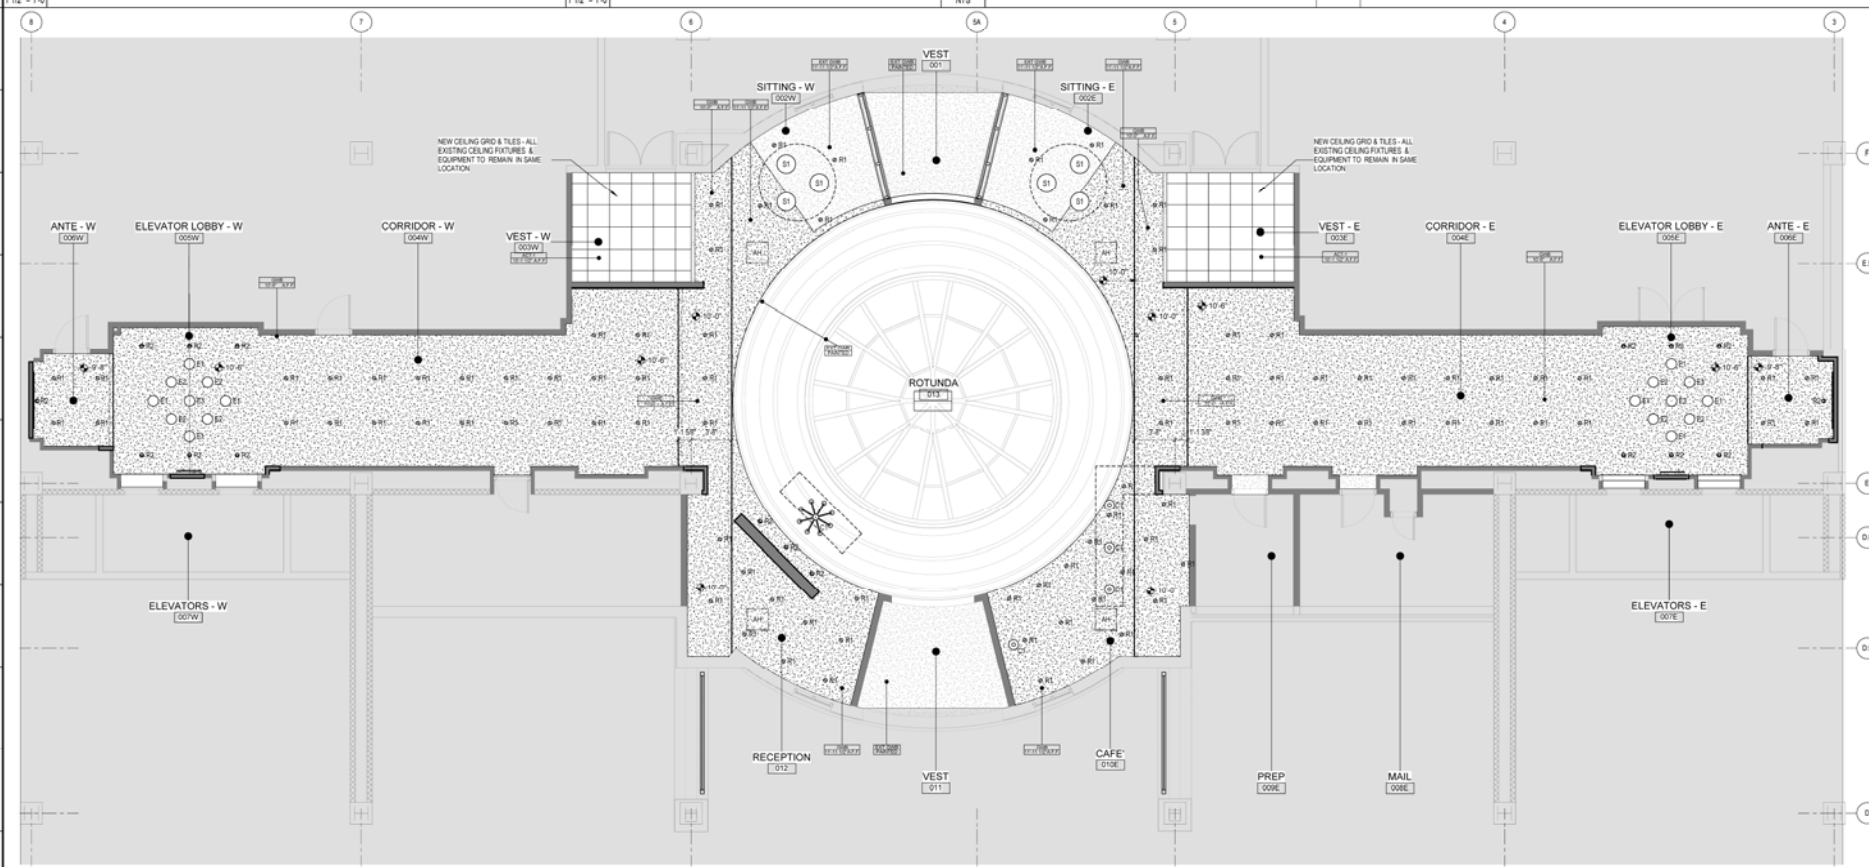

A1 T.O. 1ST FLOOR - RCP



**GAWRON  
 TURGEON  
 ARCHITECTS**

**100 MIDDLE STREET  
 LOBBY RENOVATIONS  
 ALBANY ROAD  
 100 MIDDLE STREET**

REVISIONS	
#	DATE DESCRIPTION
A	10.06.16 ISSUED FOR CLIENT REVIEW
B	10.12.16 ISSUED FOR PERMIT

DATE:	10.12.16
PROJECT #:	006B5
DRAWN BY:	DPB
CHECKED BY:	NET
DRAWING SCALE:	As Indicated

**SHEET TITLE**  
 FIRST FLOOR  
 RELECTED CEILING  
 PLAN

**A301**

© COPYRIGHT 1985-2016  
 ALL RIGHTS RESERVED  
 THIS DOCUMENT IS THE PROPERTY OF  
 GAWRON TURGEON ARCHITECTS