


25 PEARL STREET
PORTLAND, MAINE

#	DATE	DESCRIPTION
REVISIONS		
	Date Issued	5/6/14
	Project Number	14108
	Drawing Scale	A5 NOTED
	SHEET NAME	

LEVEL 2 RCP

Drawn By
Checked By **A2.1**

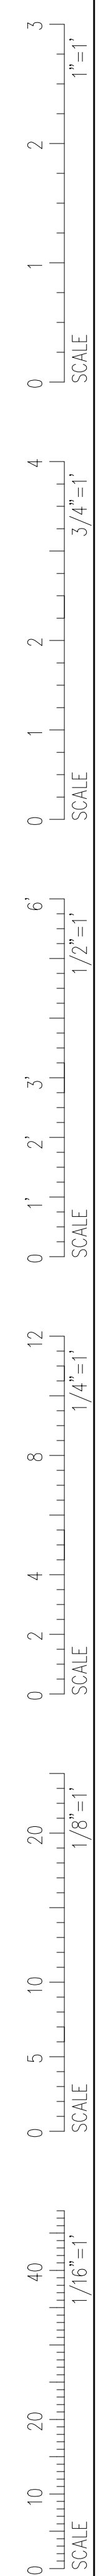


CEILING LEGEND

- ACT-1 - OPEN OFFICES, OFFICES & CONFERENCE ROOMS ULTIMA HIGH NRC - ARMSTRONG # 1942
- ARMSTRONG WOODWORKS GRILLE # 5665 - SPECIES TBD
- ACT-2 - BATHS & HALLWAYS - ARMSTRONG FINE FIGURED #141

CONCEPT LIGHTING LAYOUT AND FIXTURES, FULL LIGHTING PACKAGE AND LAYOUT TO BE DETERMINED WITH D/B ELECTRICAL. ITEMS SHOWN HERE FOR BUDGET PURPOSES.

- EXISTING FIXTURE TO BE REUSED, MATCH FIXTURE WHEN NEW ITEMS REQUIRED
- EXISTING DIRECT / INDIRECT FIXTURE TO BE REUSED, MATCH FIXTURE WHEN NEW ITEMS REQUIRED
- RECESSED DOWNLIGHT
- 2 X 4 FIXTURE
- ACCENT FIXTURE W/ DRUM SHADE
- ACCENT PENDANT FOCAL POINT 'GROOVE C'

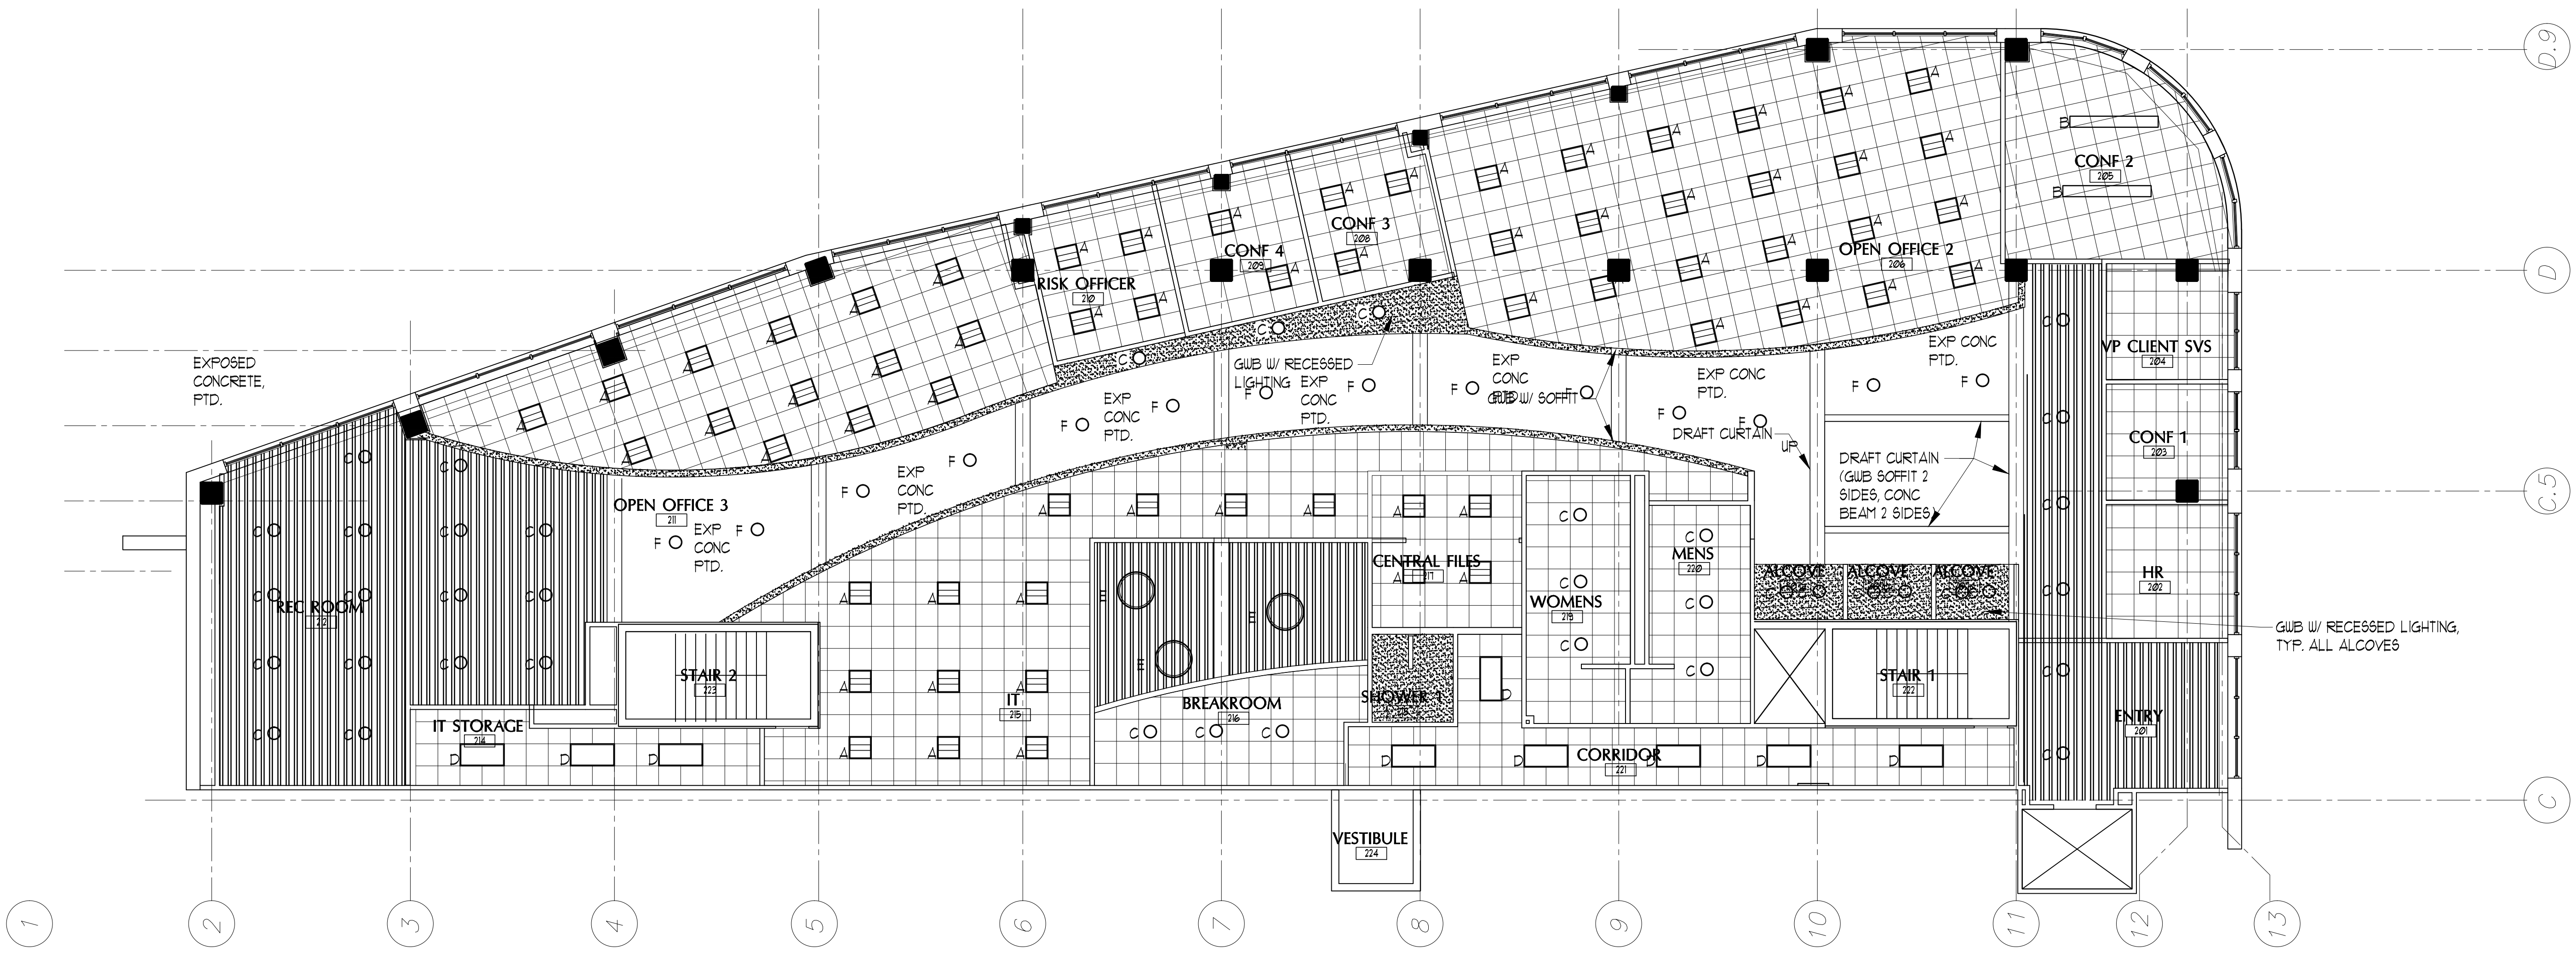

2ND FLOOR RCP
SCALE: 1/8" = 1'-0"