


**NOTES:**

- SEE E0.0 FOR LEGEND, ABBREVIATIONS AND GENERAL NOTES.

**KEYED NOTES:**

- AREA NOT IN SCOPE. RECONNECT LIGHT & SWITCH TO LOCAL LIGHTING CIRCUIT.

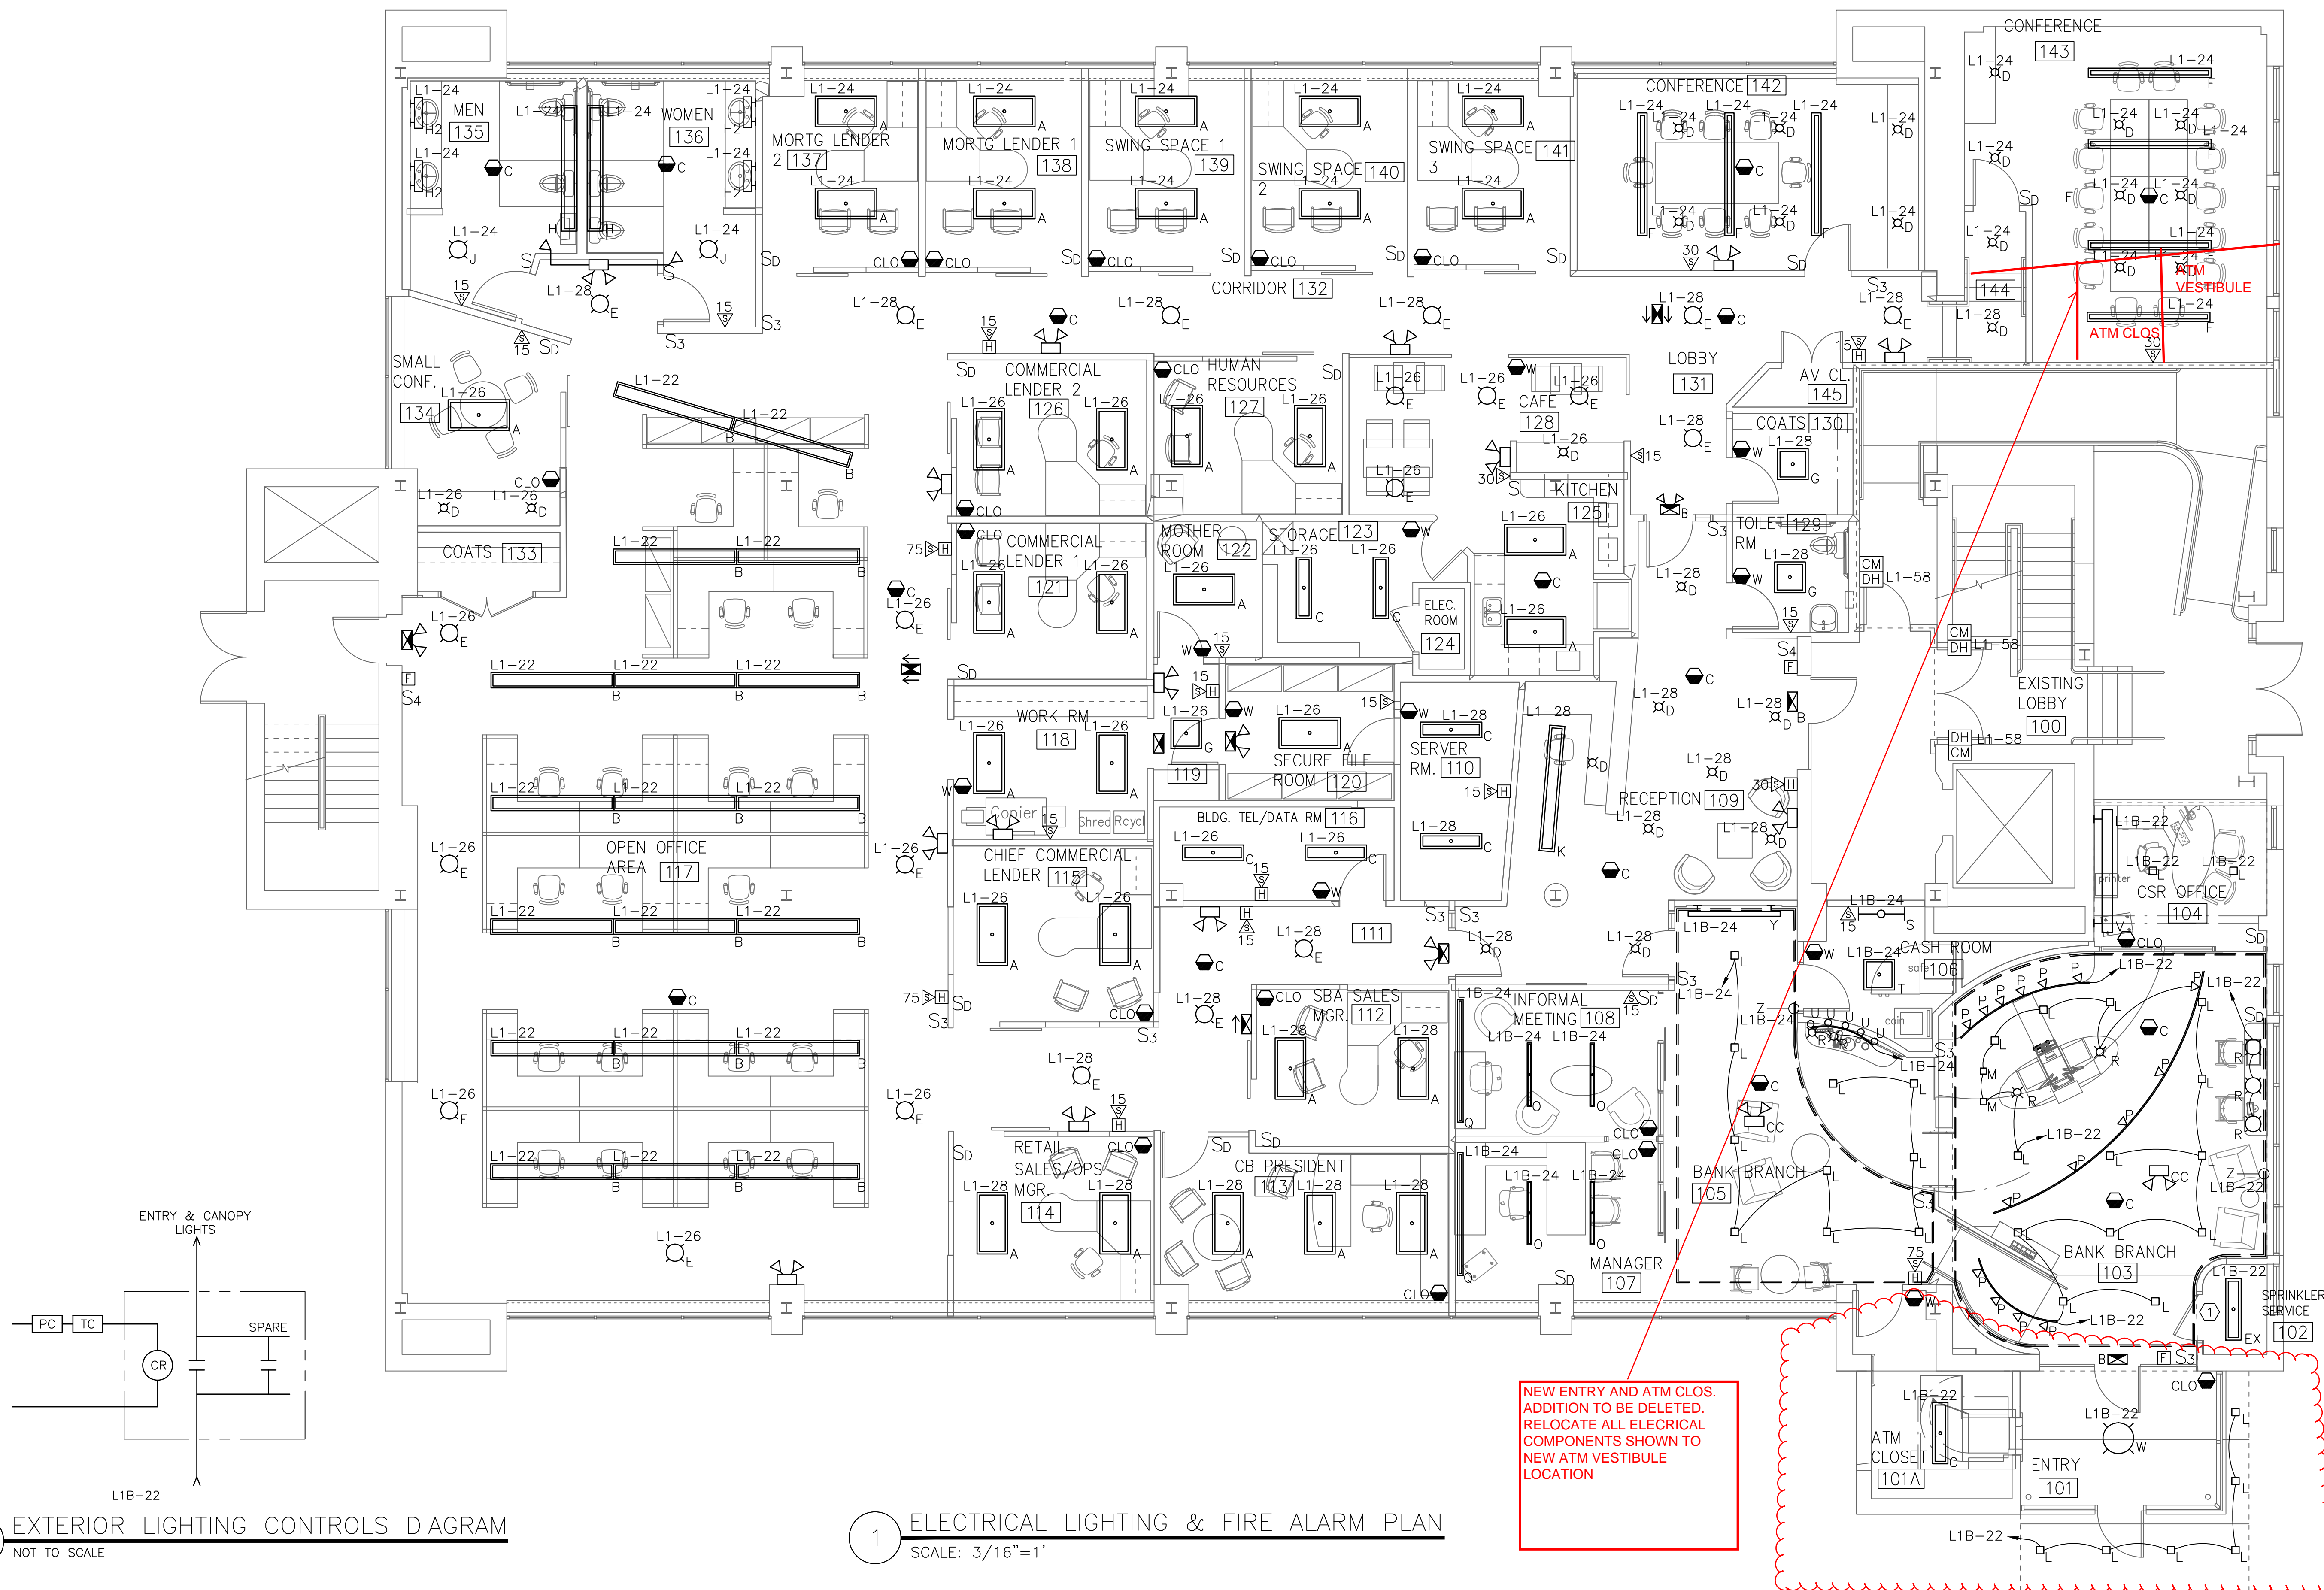

**2** EXTERIOR LIGHTING CONTROLS DIAGRAM  
 NOT TO SCALE

**1** ELECTRICAL LIGHTING & FIRE ALARM PLAN  
 SCALE: 3/16"=1'