

KELLEY MECHANICAL
MECHANICAL CONTRACTORS
MECHANICAL ENGINEERS

DESIGN BUILD

145 BROADWAY ST.
P.O. BOX 1310
WESTBORO, MA 01581

TEL: (508) 851-1187
FAX: (508) 851-5113

PROJECT
MAYHEW-THOMAS BLOCK

COMMERCIAL ST.
PORTLAND, ME.

REVISIONS		
REV.	DESCRIPTION	DATE
1	ISSUED FOR PERMIT	8-30-00

SCALE: 1/8"=1'-0"

DATE: 8-21-00

DRAWN BY: DWL

DESIGN BY: SCL

CHECKED BY: JJK

PROJECT NUMBER

FILE NUMBER MTBP3


DRAWING TITLE
3RD FLOOR MECHANICAL PLUMBING PLAN

DRAWING NUMBER


P3

Alliance
CONSTRUCTION
INCORPORATED

100 PLEASANT HILL ROAD, SCARBOROUGH, MAINE 04074
Tel. (207) 885-0800 Fax (207) 885-0848
E-mail: www.allianceinc.com

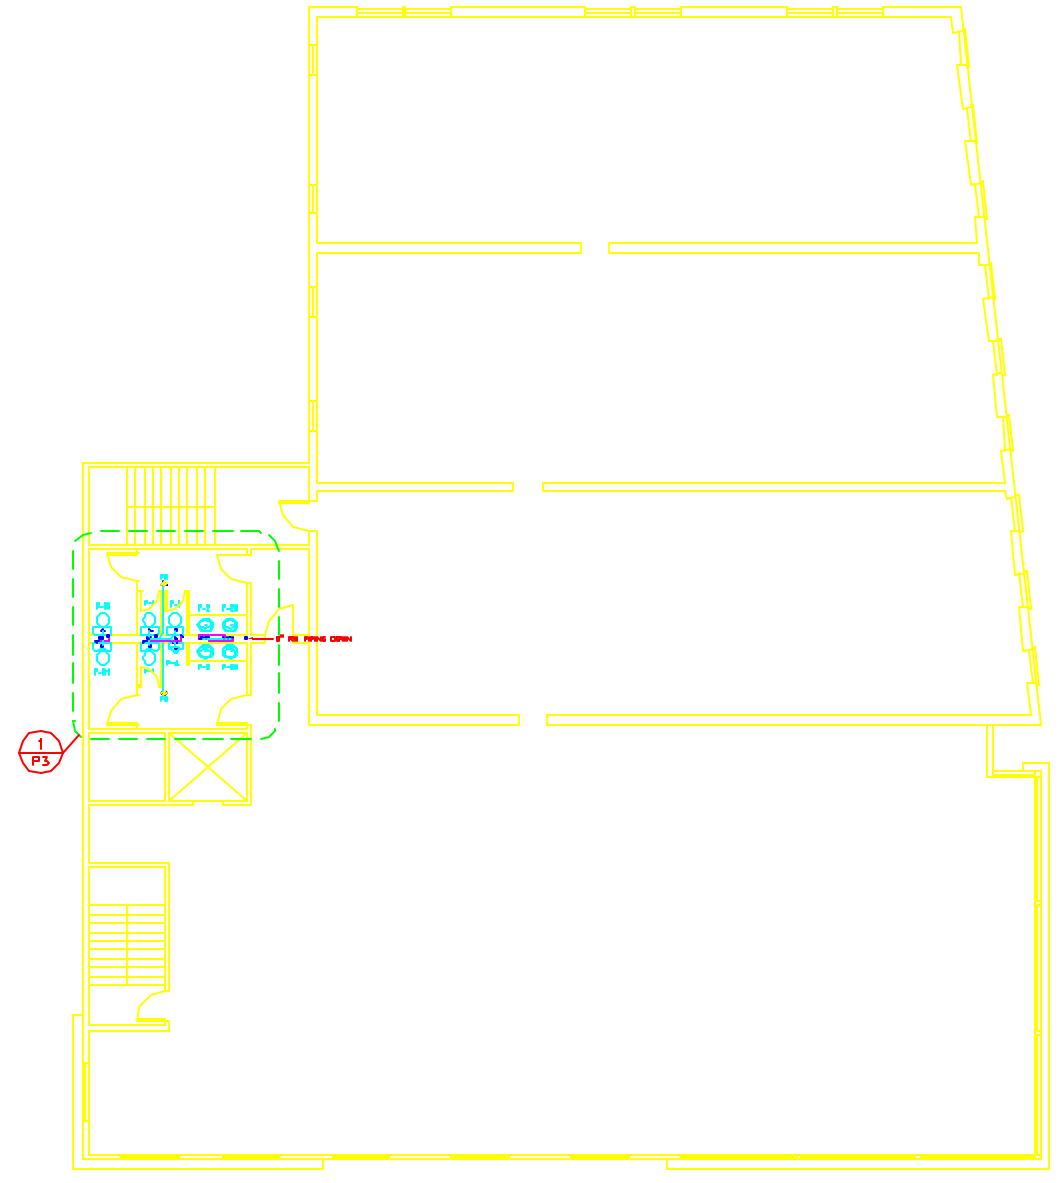

3RD FLOOR PLUMBING PLAN
SCALE 1/8"=1'-0"

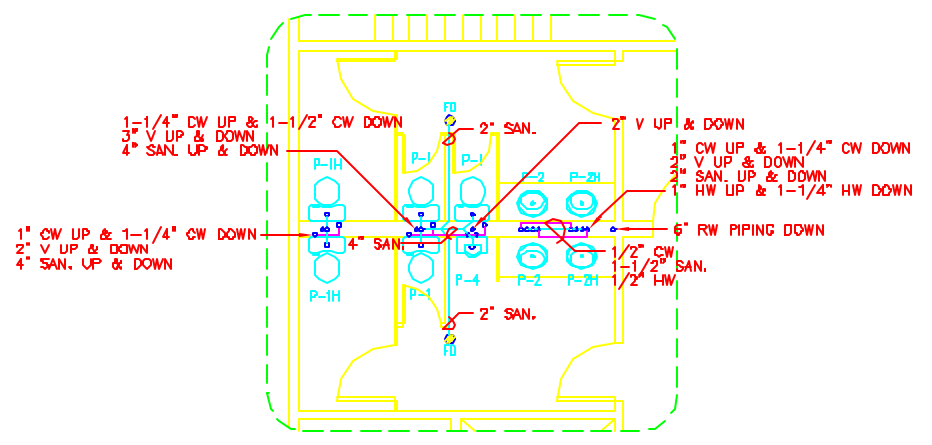

3RD FLOOR PLUMBING PLAN
SCALE 1/4"=1'-0"