




BATHROOM DETAIL
 SCALE 1/4"=1'-0"

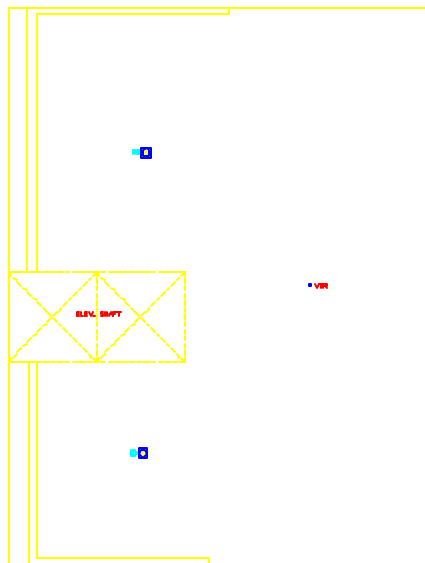

PENTHOUSE ROOF PLAN
 SCALE 1/8"=1'-0"

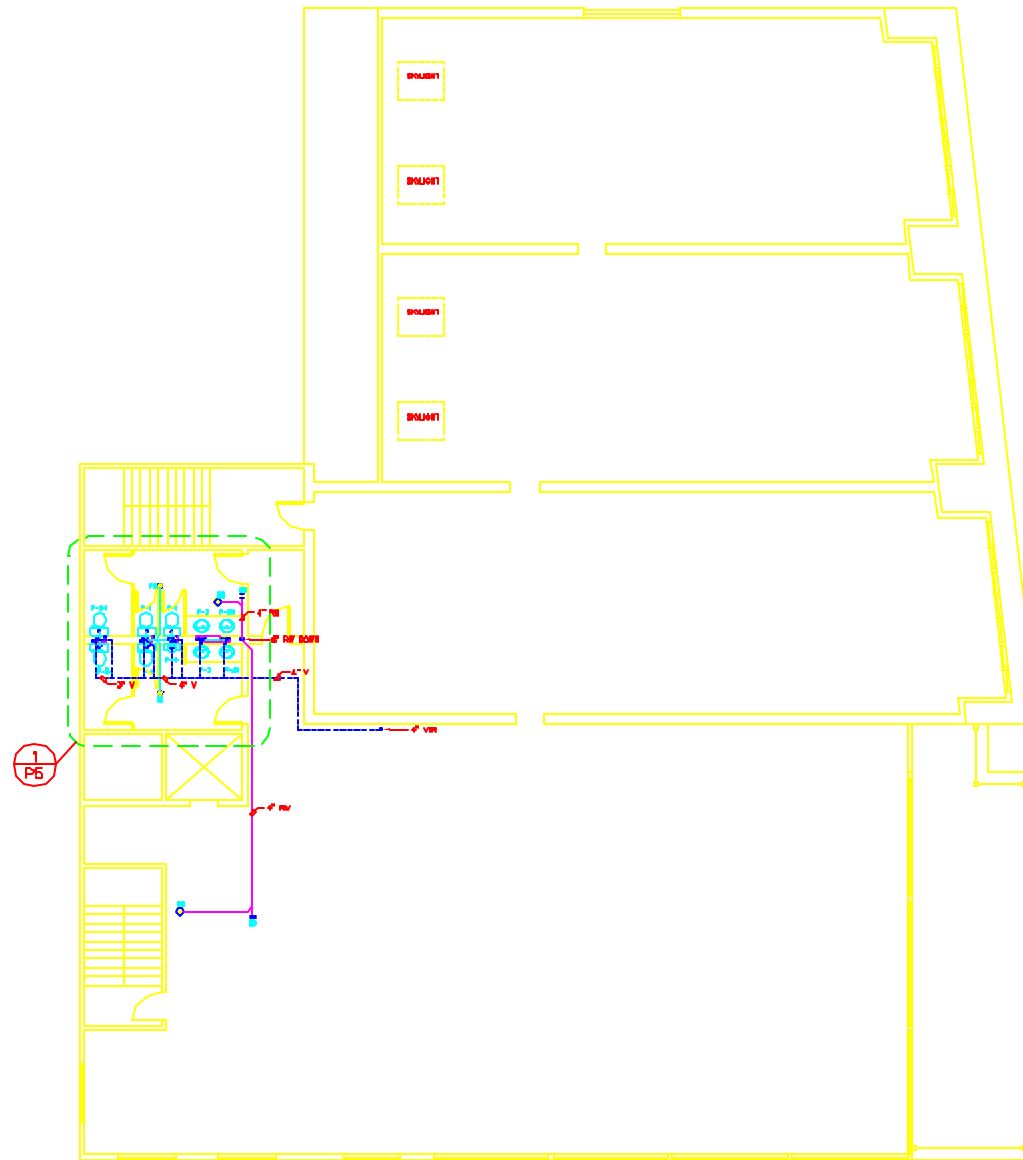

5TH FLOOR PLUMBING PLAN
 SCALE 1/8"=1'-0"

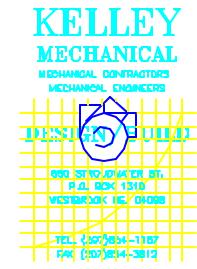

PROJECT
MAYHEW-THOMAS BLOCK

COMMERCIAL ST.
 PORTLAND, ME.

REVISIONS		
REV.	DESCRIPTION	DATE
1	ISSUED FOR PERMIT	6-30-00

SCALE: 1/8"=1'-0"

DATE: 6-21-00

DRAWN BY: DWL

DESIGN BY: SCL

CHECKED BY: JJK

PROJECT NUMBER

FILE NUMBER MTBP5

DRAWING TITLE
5TH FLOOR MECHANICAL PLUMBING PLAN

DRAWING NUMBER

P5

