

PROJECT
MAYHEW-THOMAS BLOCK

COMMERCIAL ST.
PORTLAND, ME.

REVISIONS		
REV.	DESCRIPTION	DATE
1	ISSUED FOR PERMIT	8-26-00

SCALE: 1/8"=1'-0"

DATE: 8-21-00

DRAWN BY: DWL

DESIGN BY: SCL


CHECKED BY: JJK

PROJECT NUMBER


FILE NUMBER VTEP2

DRAWING TITLE
2ND FLOOR MECHANICAL PLUMBING PLAN


DRAWING NUMBER
P2

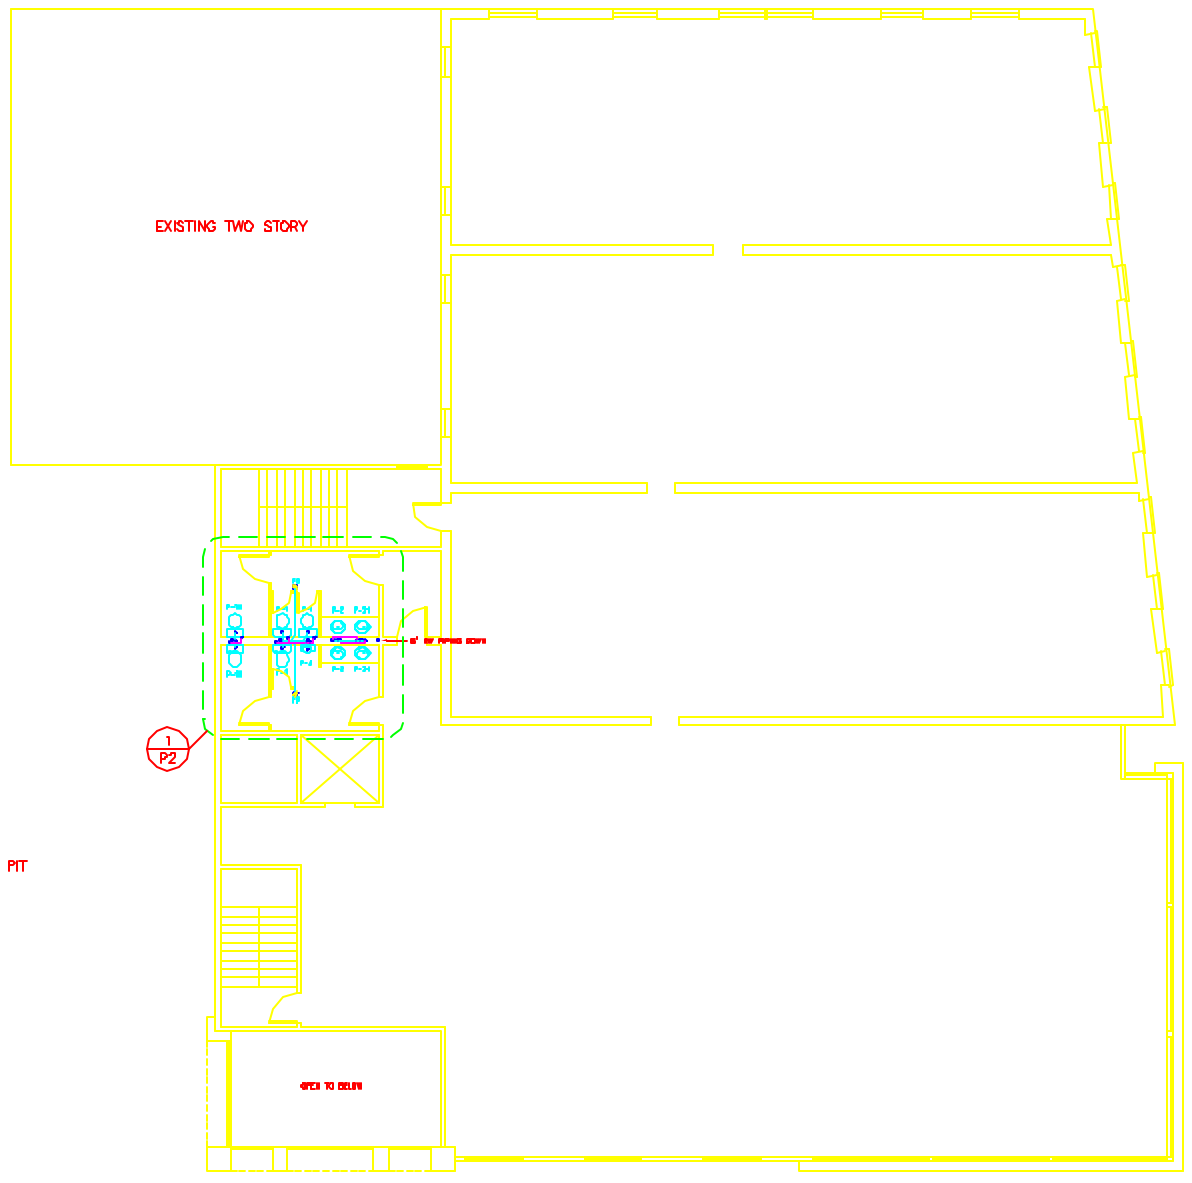

2ND FLOOR PLUMBING PLAN
SCALE 1/8"=1'-0"

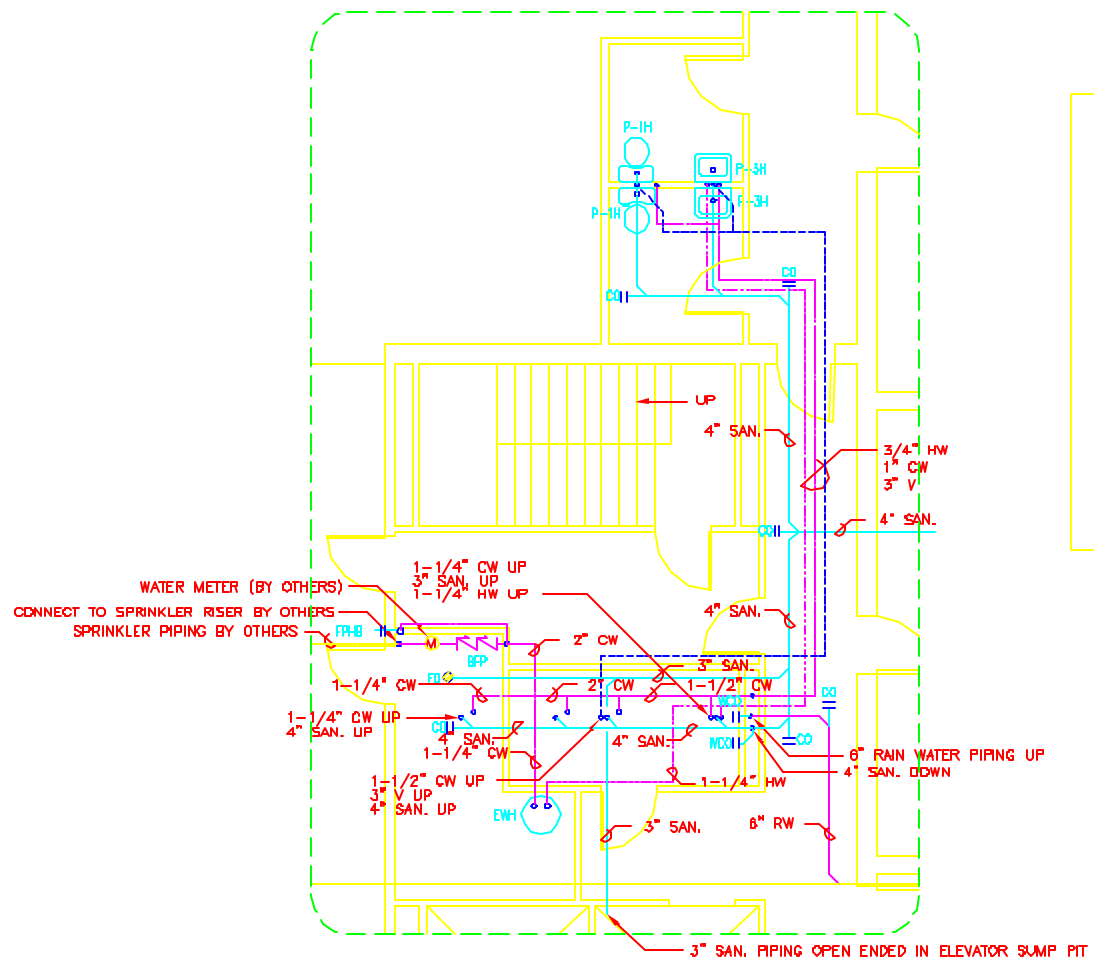

1ST FLOOR PLUMBING DETAIL
SCALE 1/4"=1'-0"

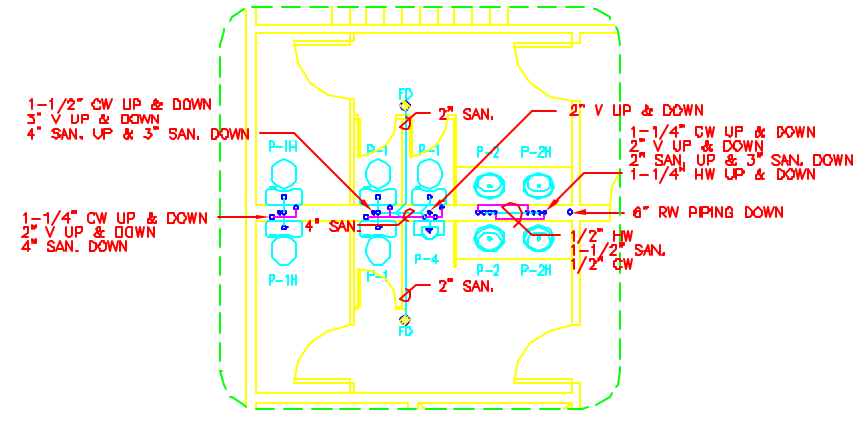

2ND FLOOR PLUMBING DETAIL
SCALE 1/4"=1'-0"

