


scenell - Mon, 17 Jul 2006 - 2:53pm

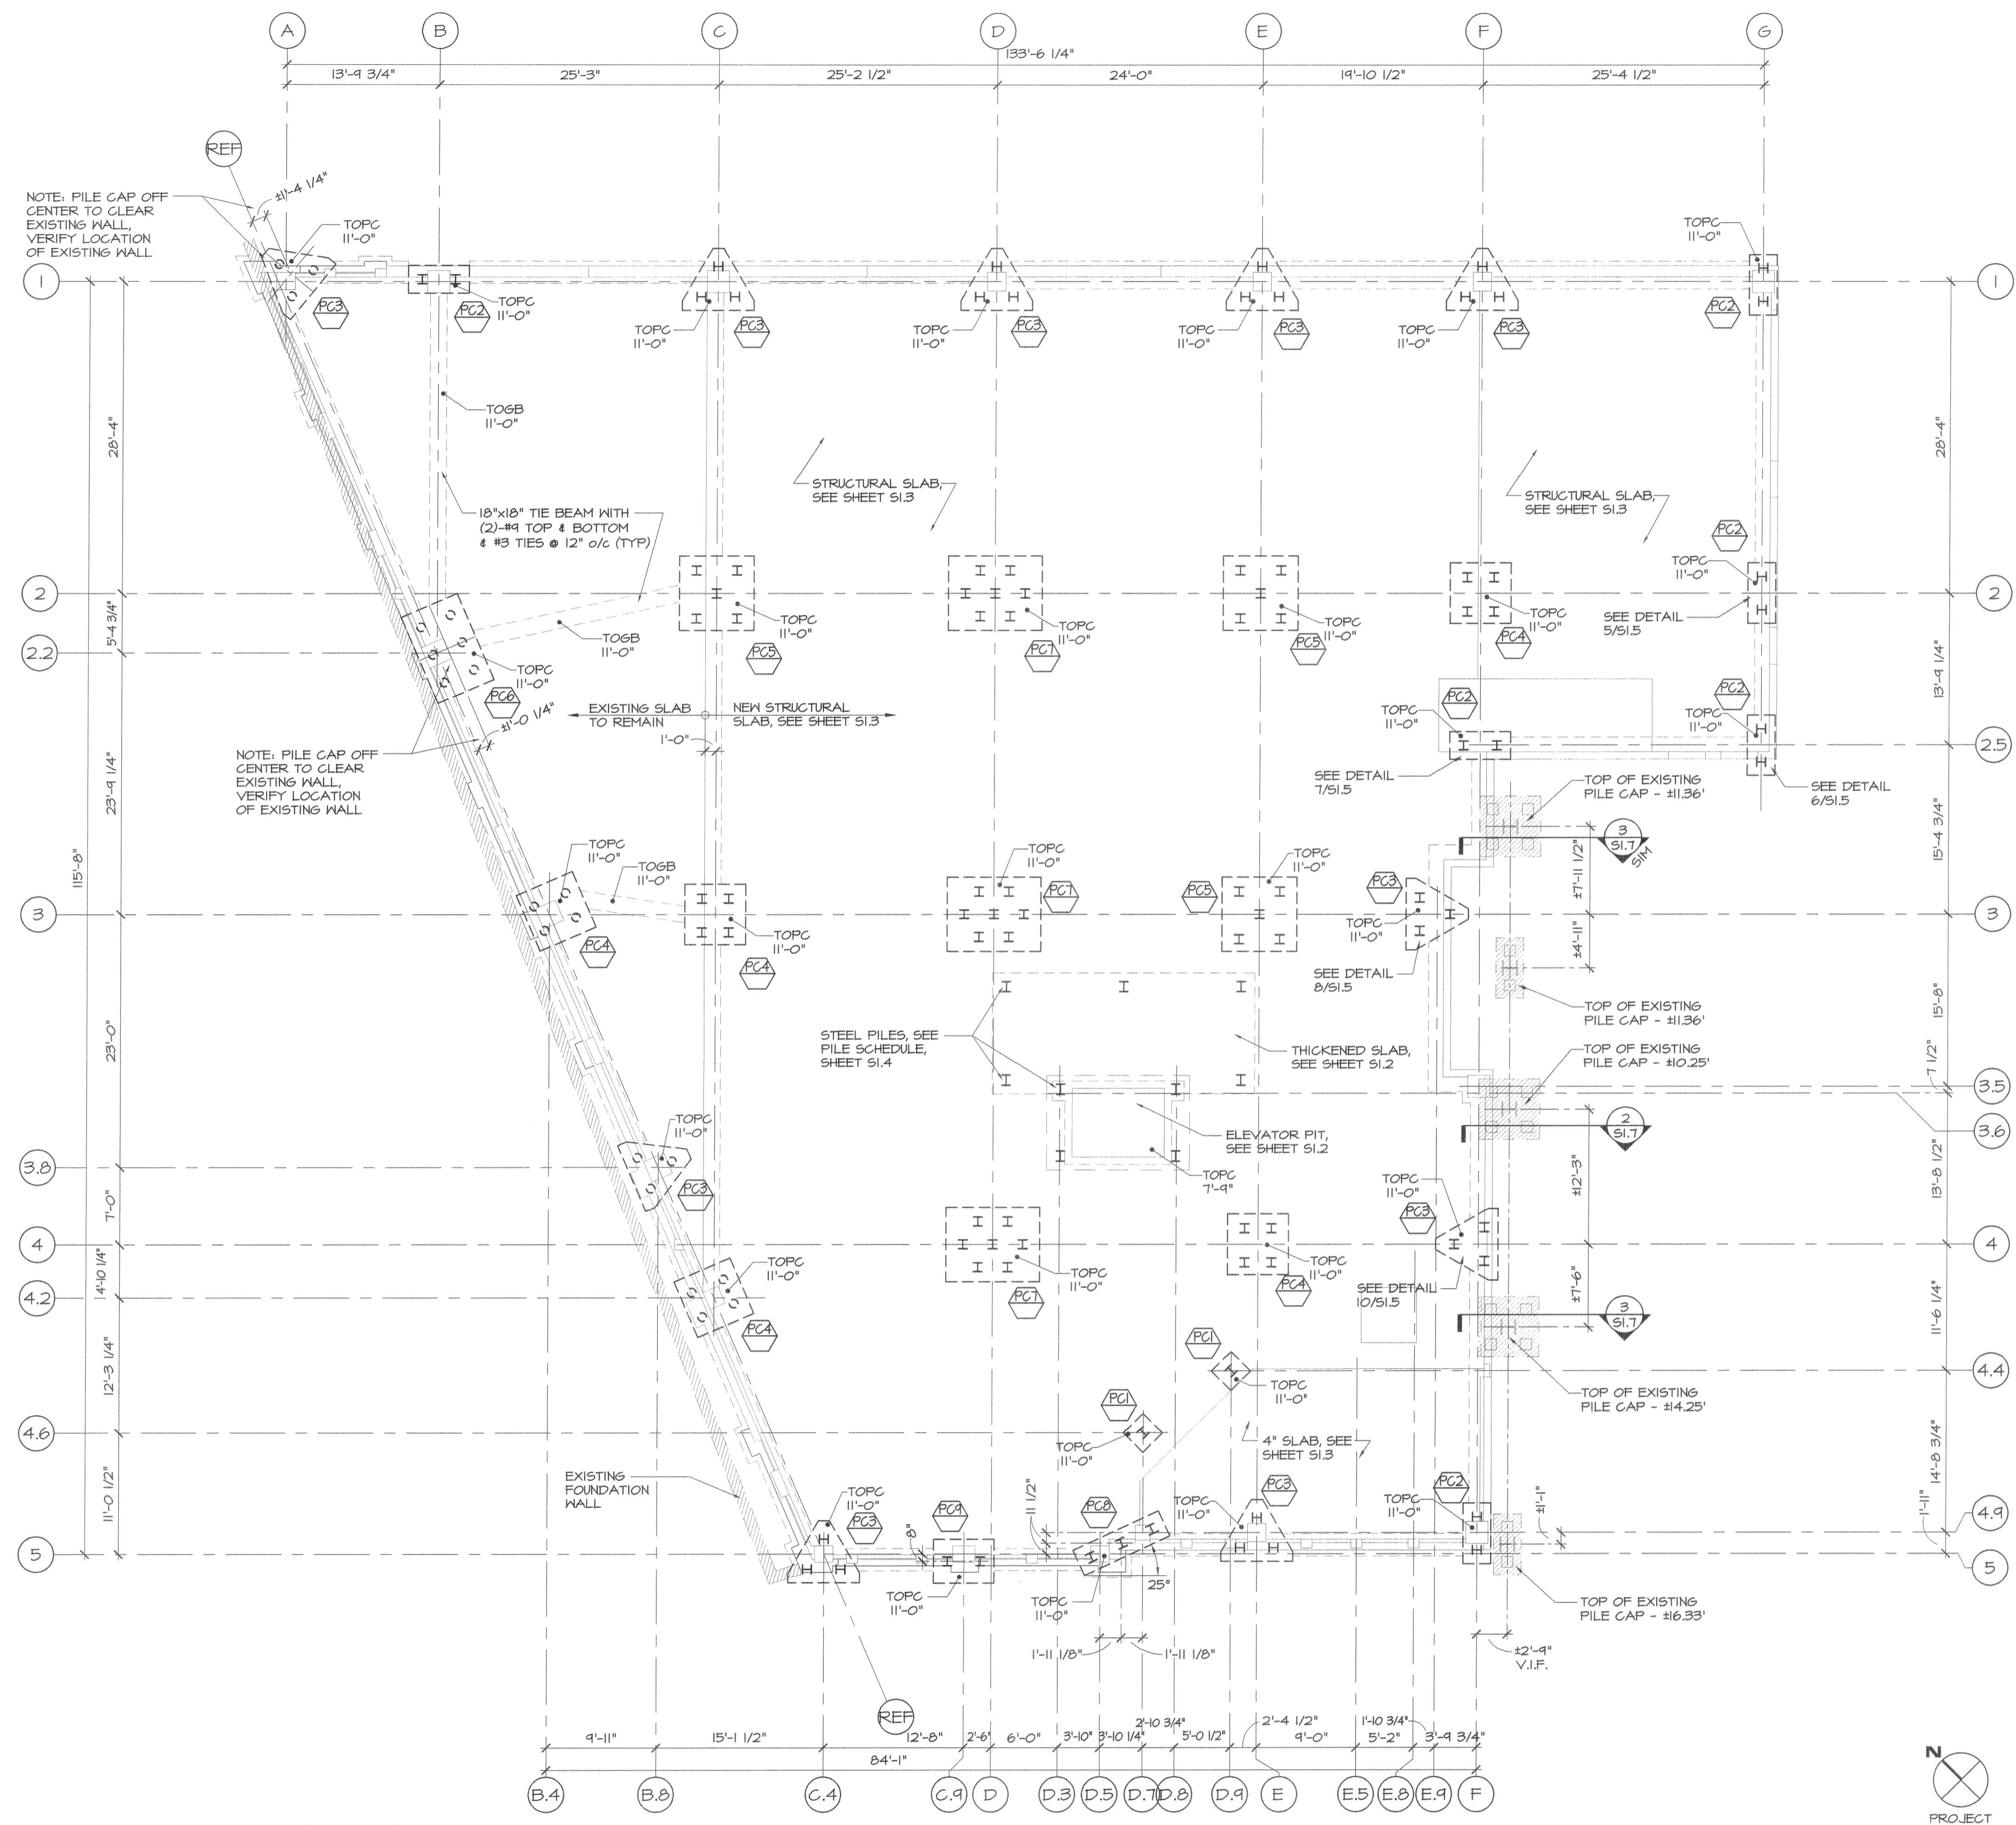

PILE CAP PLAN

SCALE: 1/8" = 1'-0"


- NOTES:**
- SEE SHEET S0.1 FOR ADDITIONAL INFORMATION
 - SEE SHEET S1.2 FOR FOUNDATION PLAN
 - SEE SHEET S1.3 FOR STRUCTURAL SLAB PLAN
 - SEE SHEET S1.4 FOR PILE SCHEDULE

BIDDER NOTE:
 PROVIDE PRICING FOR AN ALTERNATE TO PROVIDE UNDERSLAB DRAINAGE TO TIE INTO EXISTING FOUNDATION DRAINAGE SYSTEM, 25'-0" O.C.

MARK	NUMBER OF PILE(S)	DIMENSIONS				REBAR		PLAN DETAIL	SECTION DETAIL
		LONG	SHORT	DEPTH "H" PILE	DEPTH ROUND PILE	LONG BARS	SHORT BARS		
PC1	1	2'-6"	2'-6"	2'-6"	--	(3)-#5	(3)-#5	1/S1.4	10/S1.4
PC2	2	5'-6"	2'-6"	2'-4"	--	(4)-#7	(5)-#4	2/S1.4	10/S1.4
PC3	3	5'-6"	5'-2"	2'-6"	2'-6"	(3)-#7	(3) #4S	3/S1.4	10/S1.4
PC4	4	5'-6"	5'-6"	2'-6"	2'-6"	(8)-#7	(8)-#7	4/S1.4	10/S1.4
PC5	5	6'-4"	6'-4"	2'-10"	--	(11)-#7	(11)-#7	5/S1.4	10/S1.4
PC6	6	8'-6"	5'-6"	--	3'-8"	(11)-#7	(13)-#7	6/S1.4	10/S1.4
PC7	7	8'-6"	6'-4"	3'-0"	--	(15)-#7	(16)-#7	7/S1.4	10/S1.4
PC8	3	8'-6"	2'-6"	2'-4"	--	(5)-#7	(10)-#4	8/S1.4	10/S1.4
PC9	2	5'-6"	4'-0"	2'-4"	--	(4)-#7	(5)-#4	9/S1.4	10/S1.4

NOTE: REFER TO SHEET S1.5 FOR ANCHOR BOLT LOCATIONS

SYMBOLS LEGEND:

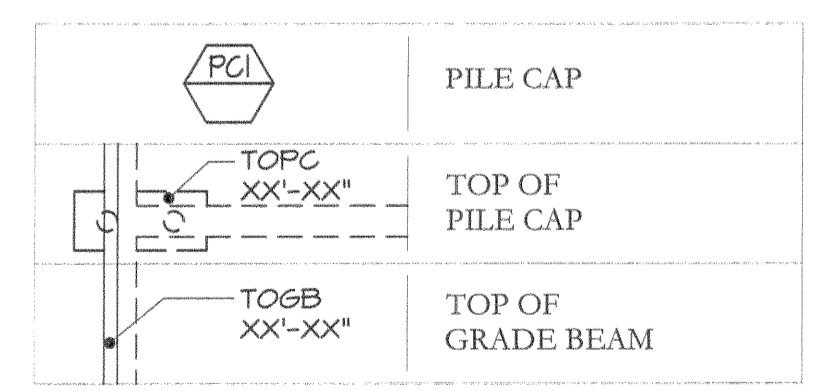

PRO CON
 INCORPORATED
 Design and Construction Management
 ARCHITECTURE
 A Sebbins Company
 P.O. Box 480, Manchester, NH 03108
 603.632.1511 Fax 603.632.1520



ISSUE:
 05/26/2006 - ISSUED FOR PRICING
 07/11/2006 - ISSUED FOR PERMIT

CUSTOM HOUSE SQUARE
 300 FORE STREET
 PORTLAND, MAINE
 PILE CAP PLAN

PROJECT ARCHITECT:
 MW
 DRAWN BY:
 SO, BR, AC
 PROJECT #:
 300506

S1.1