

NOTE:


- SEE SHEET E-001 FOR LEGEND AND GENERAL NOTES.
- ALL EXIT SIGNS TO BE FED FROM TP2-8.

KEYED NOTE:

- ① EXISTING STAIR LIGHTING TO REMAIN, MODIFY LOCATIONS IF REQUIRED FOR INSTALLATION OF NEW DOORS.

ESB
E.S. BOULOS CO
 ELECTRICAL CONTRACTORS
 45 BRADLEY DRIVE
 WESTBROOK, ME 04092
 TEL: (207) 464-3706
 FAX: (207) 464-1833

SM
RT
 ARCHITECTURE ENGINEERING PLANNING
 SWRT
 144 Fore Street/P.O. Box 618
 Portland, Maine 04104
 tel. (207) 775-3846
 fax. (207) 775-1070

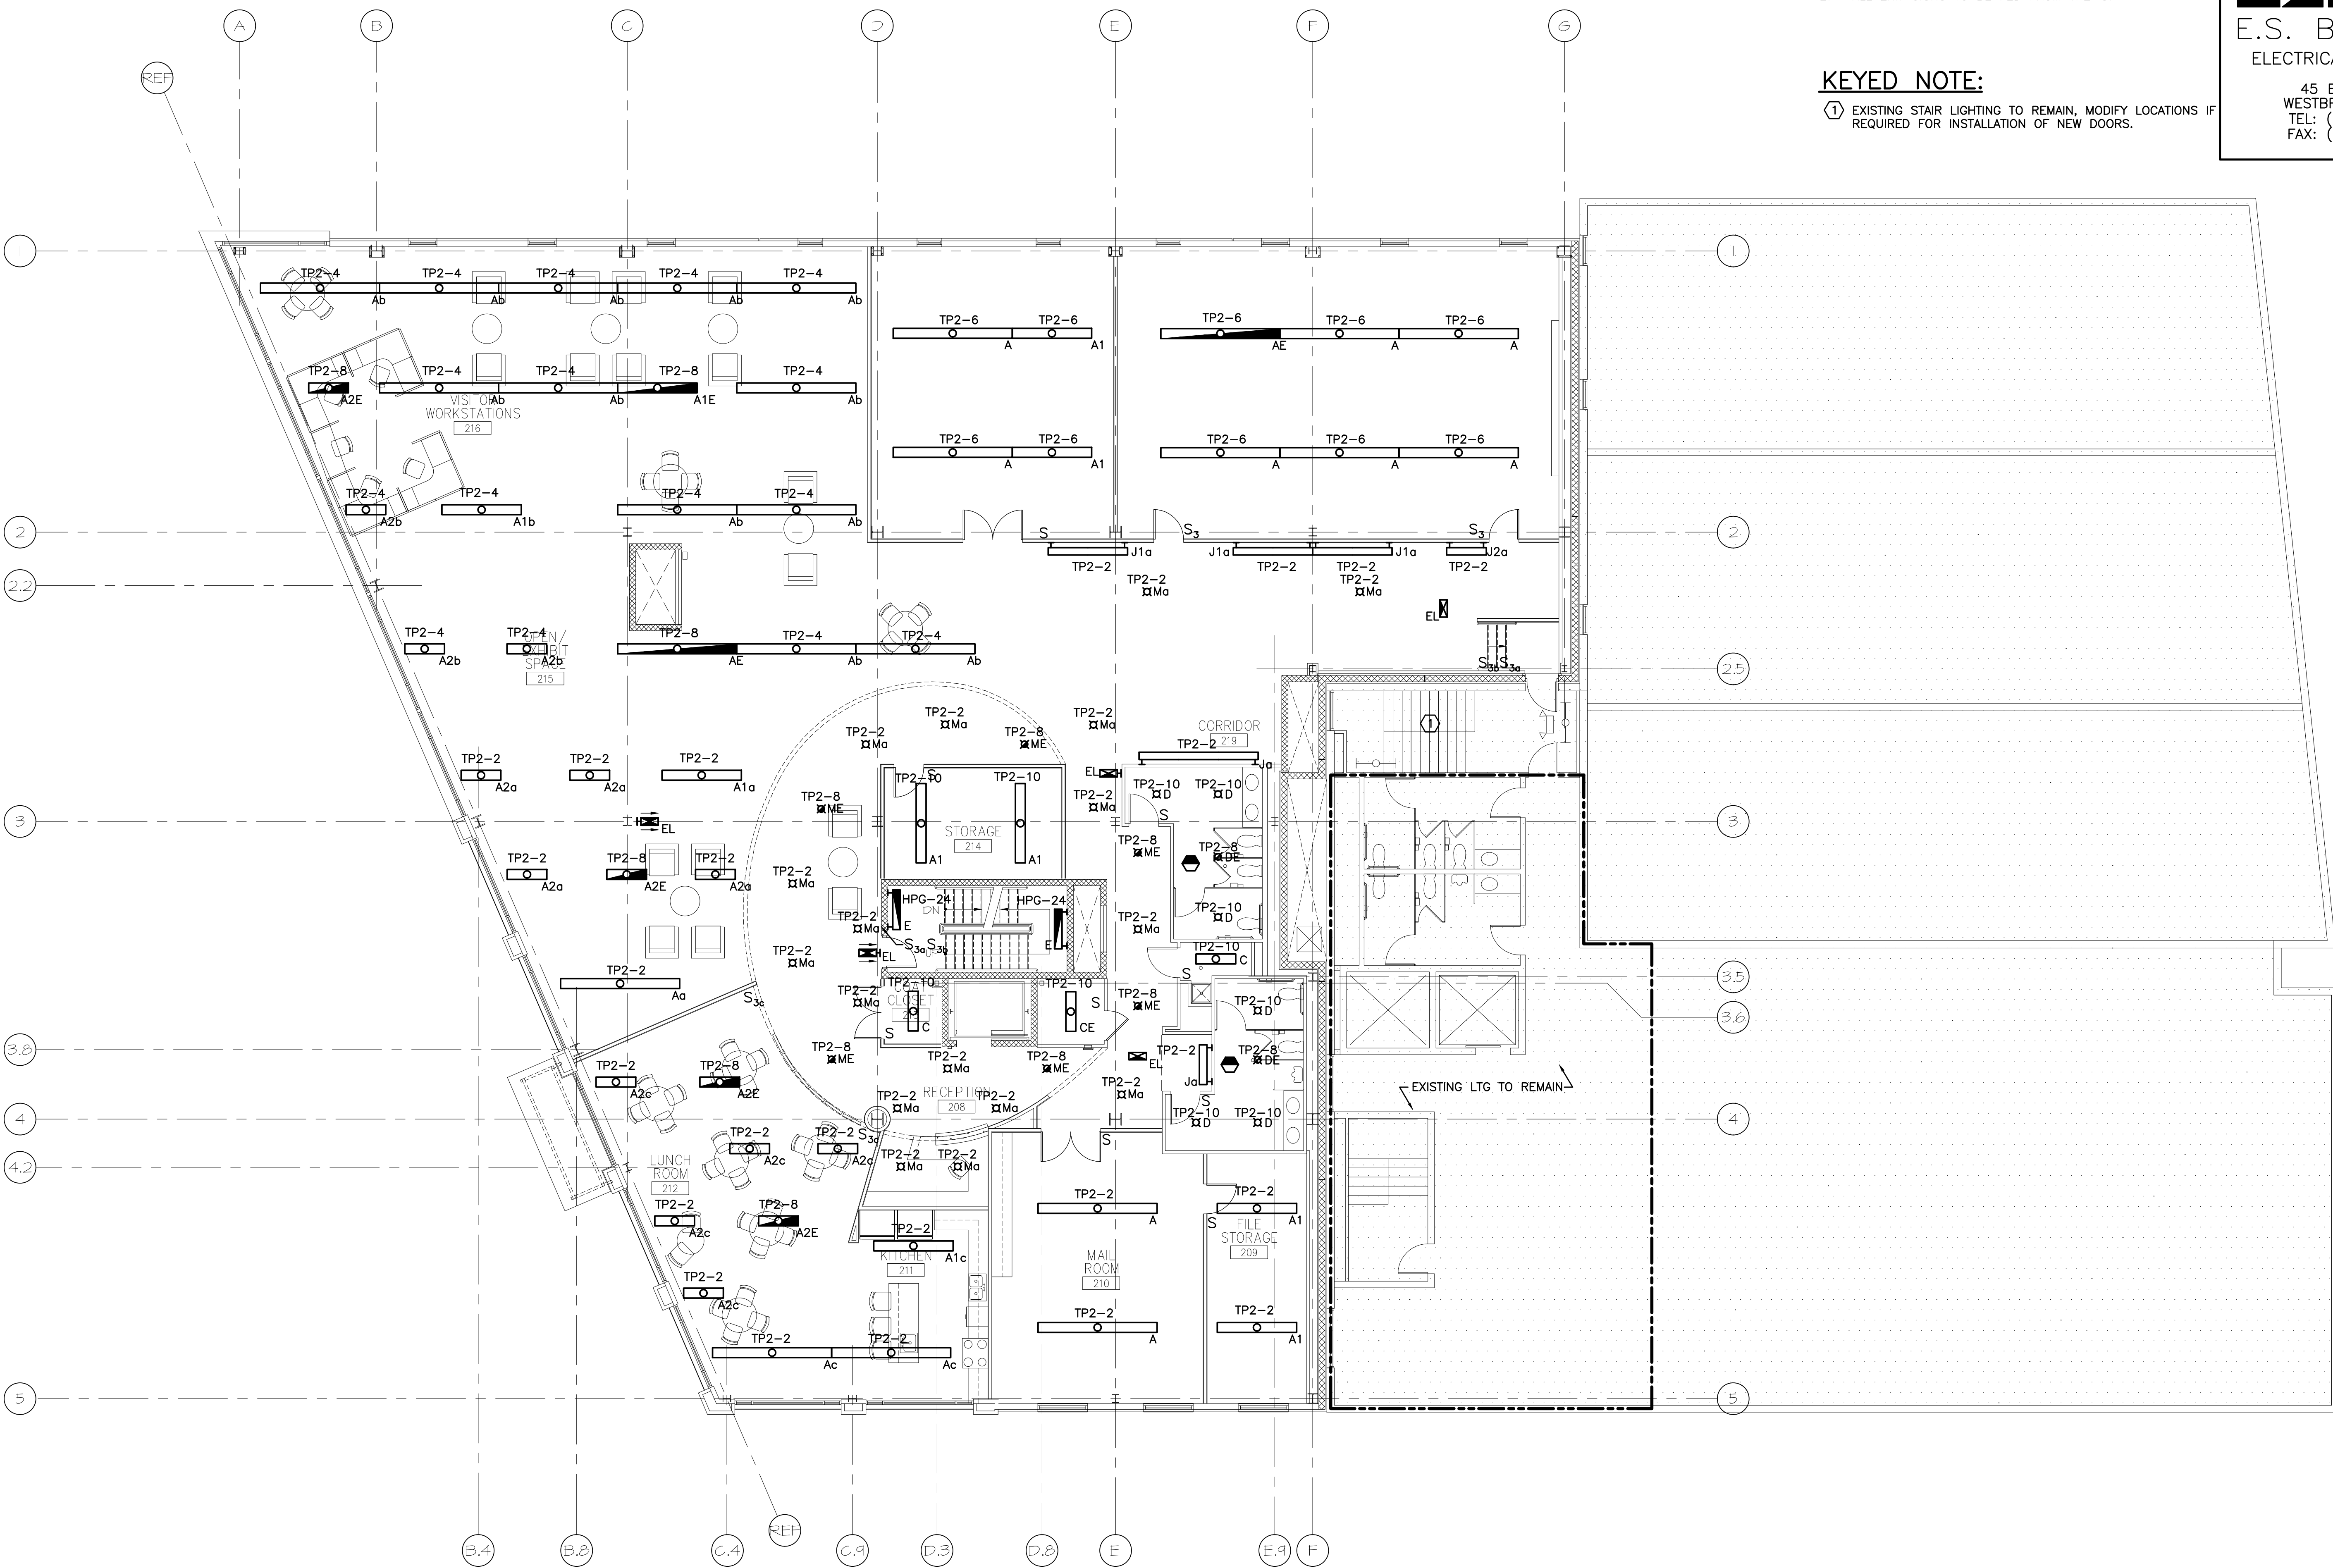

PROJECT TITLE: CUSTOM HOUSE SQUARE
 FORE STREET
 PORTLAND, MAINE
 RECORD DRAWINGS
 9-19-07
 3-5-07
 12-20-06
 9-19-07

REV	DESCRIPTION	DATE
2	RECORD DRAWINGS	9-19-07
1	ISSUED FOR REVISION	3-5-07
0	ISSUED FOR CONSTRUCTION	12-20-06

GRAPHIC SCALE:
 0" 1"
 SCALE: AS NOTED
 PROJECT MANAGER: DJT
 JC/DRAWN BY: CDS
 A/E OF RECORD: DJT
 CAD FILE: EL103-06068
 PROJECT NO: 06068
 DATE: 12-20-06
 SHEET TITLE:

A1 SECOND FLOOR PLAN

1/8"=1'-0"

SECOND FLOOR LIGHTING PLAN
 SHEET No. EL103
 © copyright 2006 ESB, Inc.