

NOTE:

1. SEE SHEET E-001 FOR LEGEND AND GENERAL NOTES.

KEYED NOTE:


① EXISTING STAIR LIGHTING TO REMAIN, MODIFY LOCATIONS IF REQUIRED FOR INSTALLATION OF NEW DOORS.

ESB
E.S. BOULOS CO
 ELECTRICAL CONTRACTORS

45 BRADLEY DRIVE
 WESTBROOK, ME 04092
 TEL: (207) 464-3706
 FAX: (207) 464-1833

SMRT

ARCHITECTURE ENGINEERING PLANNING
 SMART
 144 Fore Street/P.O. Box 618
 Portland, Maine 04104
 tel. (207) 775-3846
 fax. (207) 775-1070

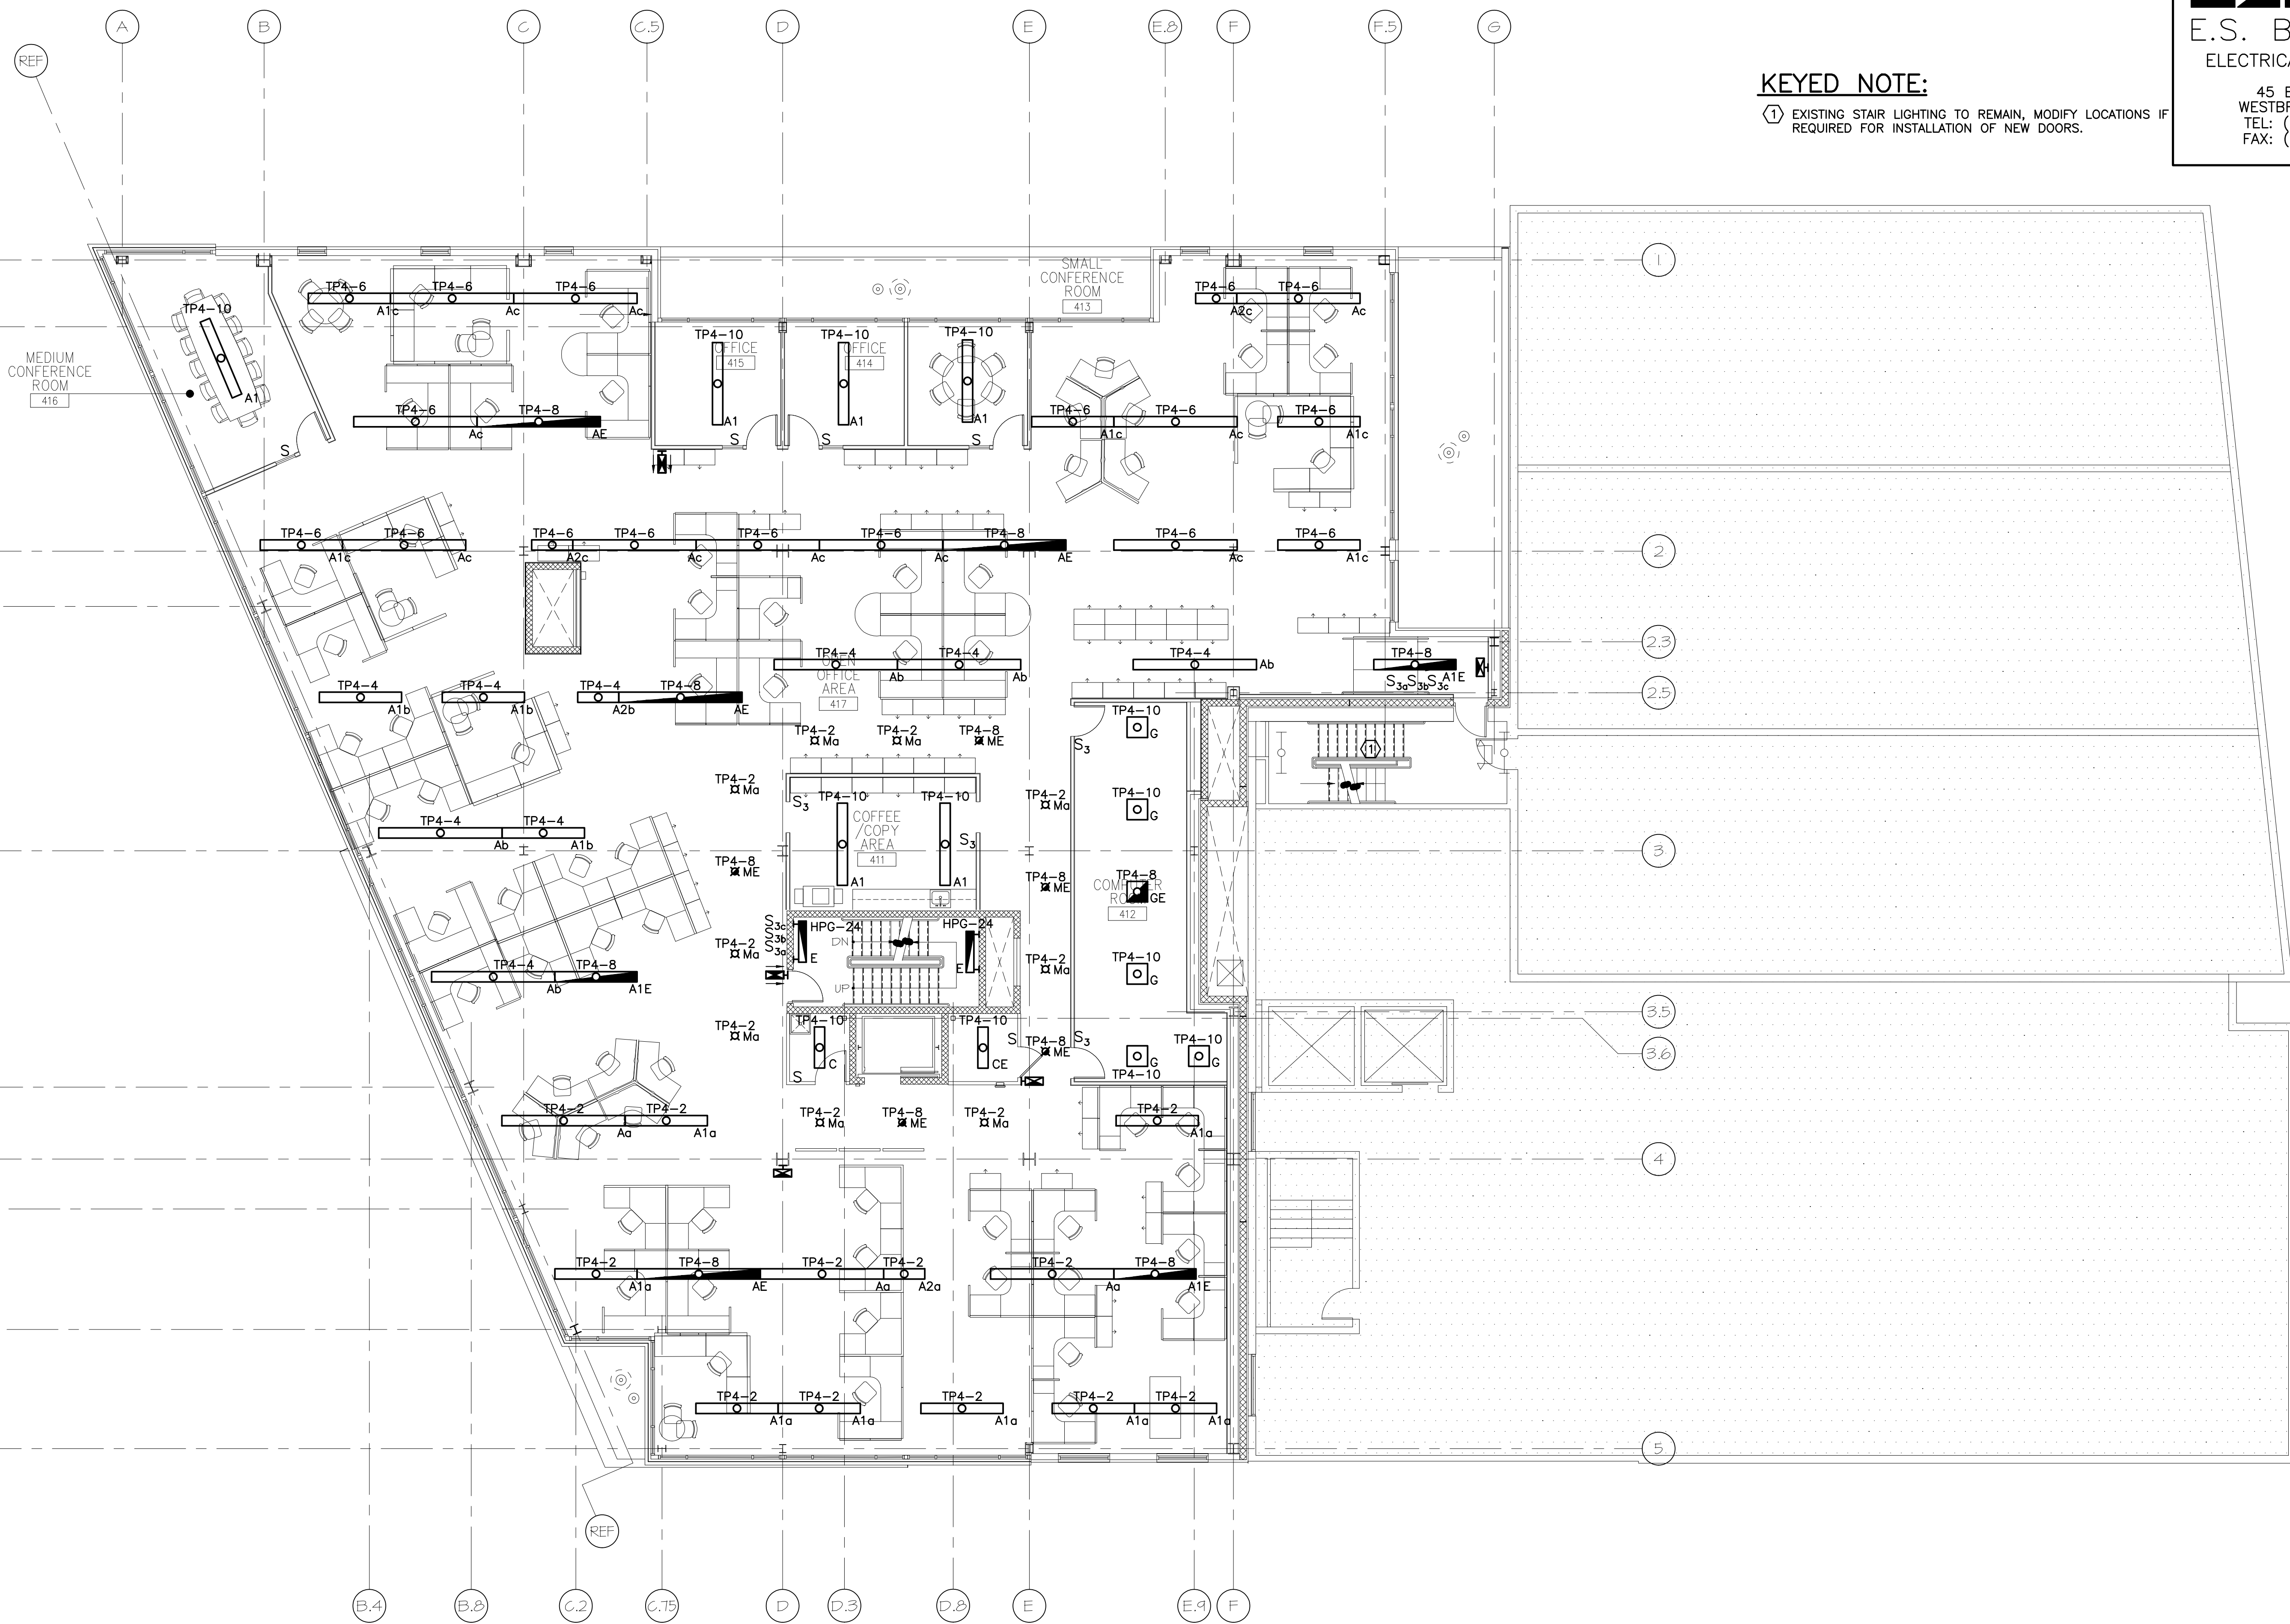

PROJECT TITLE: CUSTOM HOUSE SQUARE FORE STREET PORTLAND, MAINE

CURRENT ISSUE STATUS: RECORD DRAWINGS 9-19-07
 ISSUED FOR REVISION 3-5-07
 ISSUED FOR CONSTRUCTION 12-20-06

REV	DESCRIPTION	DATE
2	RECORD DRAWINGS	9-19-07
1	ISSUED FOR REVISION	3-5-07
0	ISSUED FOR CONSTRUCTION	12-20-06

GRAPHIC SCALE: 0" 1"

SCALE: AS NOTED

PROJECT MANAGER: DJT

JC/DRAWN BY: CDS

A/E OF RECORD: DJT

CAD FILE: EL105-06068

PROJECT NO: 06068

DATE: 12-20-06

SHEET TITLE: FOURTH FLOOR LIGHTING PLAN

A1 FOURTH FLOOR PLAN

1/8"=1'-0"

SHEET No. EL105