

NOTE:

1. SEE SHEET E-001 FOR LEGEND AND GENERAL NOTES.

KEYED NOTE:


- ① MOUNT RECEPTACLE 42" AFF TO BOTTOM OF DEVICE.
- ② RELOCATE DISCONNECTS FOR CONDENSING UNITS AND EXTEND WIRING TO NEW LOCATIONS AS REQUIRED. COORDINATE ALL WORK W/ MECHANICAL CONTRACTOR.
- ③ PROVIDE POWER FOR ELECTRIC SIGN BOARD.

ESB
E.S. BOULOS CO
 ELECTRICAL CONTRACTORS

45 BRADLEY DRIVE
 WESTBROOK, ME 04092
 TEL: (207) 464-3706
 FAX: (207) 464-1833

SMT
RT

ARCHITECTURE ENGINEERING PLANNING
 SWRT
 144 Fore Street/P.O. Box 618
 Portland, Maine 04104
 tel. (207) 775-3846
 fax. (207) 775-1070

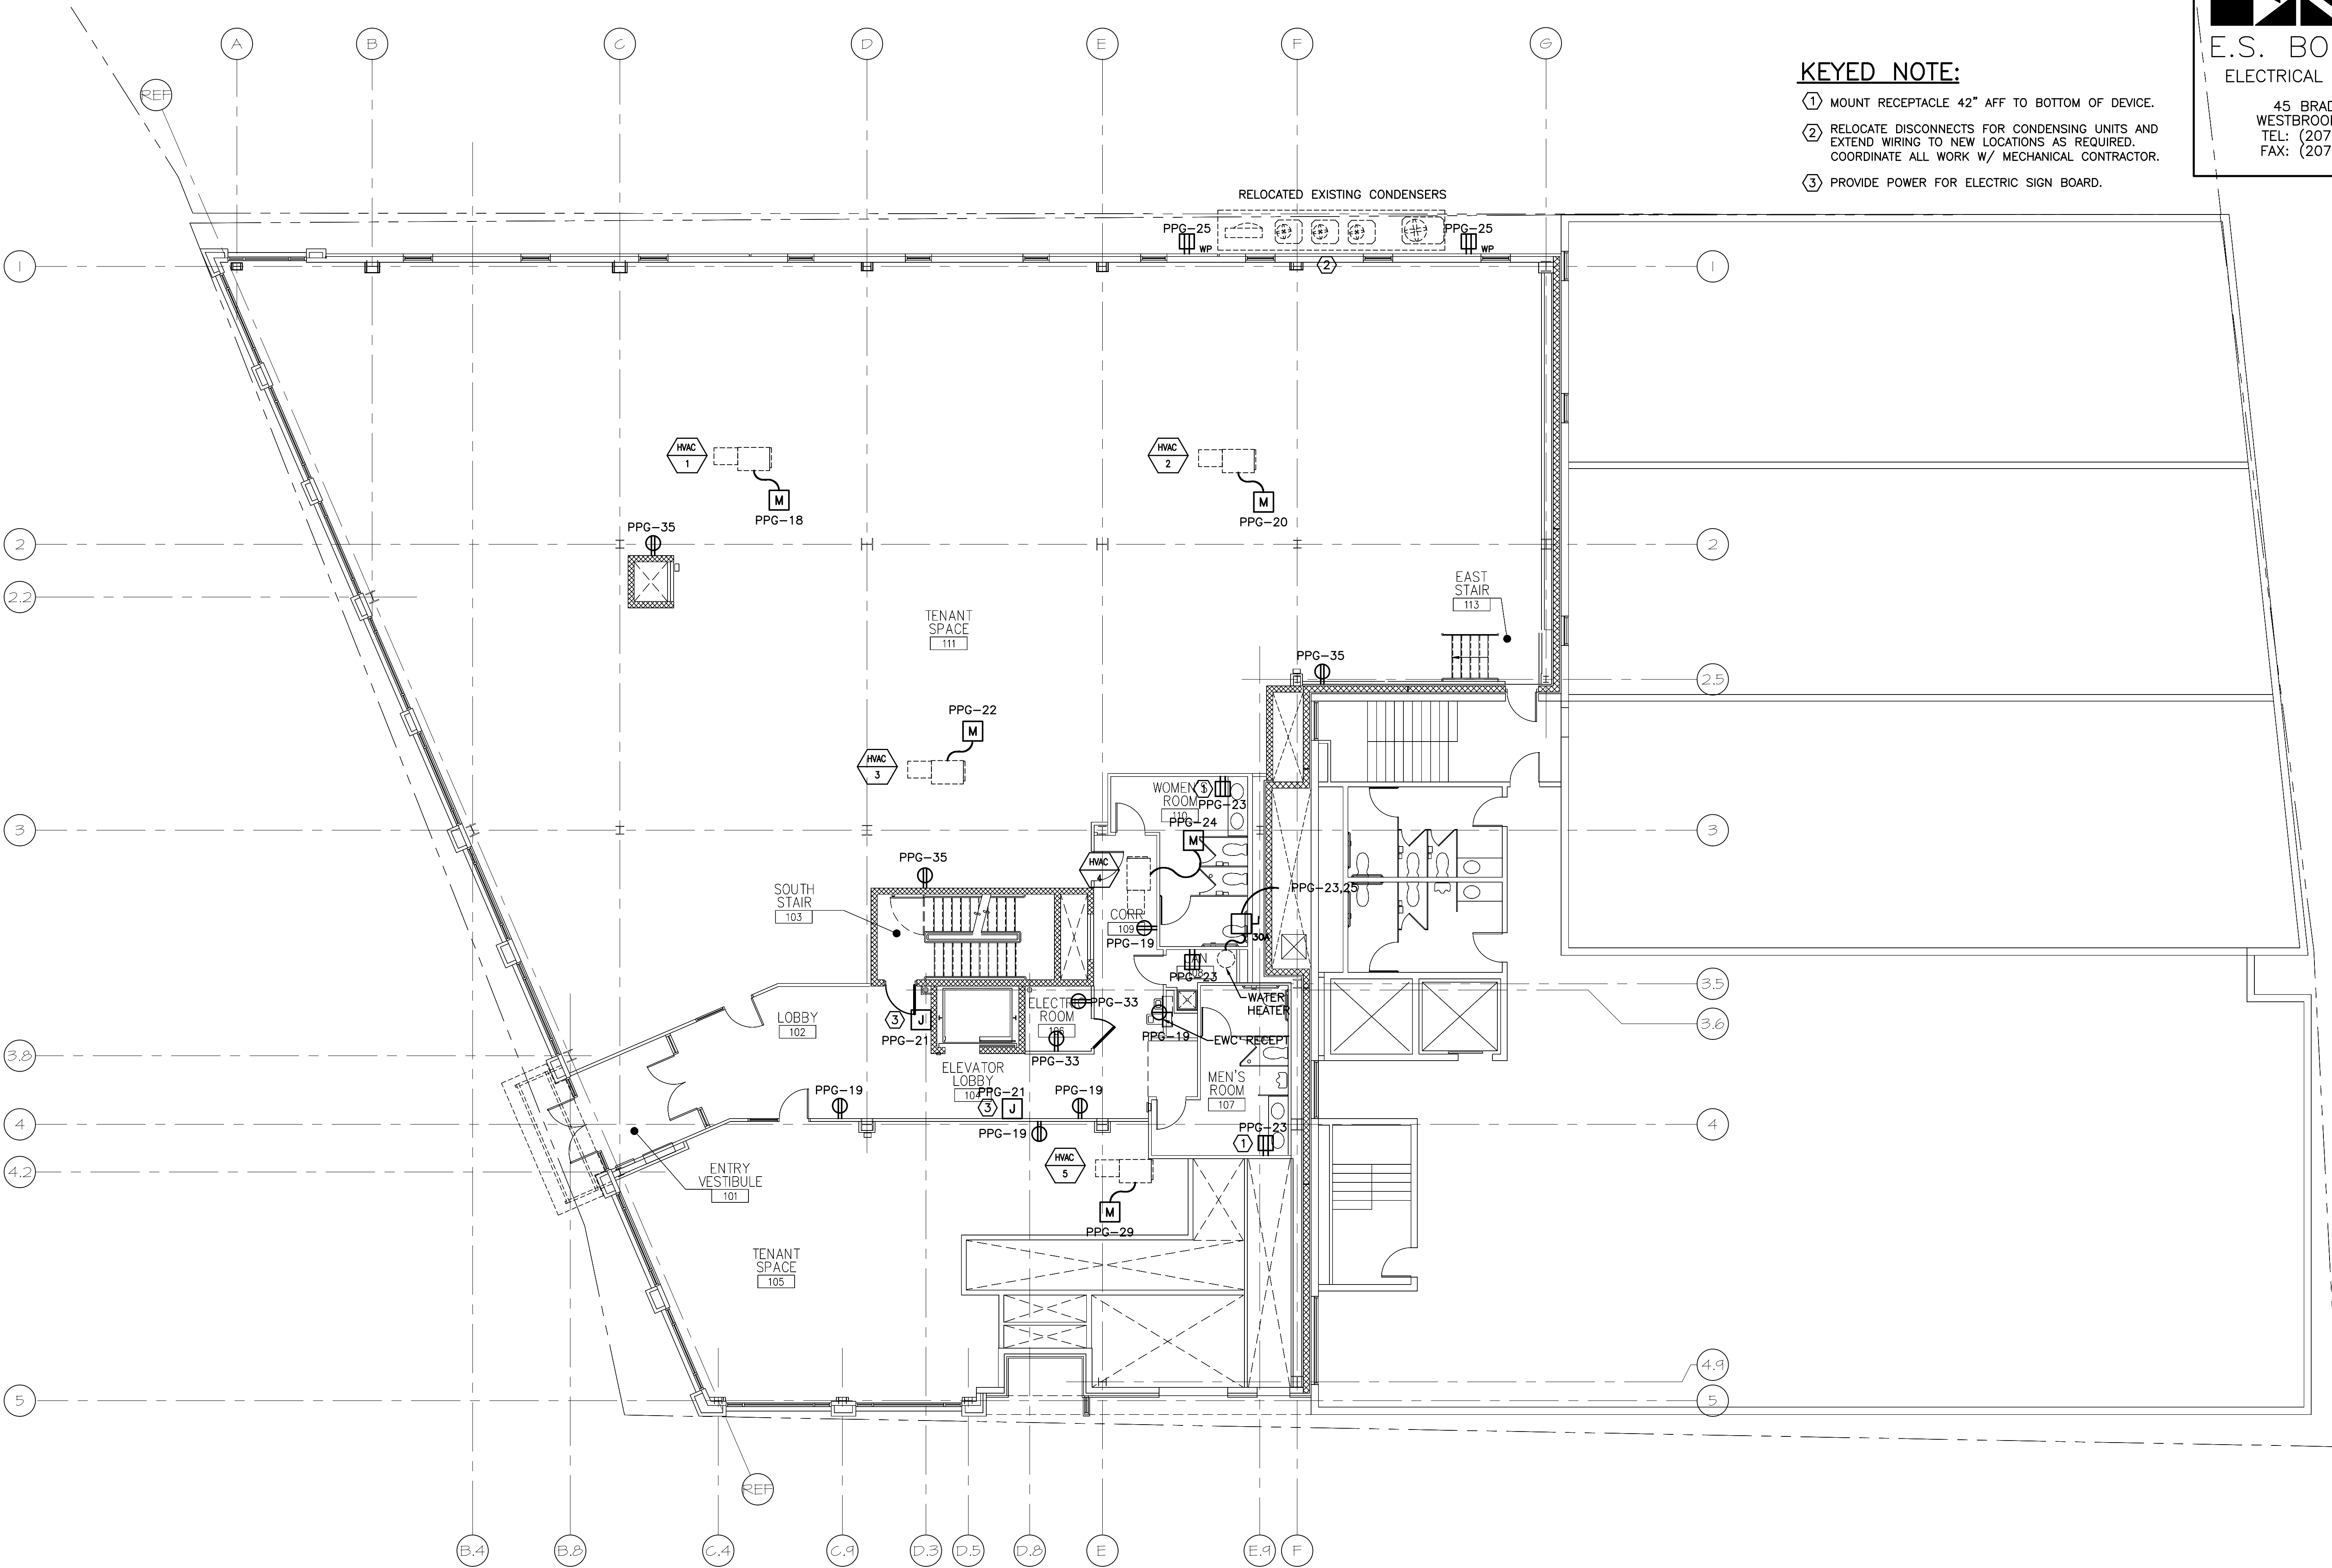

PROJECT TITLE: **CUSTOM HOUSE SQUARE FORE STREET**
 PORTLAND, MAINE

CURRENT ISSUE STATUS: **RECORD DRAWINGS 9-19-07**

REV	DESCRIPTION	DATE
2	RECORD DRAWINGS	9-19-07
1	ISSUED FOR REVISION	3-5-07
0	ISSUED FOR CONSTRUCTION	12-20-06

GRAPHIC SCALE: 0" = 1"

SCALE: AS NOTED

PROJECT MANAGER: DJT

JC/DRAWN BY: CDS

A/E OF RECORD: DJT

CAD FILE: EP102-06068

PROJECT NO: 06068

DATE: 12-20-06

SHEET TITLE: **FIRST FLOOR POWER PLAN**

SHEET No. **EP102**

A1 FIRST FLOOR PLAN

1/8"=1'-0"