


**NOTE:**

1. SEE SHEET E-001 FOR LEGEND AND GENERAL NOTES.

**ESB**  
**E.S. BOULOS CO**  
 ELECTRICAL CONTRACTORS  
 45 BRADLEY DRIVE  
 WESTBROOK, ME 04092  
 TEL: (207) 464-3706  
 FAX: (207) 464-1833

**SMT**  
**RT**  
 ARCHITECTURE ENGINEERING PLANNING  
 SWRT  
 144 Fore Street/P.O. Box 618  
 Portland, Maine 04104  
 tel. (207) 775-3846  
 fax. (207) 775-1070

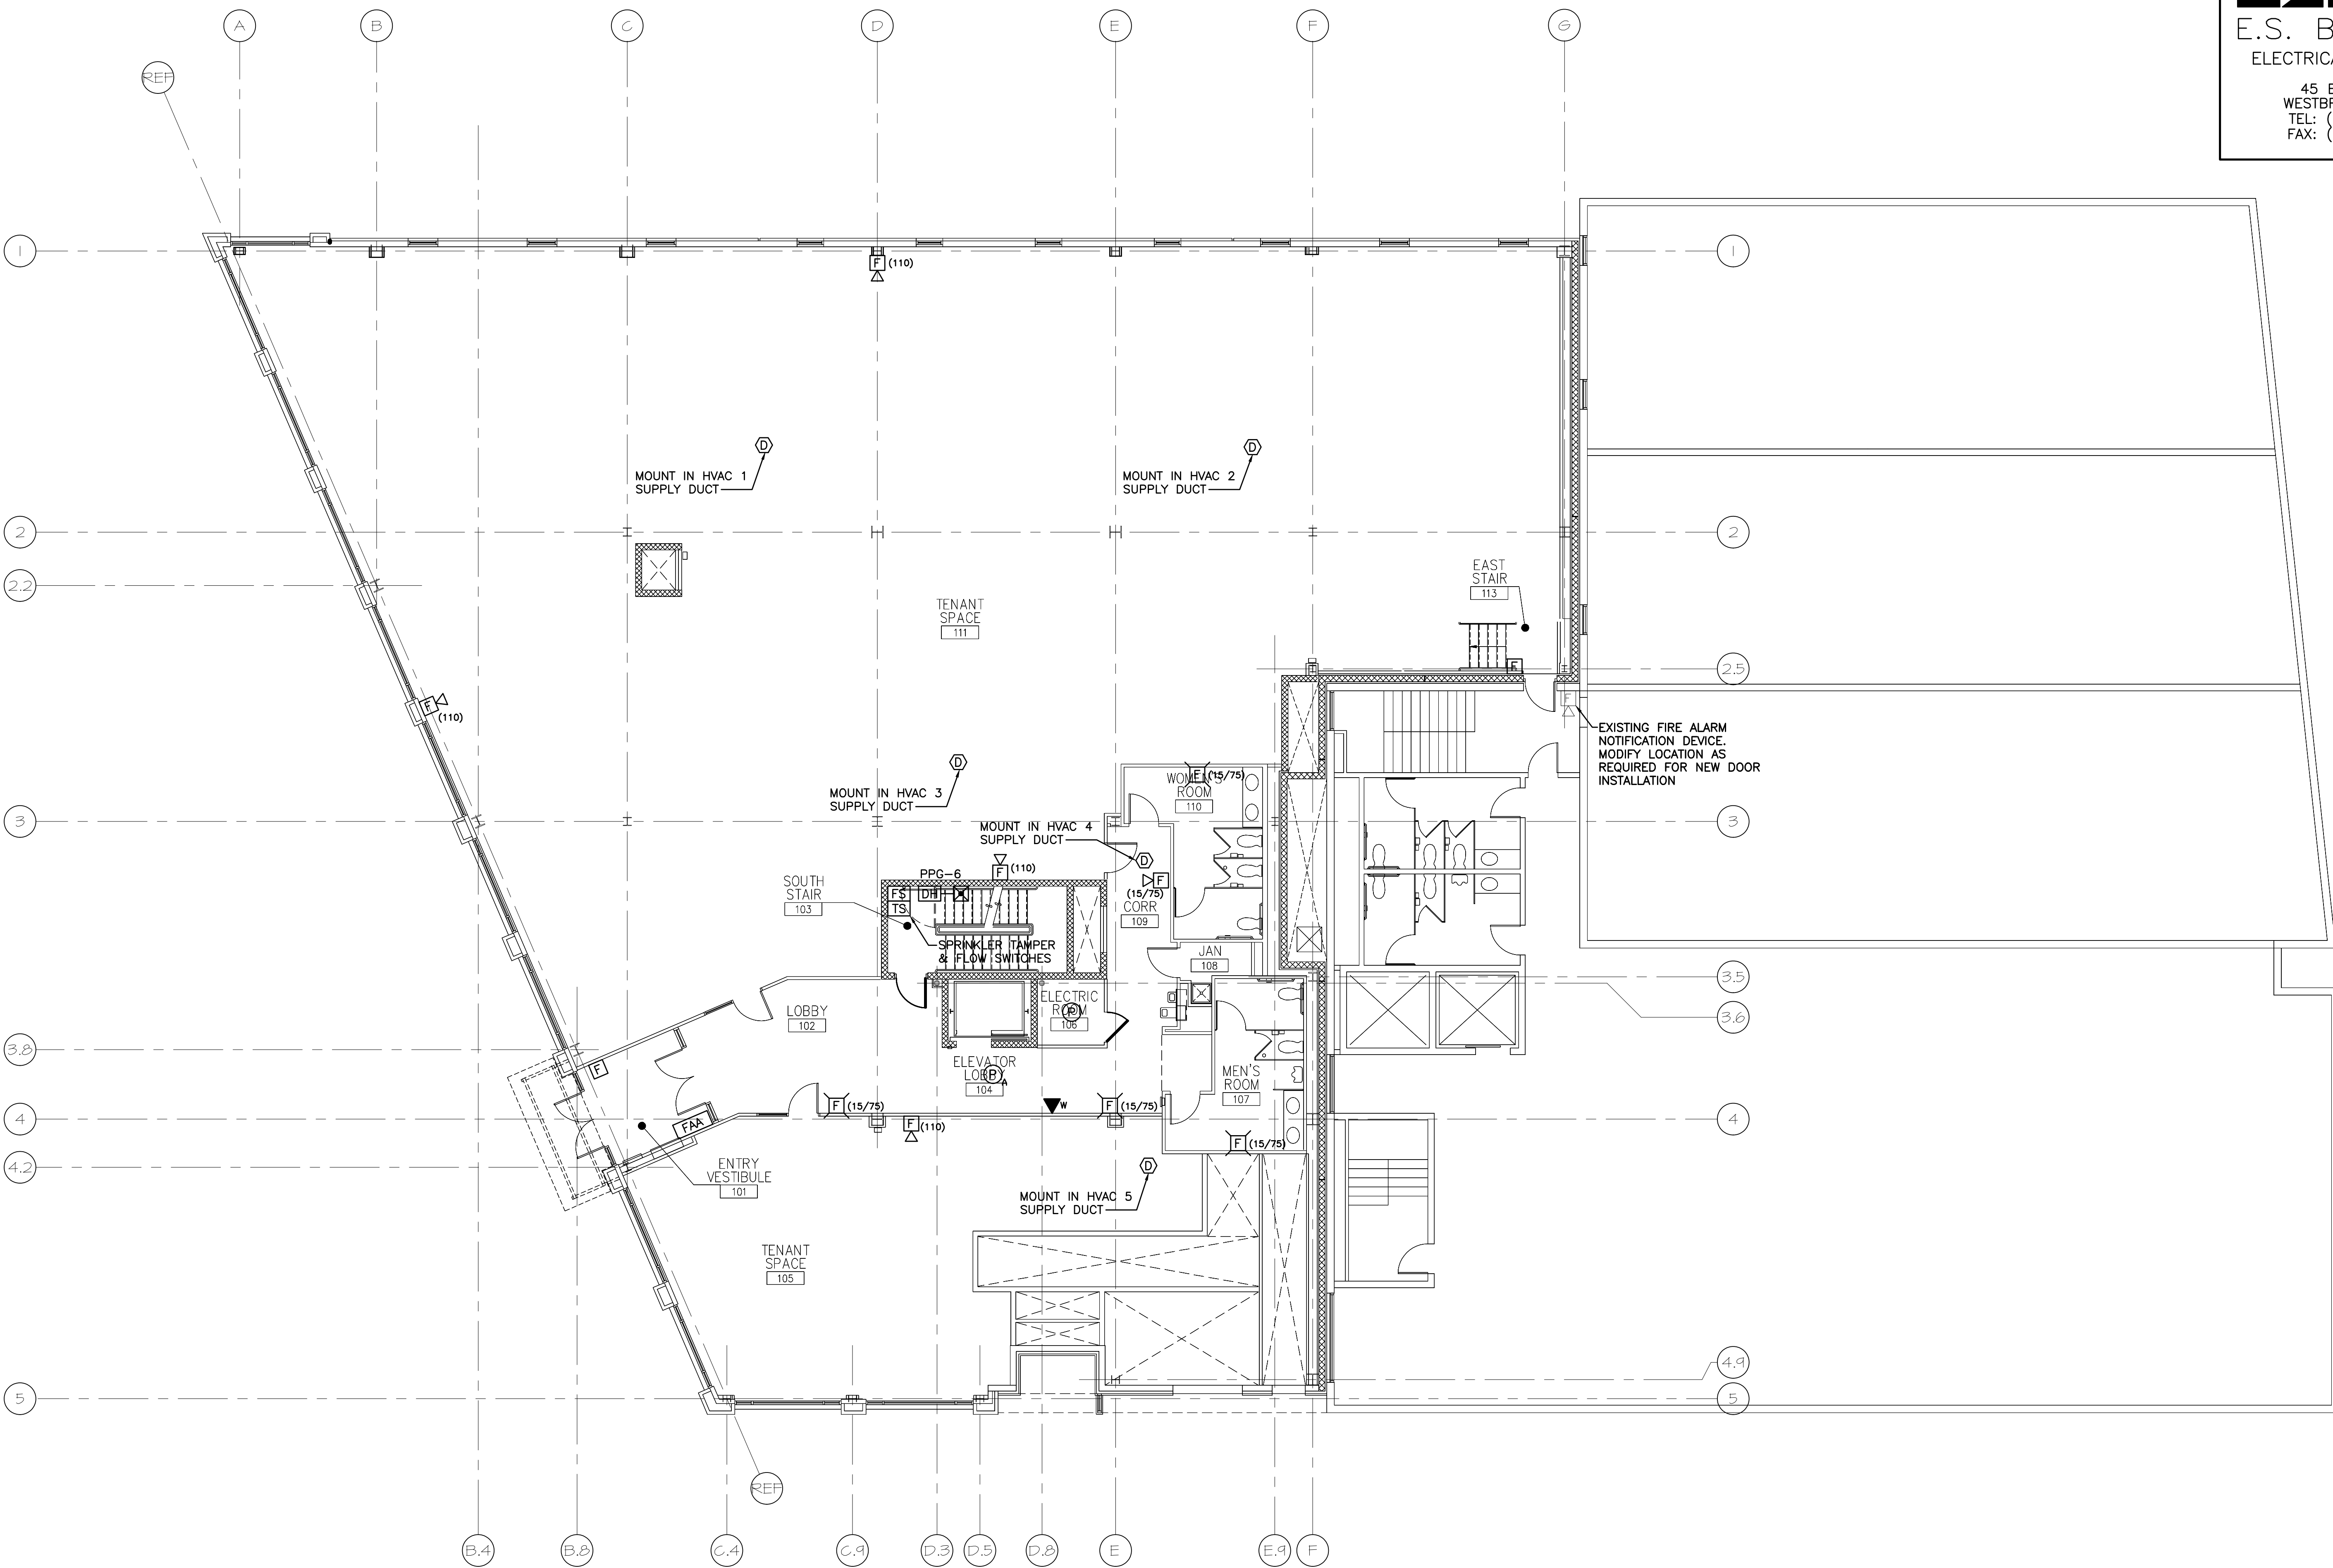

CUSTOM HOUSE SQUARE  
 FORE STREET  
 PORTLAND, MAINE

RECORD DRAWINGS  
 9-19-07  
 ISSUED FOR REVISION  
 3-5-07  
 ISSUED FOR CONSTRUCTION  
 12-20-06

REV	DESCRIPTION	DATE
2	RECORD DRAWINGS	9-19-07
1	ISSUED FOR REVISION	3-5-07
0	ISSUED FOR CONSTRUCTION	12-20-06

GRAPHIC SCALE:  
 0" 1"  
 SCALE: AS NOTED  
 PROJECT MANAGER: DJT  
 JC/DRAWN BY: CDS  
 A/E OF RECORD: DJT  
 CAD FILE: EY102-06068  
 PROJECT NO: 06068  
 DATE: 12-20-06

SHEET TITLE:  
**FIRST FLOOR  
 SYSTEMS PLAN**  
 SHEET No.  
**EY102**

**A1** FIRST FLOOR PLAN

1/8"=1'-0"