


**NOTE:**

- SEE SHEET E-001 FOR LEGEND AND GENERAL NOTES.
- PROVIDE EMPTY OUTLET BOX AND 3/4" CONDUIT W/PULL STRING TO ABOVE AN ACCESSIBLE CEILING FOR ALL TELECOMMUNICATIONS DEVICES SHOWN. TELECOMMUNICATIONS WIRING TO BE BY OWNER.

**KEYED NOTE:**

- PROVIDE SLEEVE IN FLOOR SLAB AT LOCATIONS SHOWN FOR MODULAR FURNITURE TELECOMMUNICATIONS WIRING TO BE INSTALLED BY OWNER.
- PROVIDE JUNCTION BOX AND 1" CONDUIT STUB UP, WALL MOUNTED ON COLUMN OR WALL AT LOCATIONS SHOWN FOR MODULAR FURNITURE TELECOMMUNICATIONS WIRING.

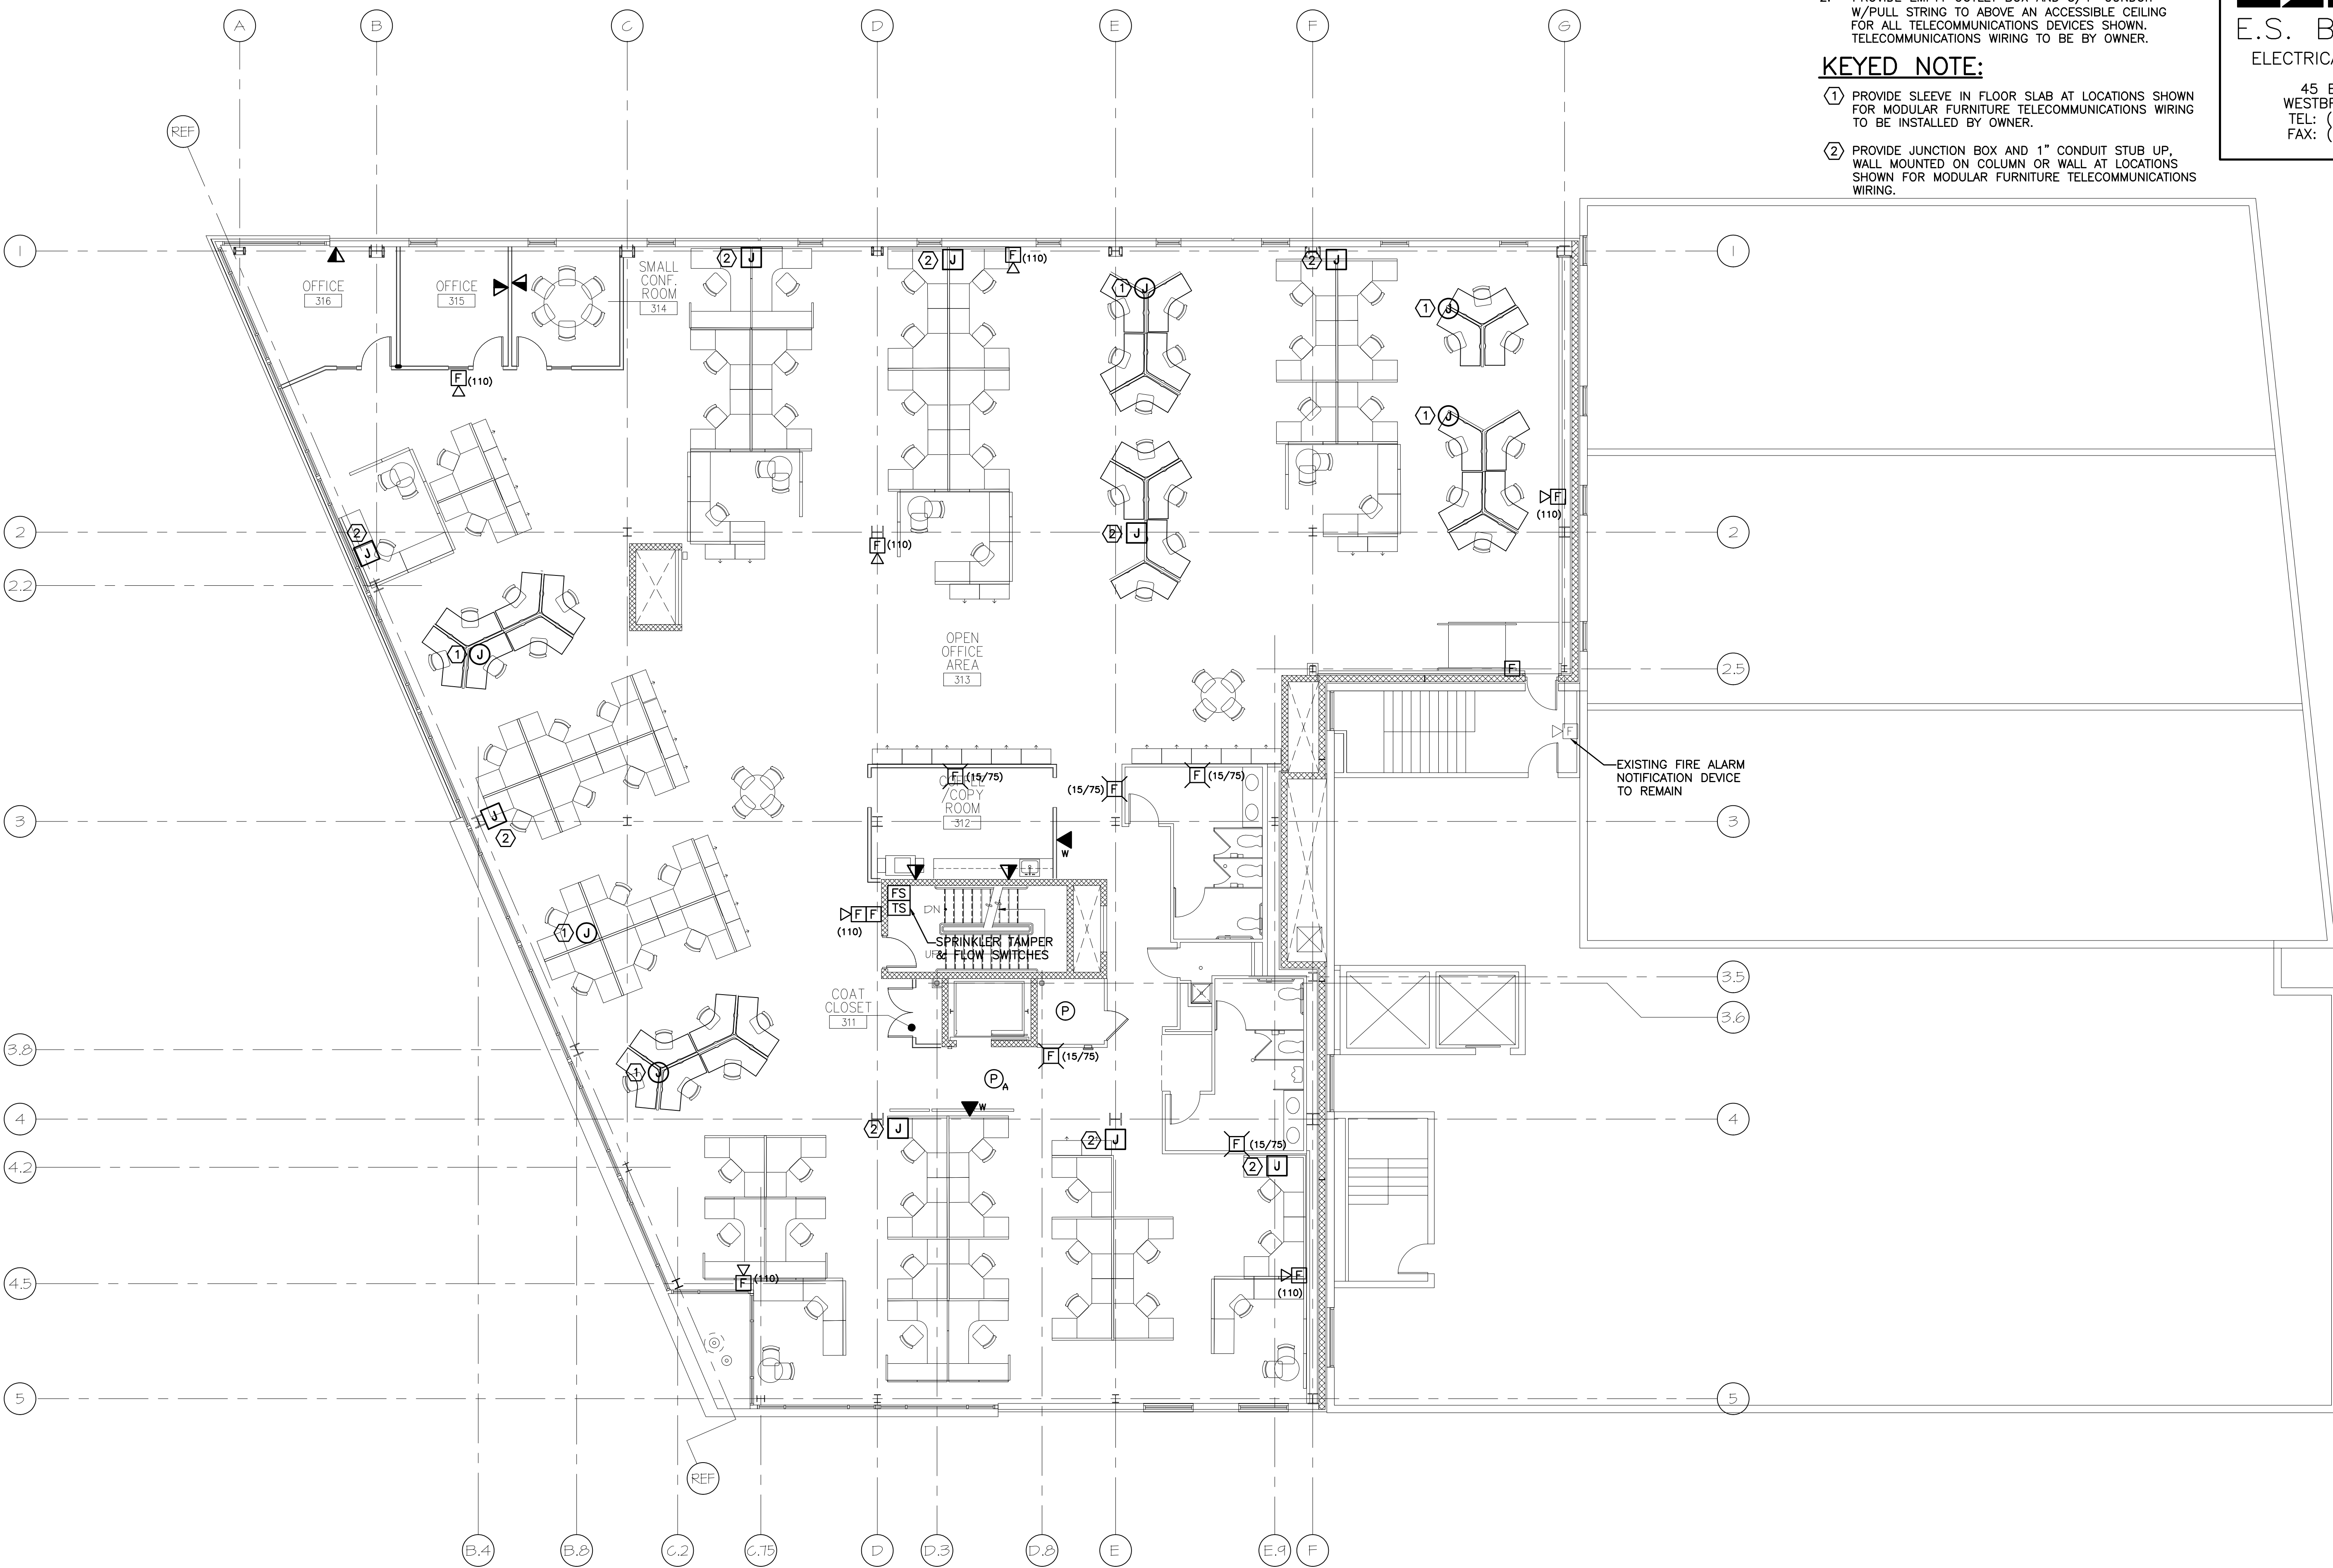

CUSTOM HOUSE SQUARE  
 FORE STREET  
 PORTLAND, MAINE

RECORD DRAWINGS  
 9-19-07

PROJECT TITLE: CUSTOM HOUSE SQUARE FORE STREET, PORTLAND, MAINE  
 CURRENT ISSUE STATUS: RECORD DRAWINGS 9-19-07  
 ISSUED FOR REVISION 3-5-07  
 ISSUED FOR CONSTRUCTION 12-20-06

REV	DESCRIPTION	DATE
2	RECORD DRAWINGS	9-19-07
1	ISSUED FOR REVISION	3-5-07
0	ISSUED FOR CONSTRUCTION	12-20-06

GRAPHIC SCALE: 0" 1"

SCALE: AS NOTED  
 PROJECT MANAGER: DJT  
 JC/DRAWN BY: CDS  
 A/E OF RECORD: DJT  
 CAD FILE: EY104-06068  
 PROJECT NO: 06068  
 DATE: 12-20-06

SHEET TITLE:  
**THIRD FLOOR SYSTEMS PLAN**

**A1** THIRD FLOOR PLAN

1/8"=1'-0"