


ENLARGED SHAFT PLAN

SCALE: 1/2" = 1'-0"

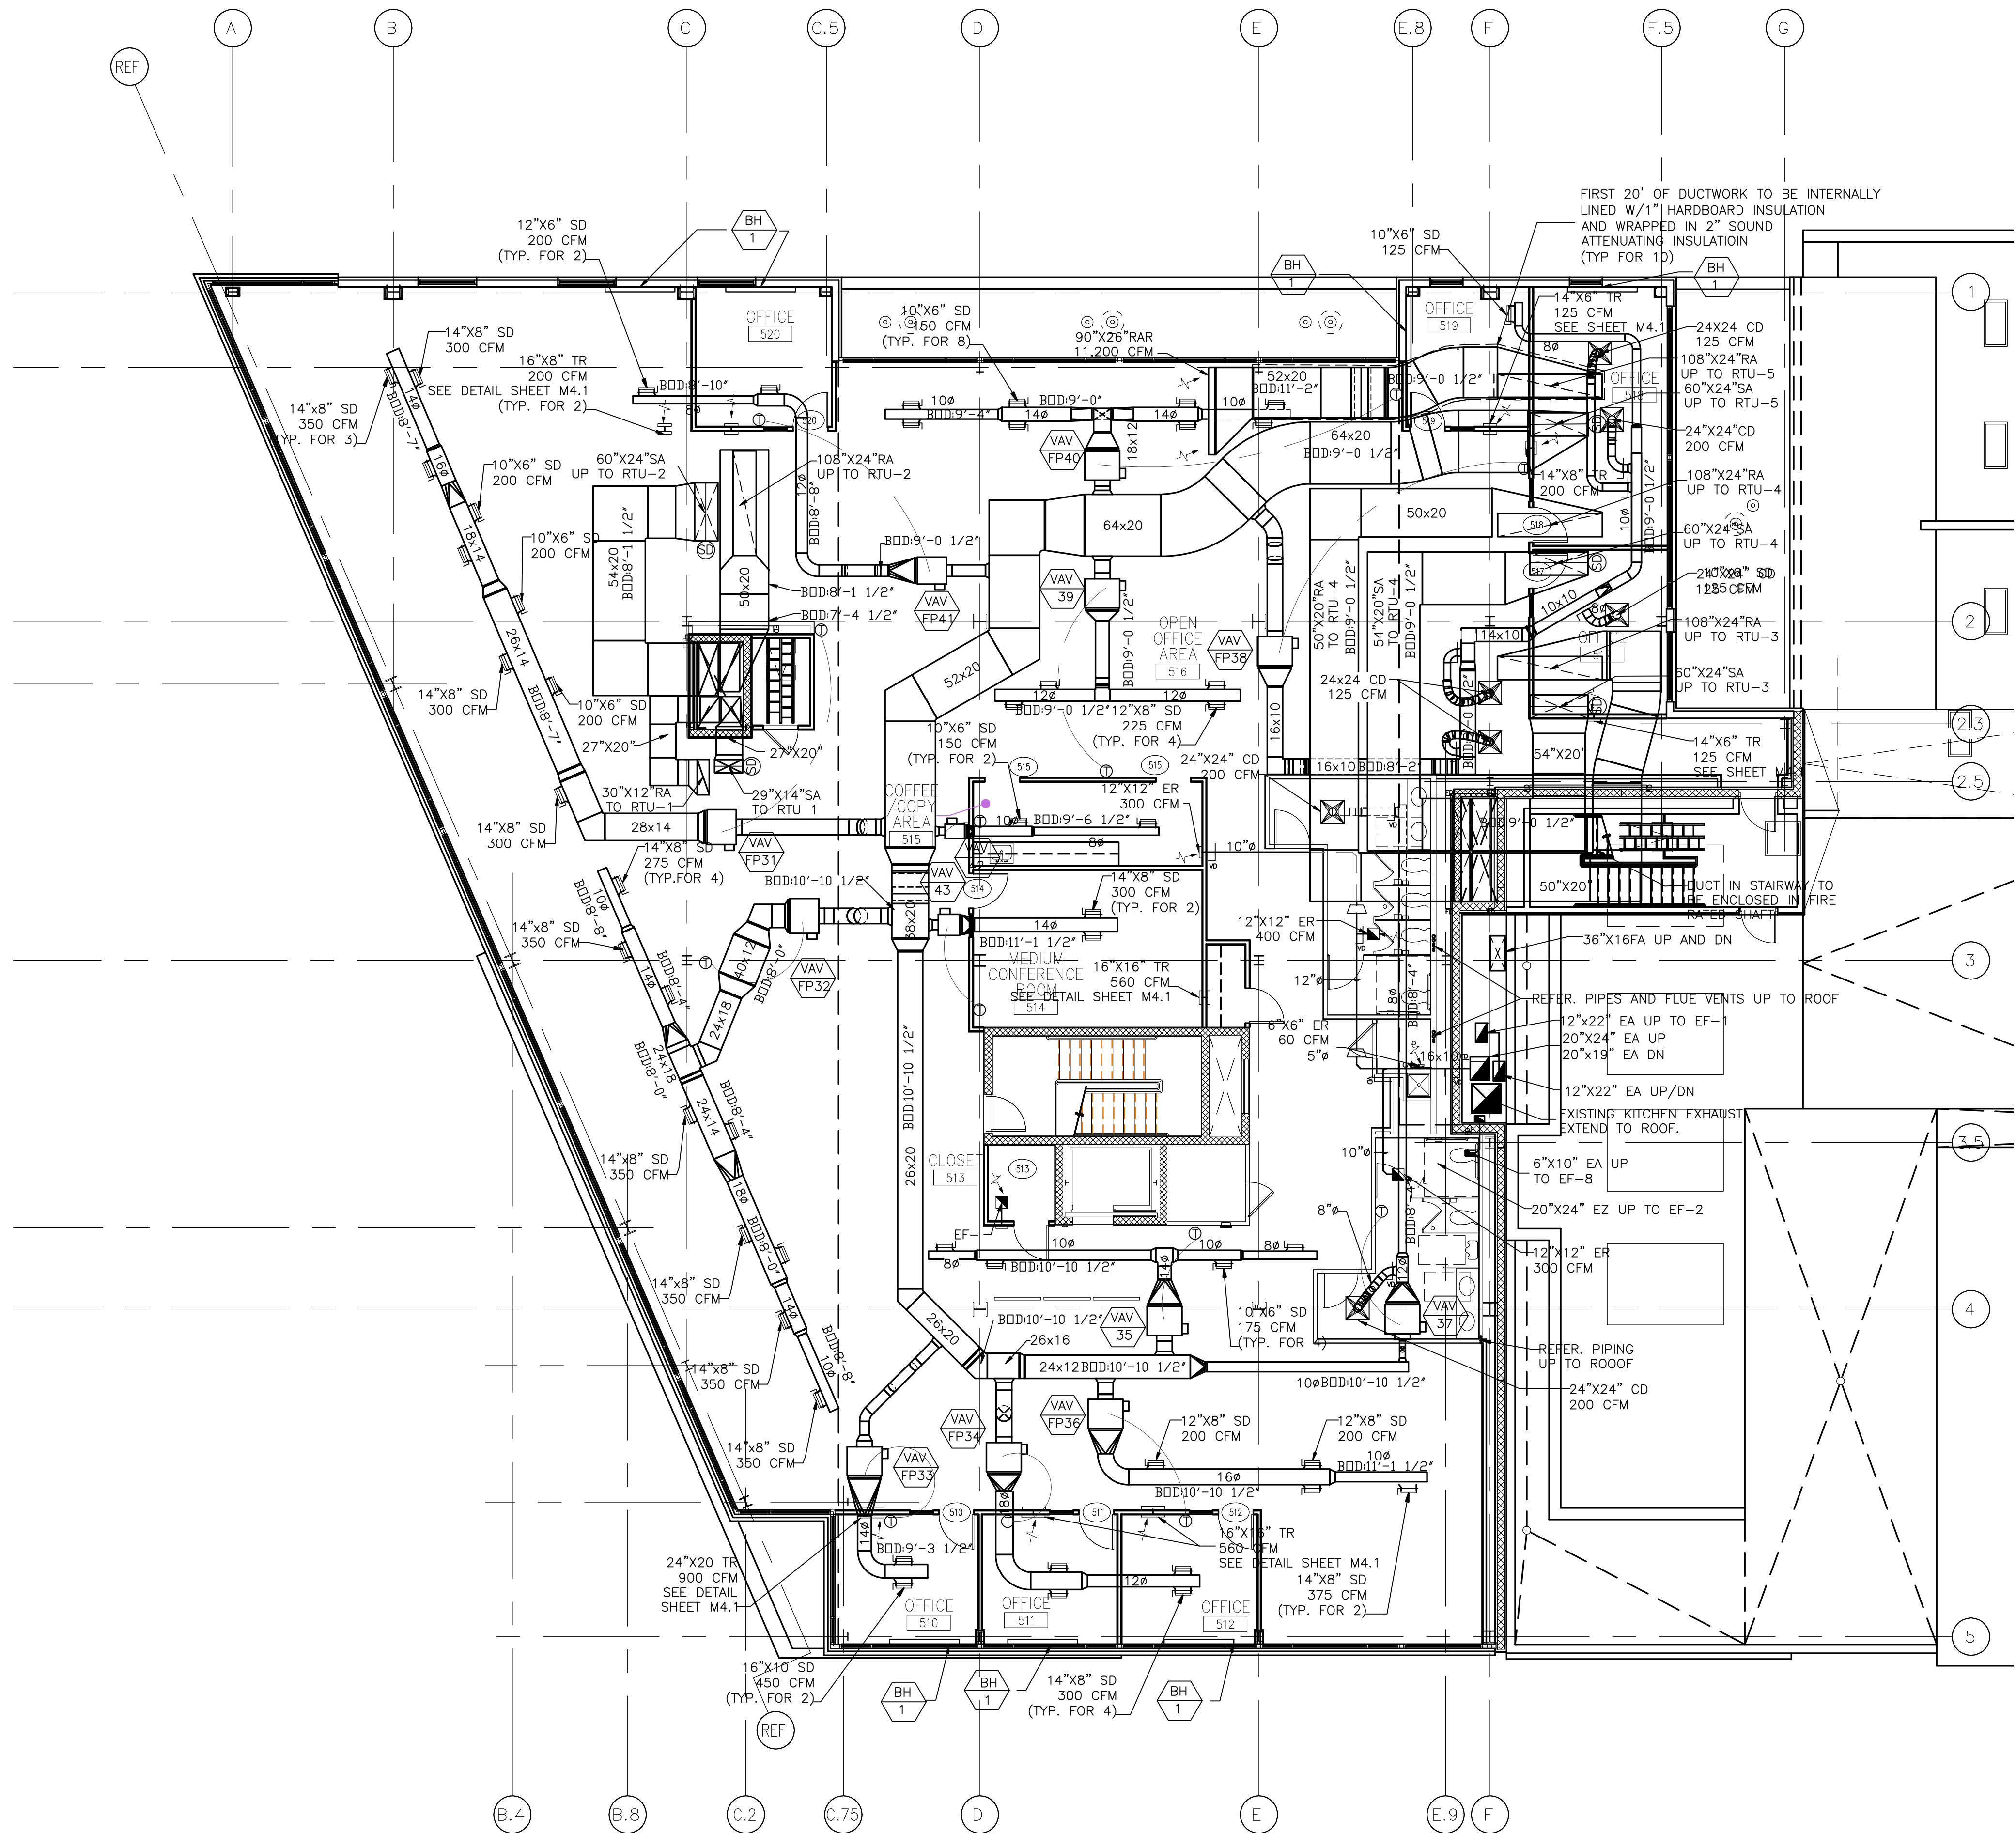

FIFTH FLOOR PLAN

SCALE: 1/8" = 1'-0"

AS BUILDS AS RECORDED BY ATLANTIC COMFORT SYSTEMS, INC.

INTEGRATED ENGINEERED SYSTEMS, INC.
 Δ MECH. DESIGN Δ ENERGY MGT. Δ INDOOR AIR QUALITY
 DURHAM, N.H. 03032
 P.O. BOX 657
 Tel: (603) 625-1346
 Fax: (603) 625-6466

Atlantic Comfort Systems, Inc.
 PO BOX 665-392 HILL STREET
 BIDDEFORD, MAINE 04005
 PHONE: (207) 284-6360
 FAX: (207) 284-6377

CUSTOM HOUSE SQUARE
 300 FORE STREET
 PORTLAND, MAINE
 FIFTH FLOOR HVAC PLAN

P.E.: JK D.B.: CPC
 PROJECT #: J493
 ISSUE DATE: SEPT. 19, 2007

M2.5

