


ENLARGED BATHROOM PLAN  
SCALE: 1/4" = 1'-0"




SECOND FLOOR PLAN  
SCALE: 1/8" = 1'-0"

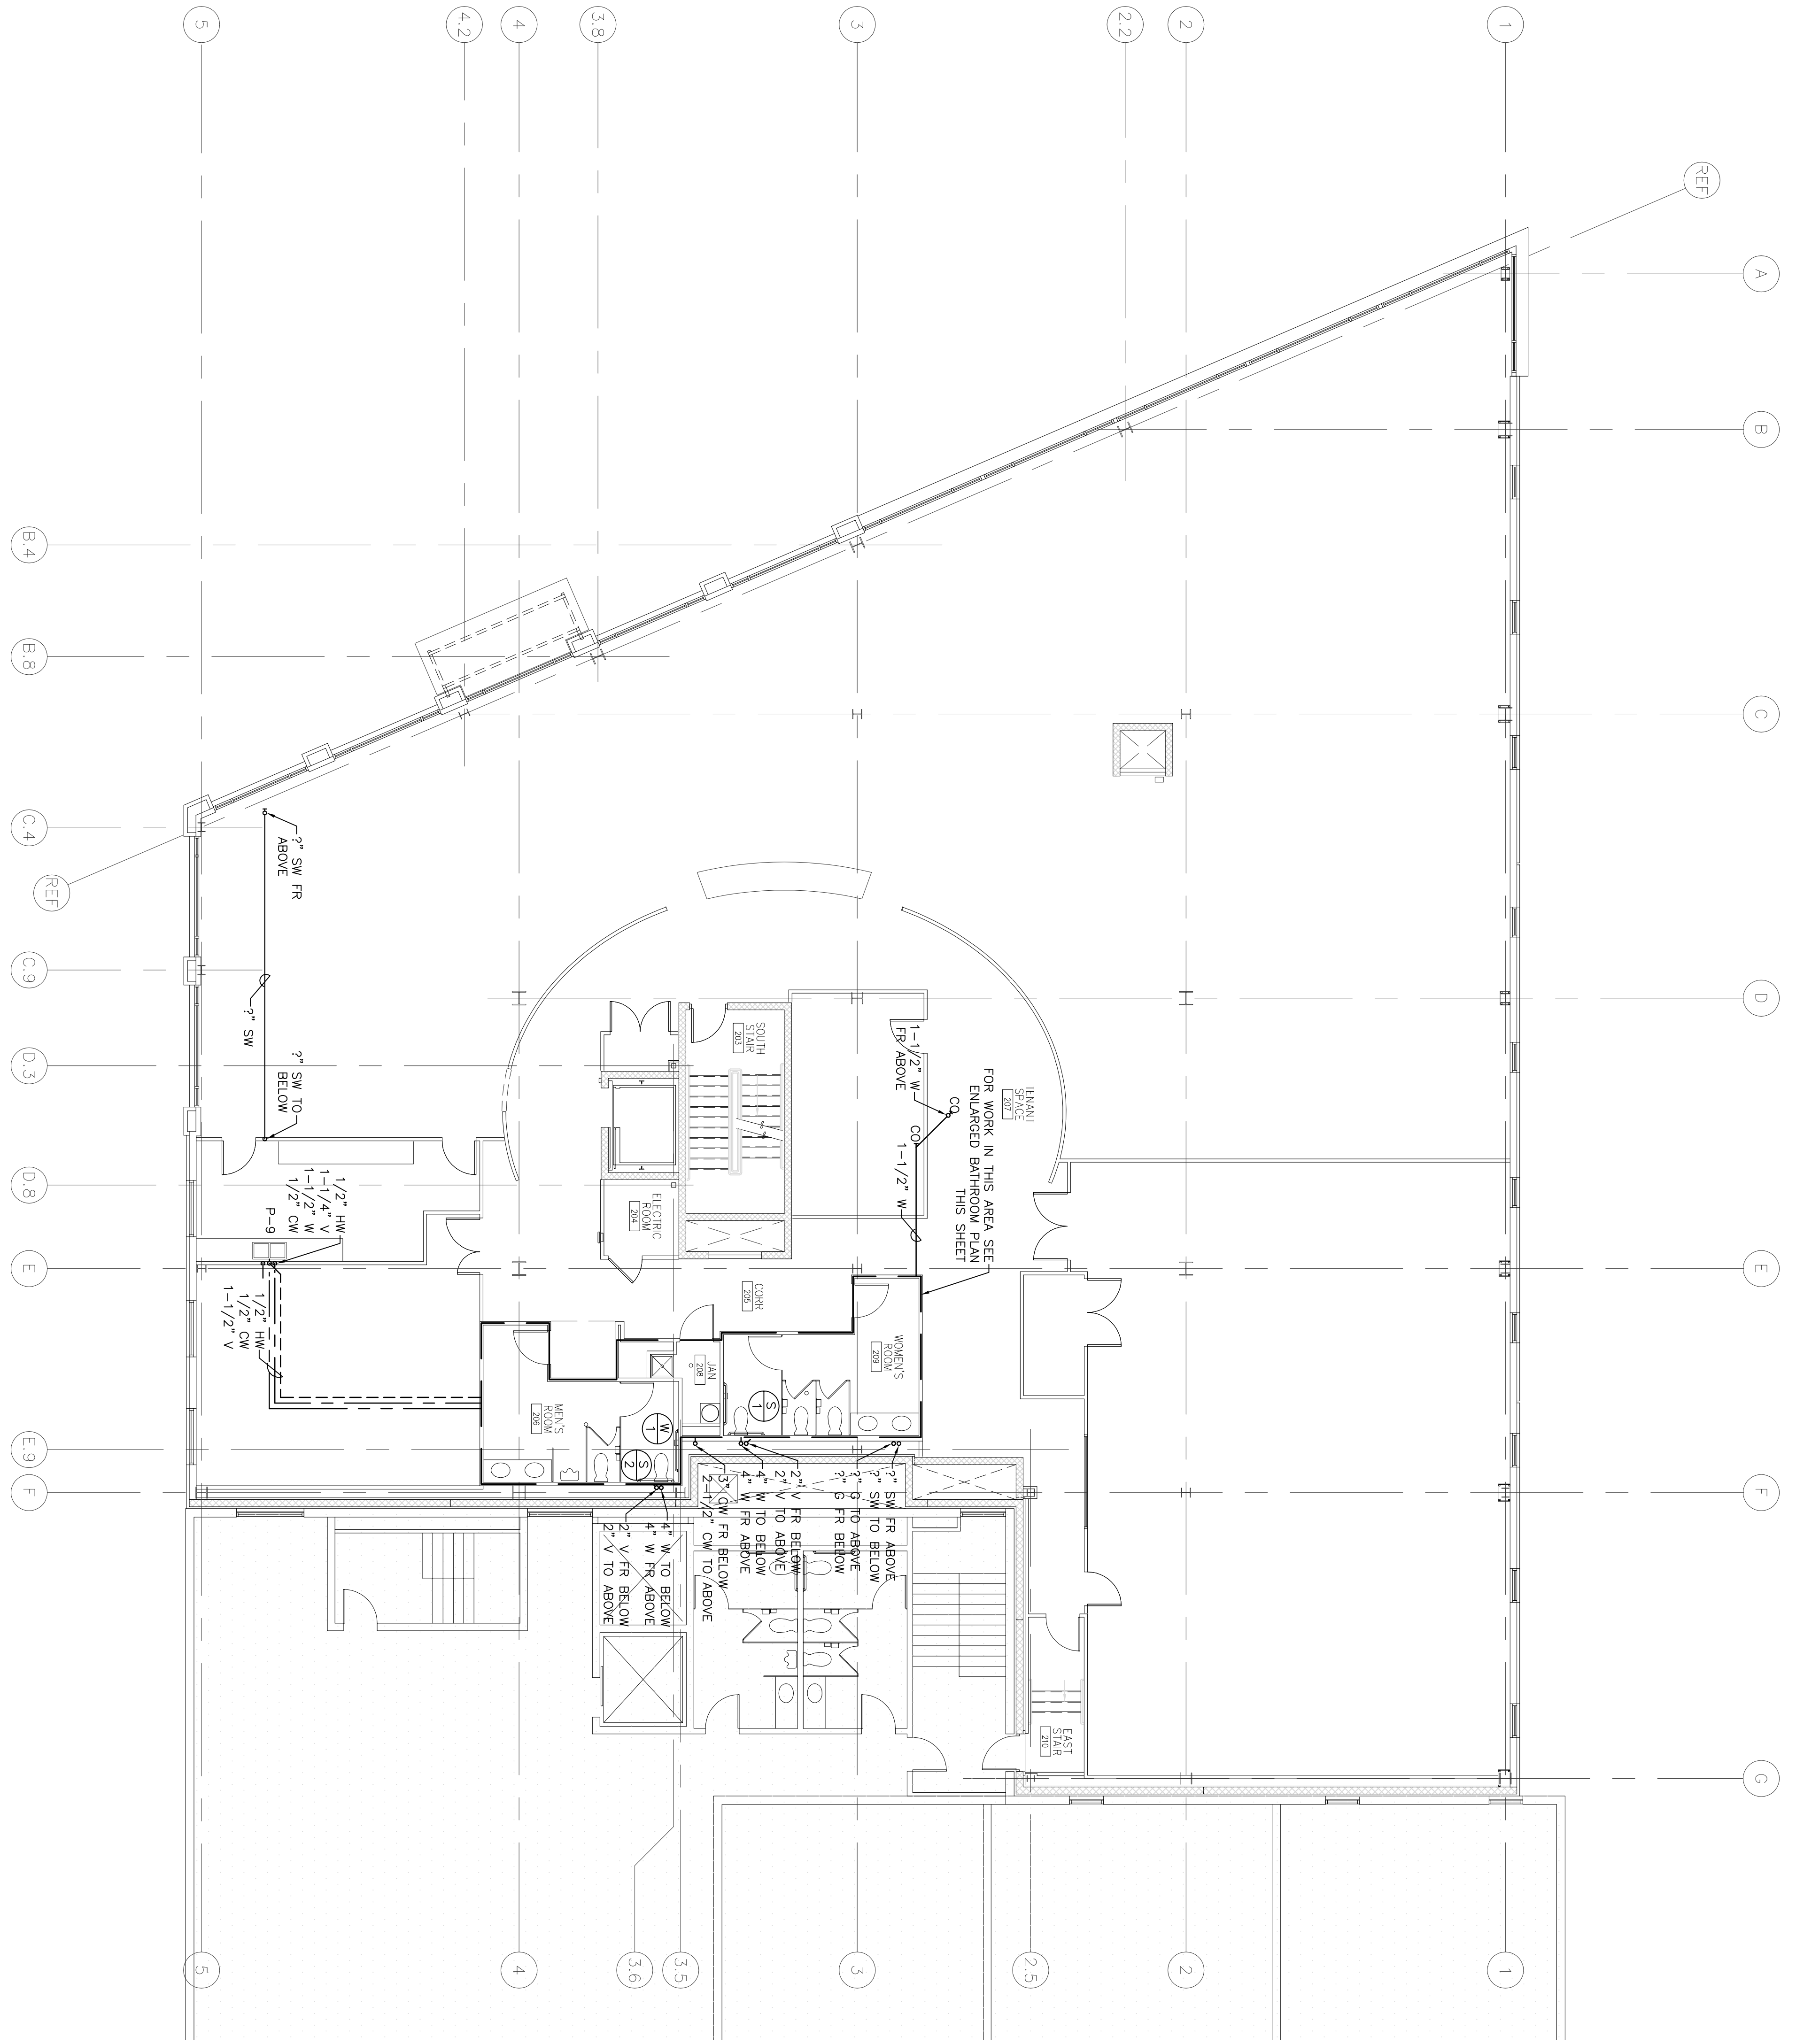

**CUSTOM HOUSE SQUARE**  
300 FORE STREET  
PORTLAND, MAINE  
SECOND FLOOR PLUMBING PLAN

**Atlantic Comfort Systems, Inc.**  
PO BOX 665-392 HILL STREET  
BIDDEFORD, MAINE 04005  
PHONE: (207) 284-6360  
FAX: (207) 284-6377

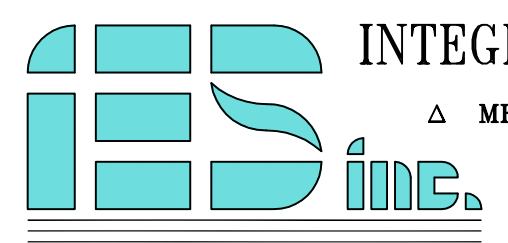

**INTEGRATED ENGINEERED SYSTEMS, INC.**  
△ MECH. DESIGN    △ ENERGY MGT.    △ INDOOR AIR QUALITY  
P.O. BOX 657    AUBURN, N.H. 03032  
Tel: (603) 625-1346    Fax: (603) 625-8456

P.E.: JK    D.B.R.: CLB  
PROJECT #: 1493  
ISSUE DATE: SEPT. 19, 2006  
**P2.2**