



WATER RISER
SCALE: N.T.S.

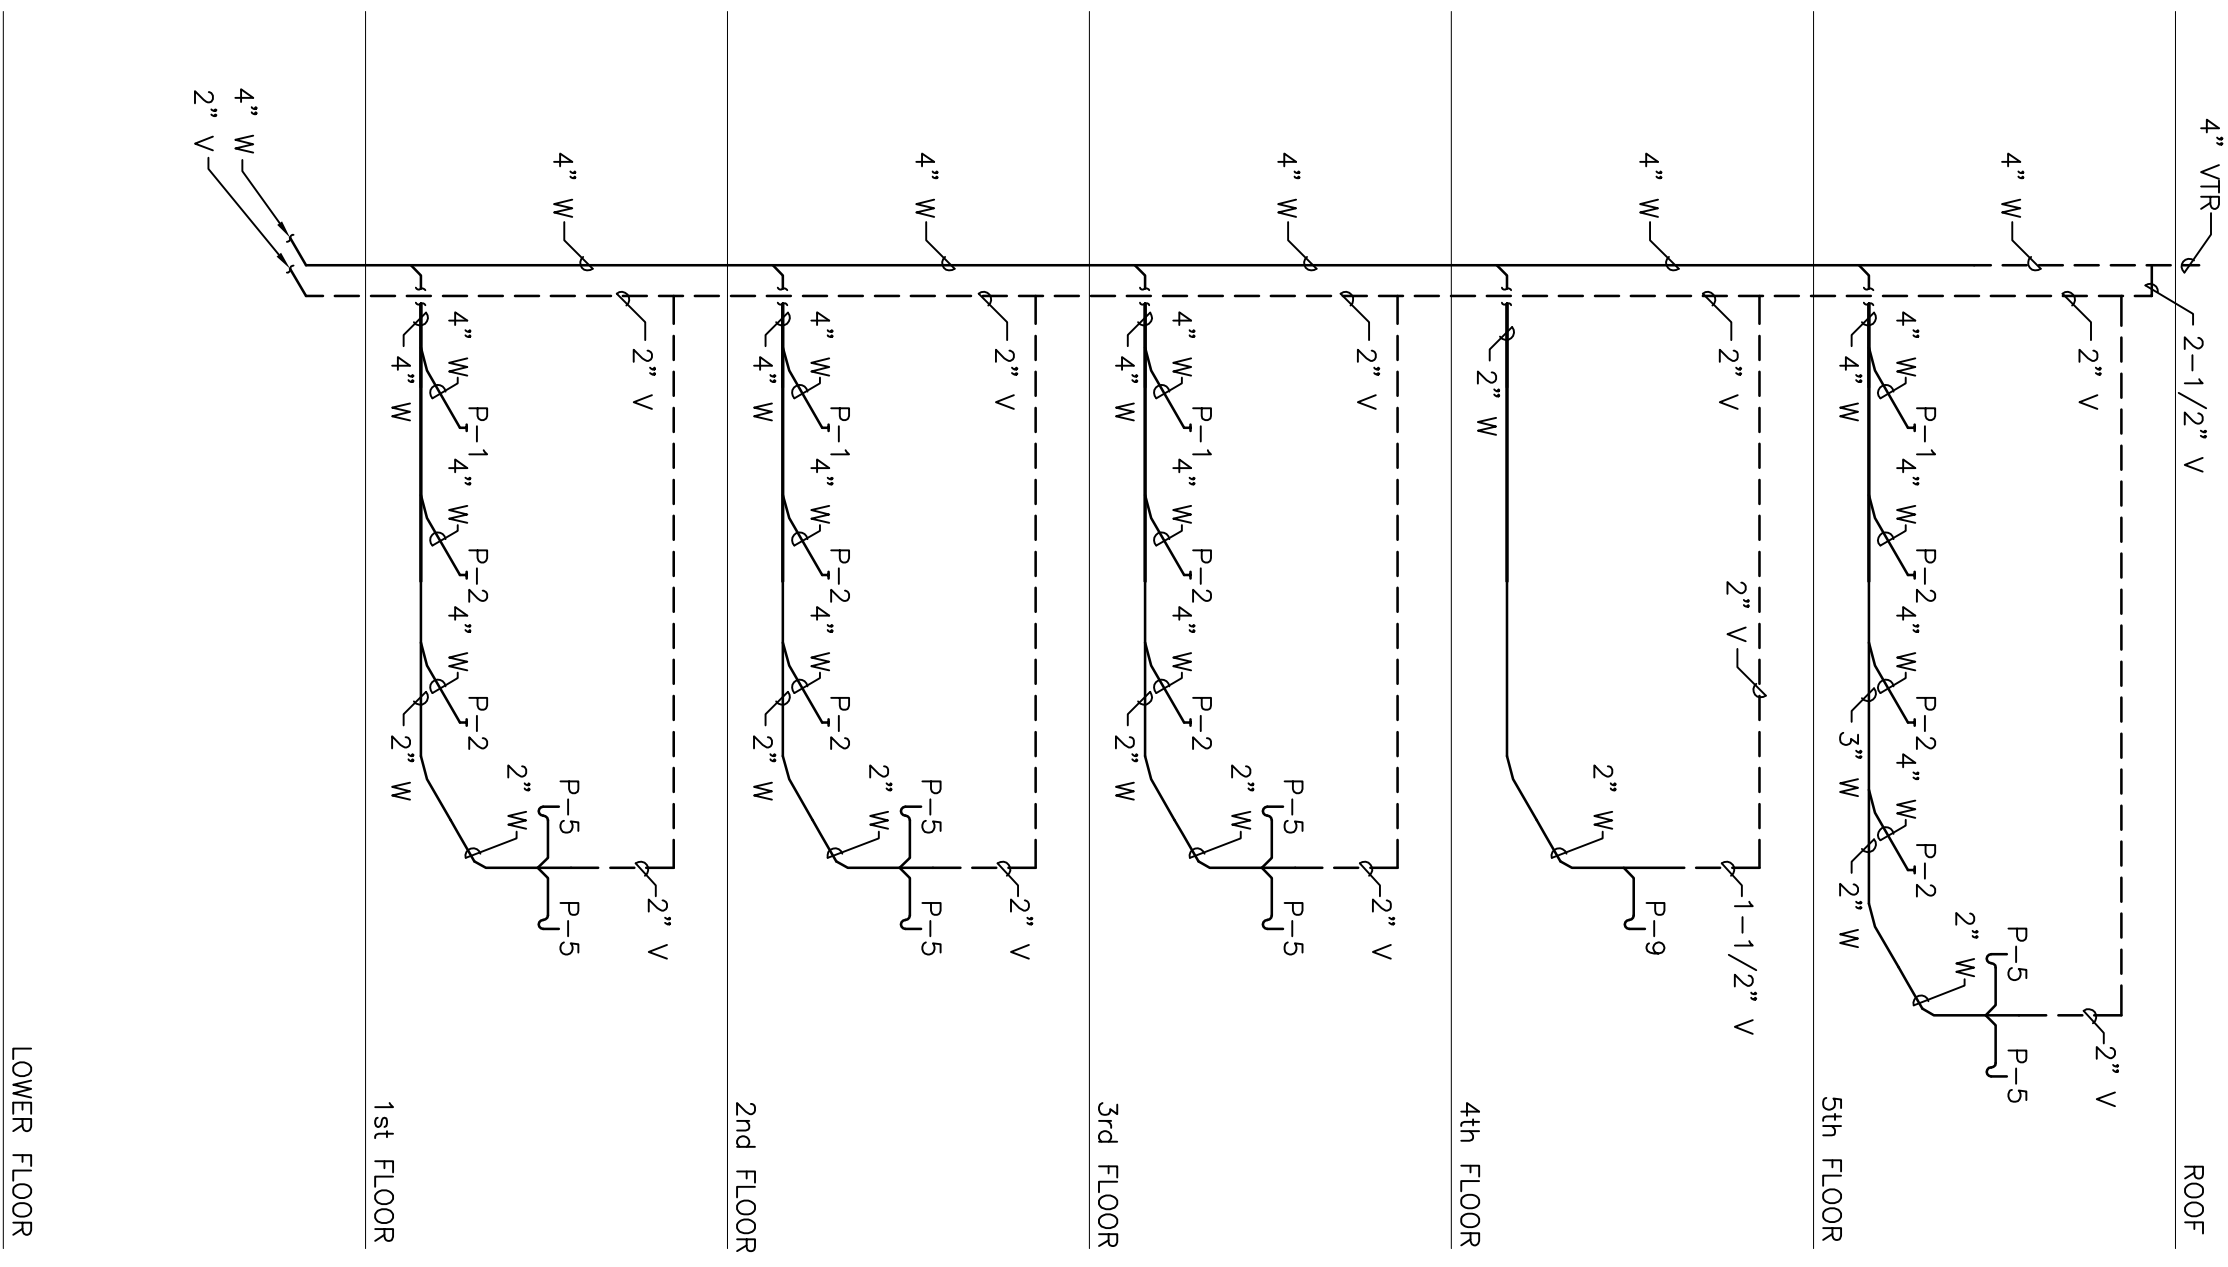

WASTE / VENT RISER
SCALE: N.T.S.

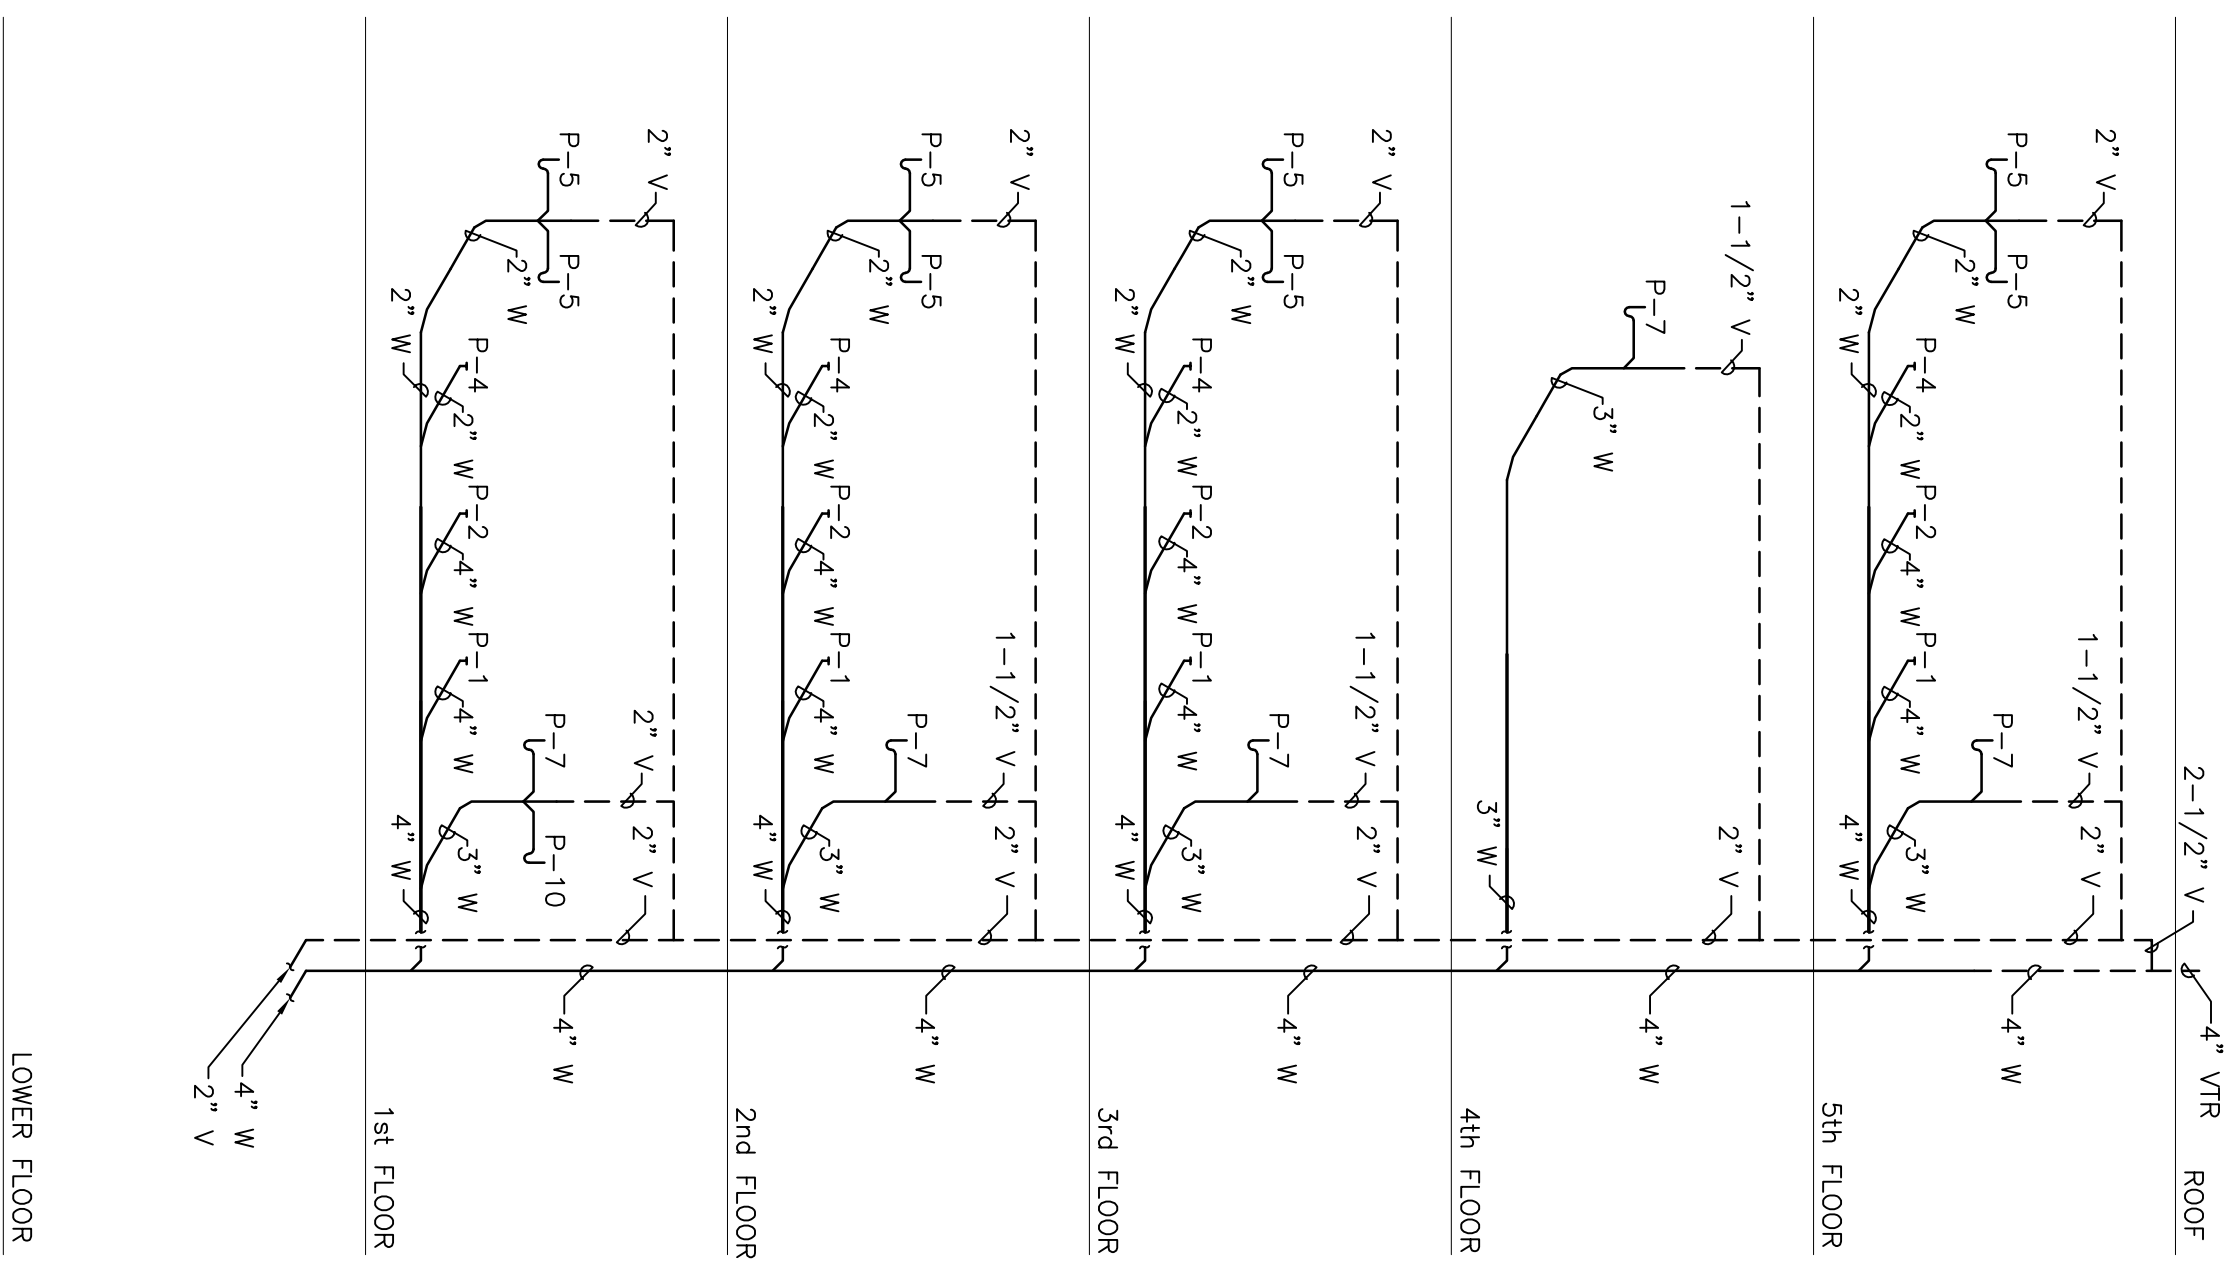

WASTE / VENT RISER
SCALE: N.T.S.

INTEGRATED ENGINEERED SYSTEMS, INC.
 Δ MECH. DESIGN Δ ENERGY MGT. Δ INDOOR AIR QUALITY
 P.O. BOX 657 AUBURN, N.H. 03032
 Tel: (603) 625-1346 Fax: (603) 625-8456

Atlantic Comfort Systems, Inc.
 PO BOX 665-392 HILL STREET
 BIDDEFORD, MAINE 04005
 PHONE: (207) 284-6360
 FAX: (207) 284-6377

CUSTOM HOUSE SQUARE
 300 FORE STREET
 PORTLAND, MAINE
PLUMBING RISER DIAGRAMS

P.E.: JK D.B.: CLB
 PROJECT #: J493
 ISSUE DATE: SEPT. 19, 2006
P3.0