


NOTES:

1. SEE SHEET M-001 FOR LEGEND AND ABBREVIATIONS.
2. PIPE RISERS & HANG TO WY BOXES IN ACCORDANCE WITH DETAIL A11/M-501 & WY BOX SCHEDULES.

KEYED NOTE:


1. RETURN GRILLE WITH A 12x12 LINED DUCT ELBOWED INTO THE TOP OF A PLENUM ATOP THE GRILLE AND OPEN-ENDED AFTER PASSING THRU THE CORRIDOR WALL ABOVE THE CEILING.

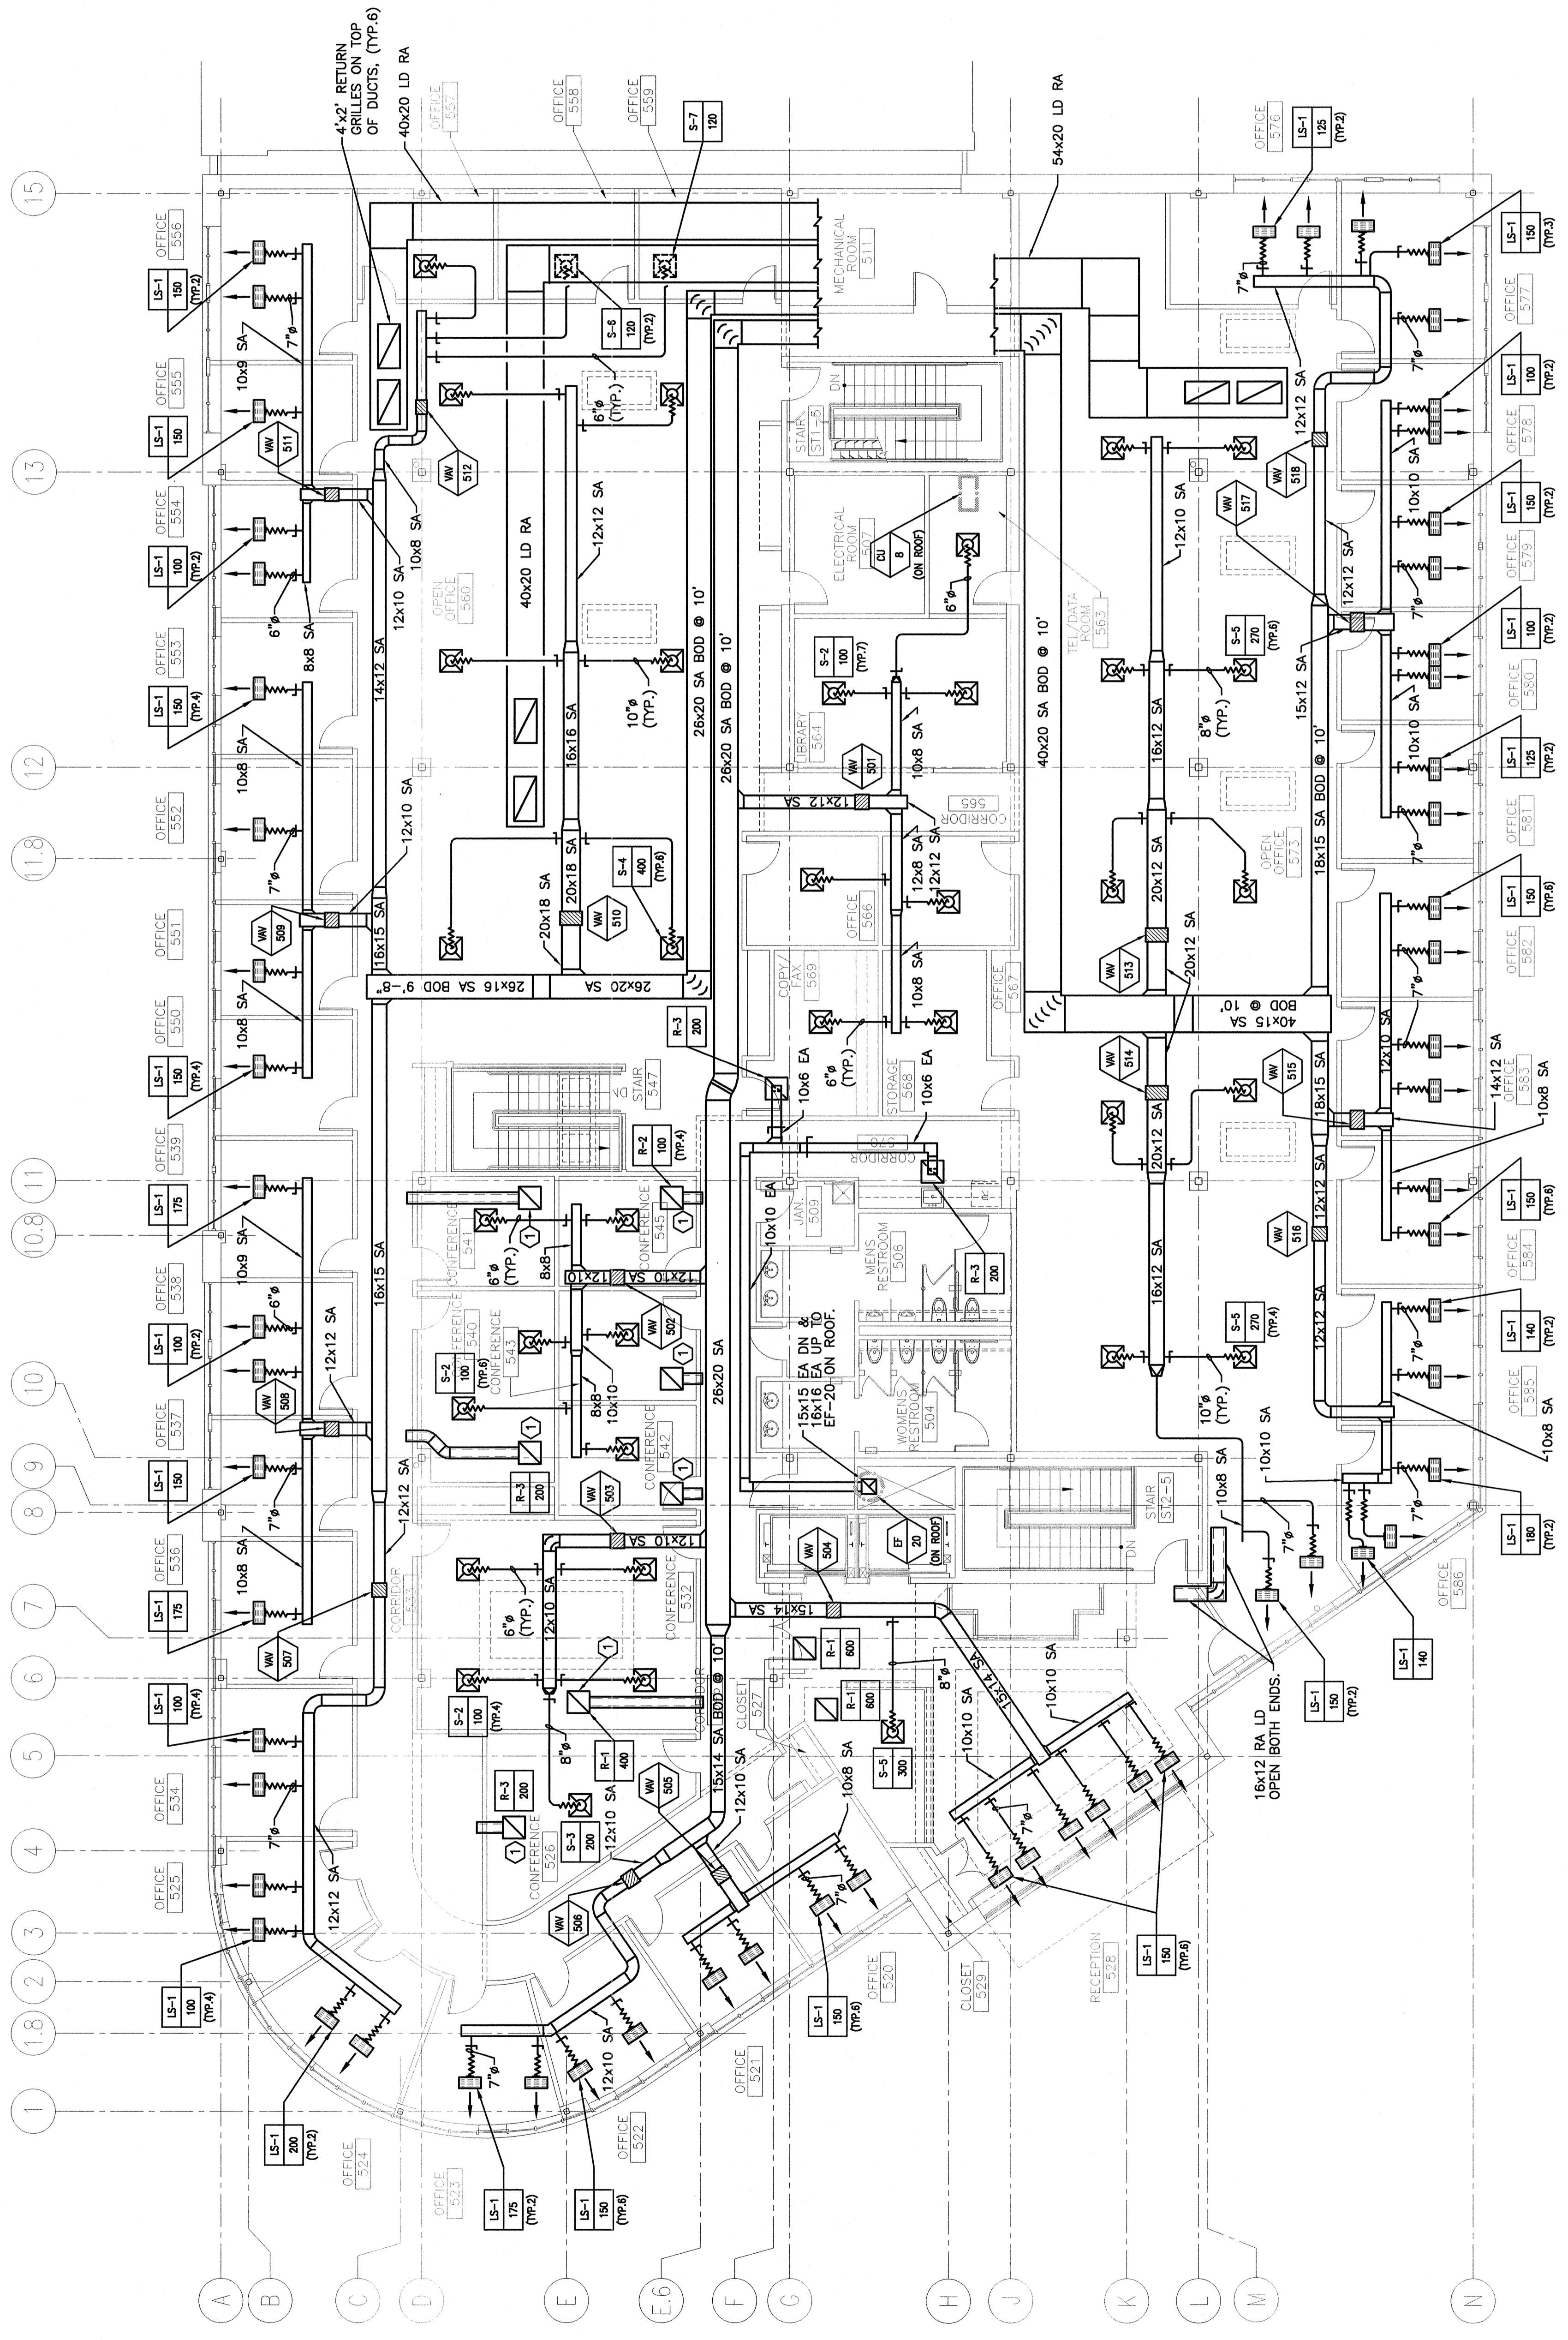

REV.	ISSUED FOR PERMIT/CONTRACT	DESCRIPTION	DATE
0			6-11-04

ISSUED FOR PERMIT/CONTRACT
6-11-04

CURRENT ISSUE STATUS:

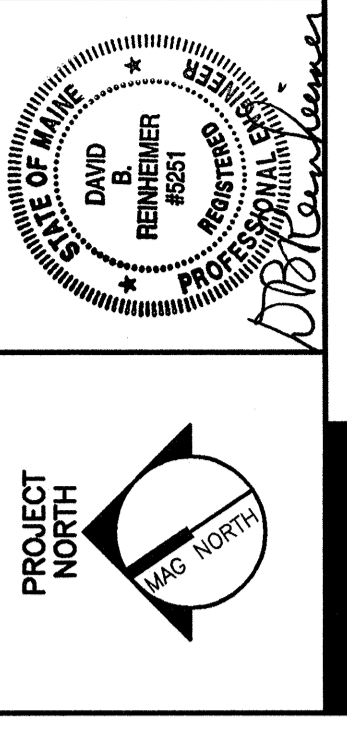

SMRT
 ARCHITECTURE ENGINEERING PLANNING
 144 Fore Street/P.O. Box 618
 Portland, Maine 04104
 tel. (207) 772-3846
 fax. (207) 772-1070

BAKER NEWMAN NOYES
 FIT-UP
 PORTLAND, MAINE

PROJECT:
FIFTH FLOOR
HVAC DUCTWORK PLAN

SHEET TITLE:	1/8" = 1'-0"	DATE:	6-11-04
SCALE:	1/8" = 1'-0"	GRAPHIC SCALE:	0'
PROJECT MANAGER:	JLH	DATE:	6-11-04
JOB CAP/DRAWN:	DJM/BGG		
A/E OF RECORD:	DBR		
SMART CAD FILE:	MH102-03137	SHEET NO.:	MH102
PROJECT NO.:	03137		

A1 FIFTH FLOOR PLAN

1/8" = 1'-0"