


NOTE:


1. SEE SHEET M-001 FOR LEGEND AND ABBREVIATIONS.

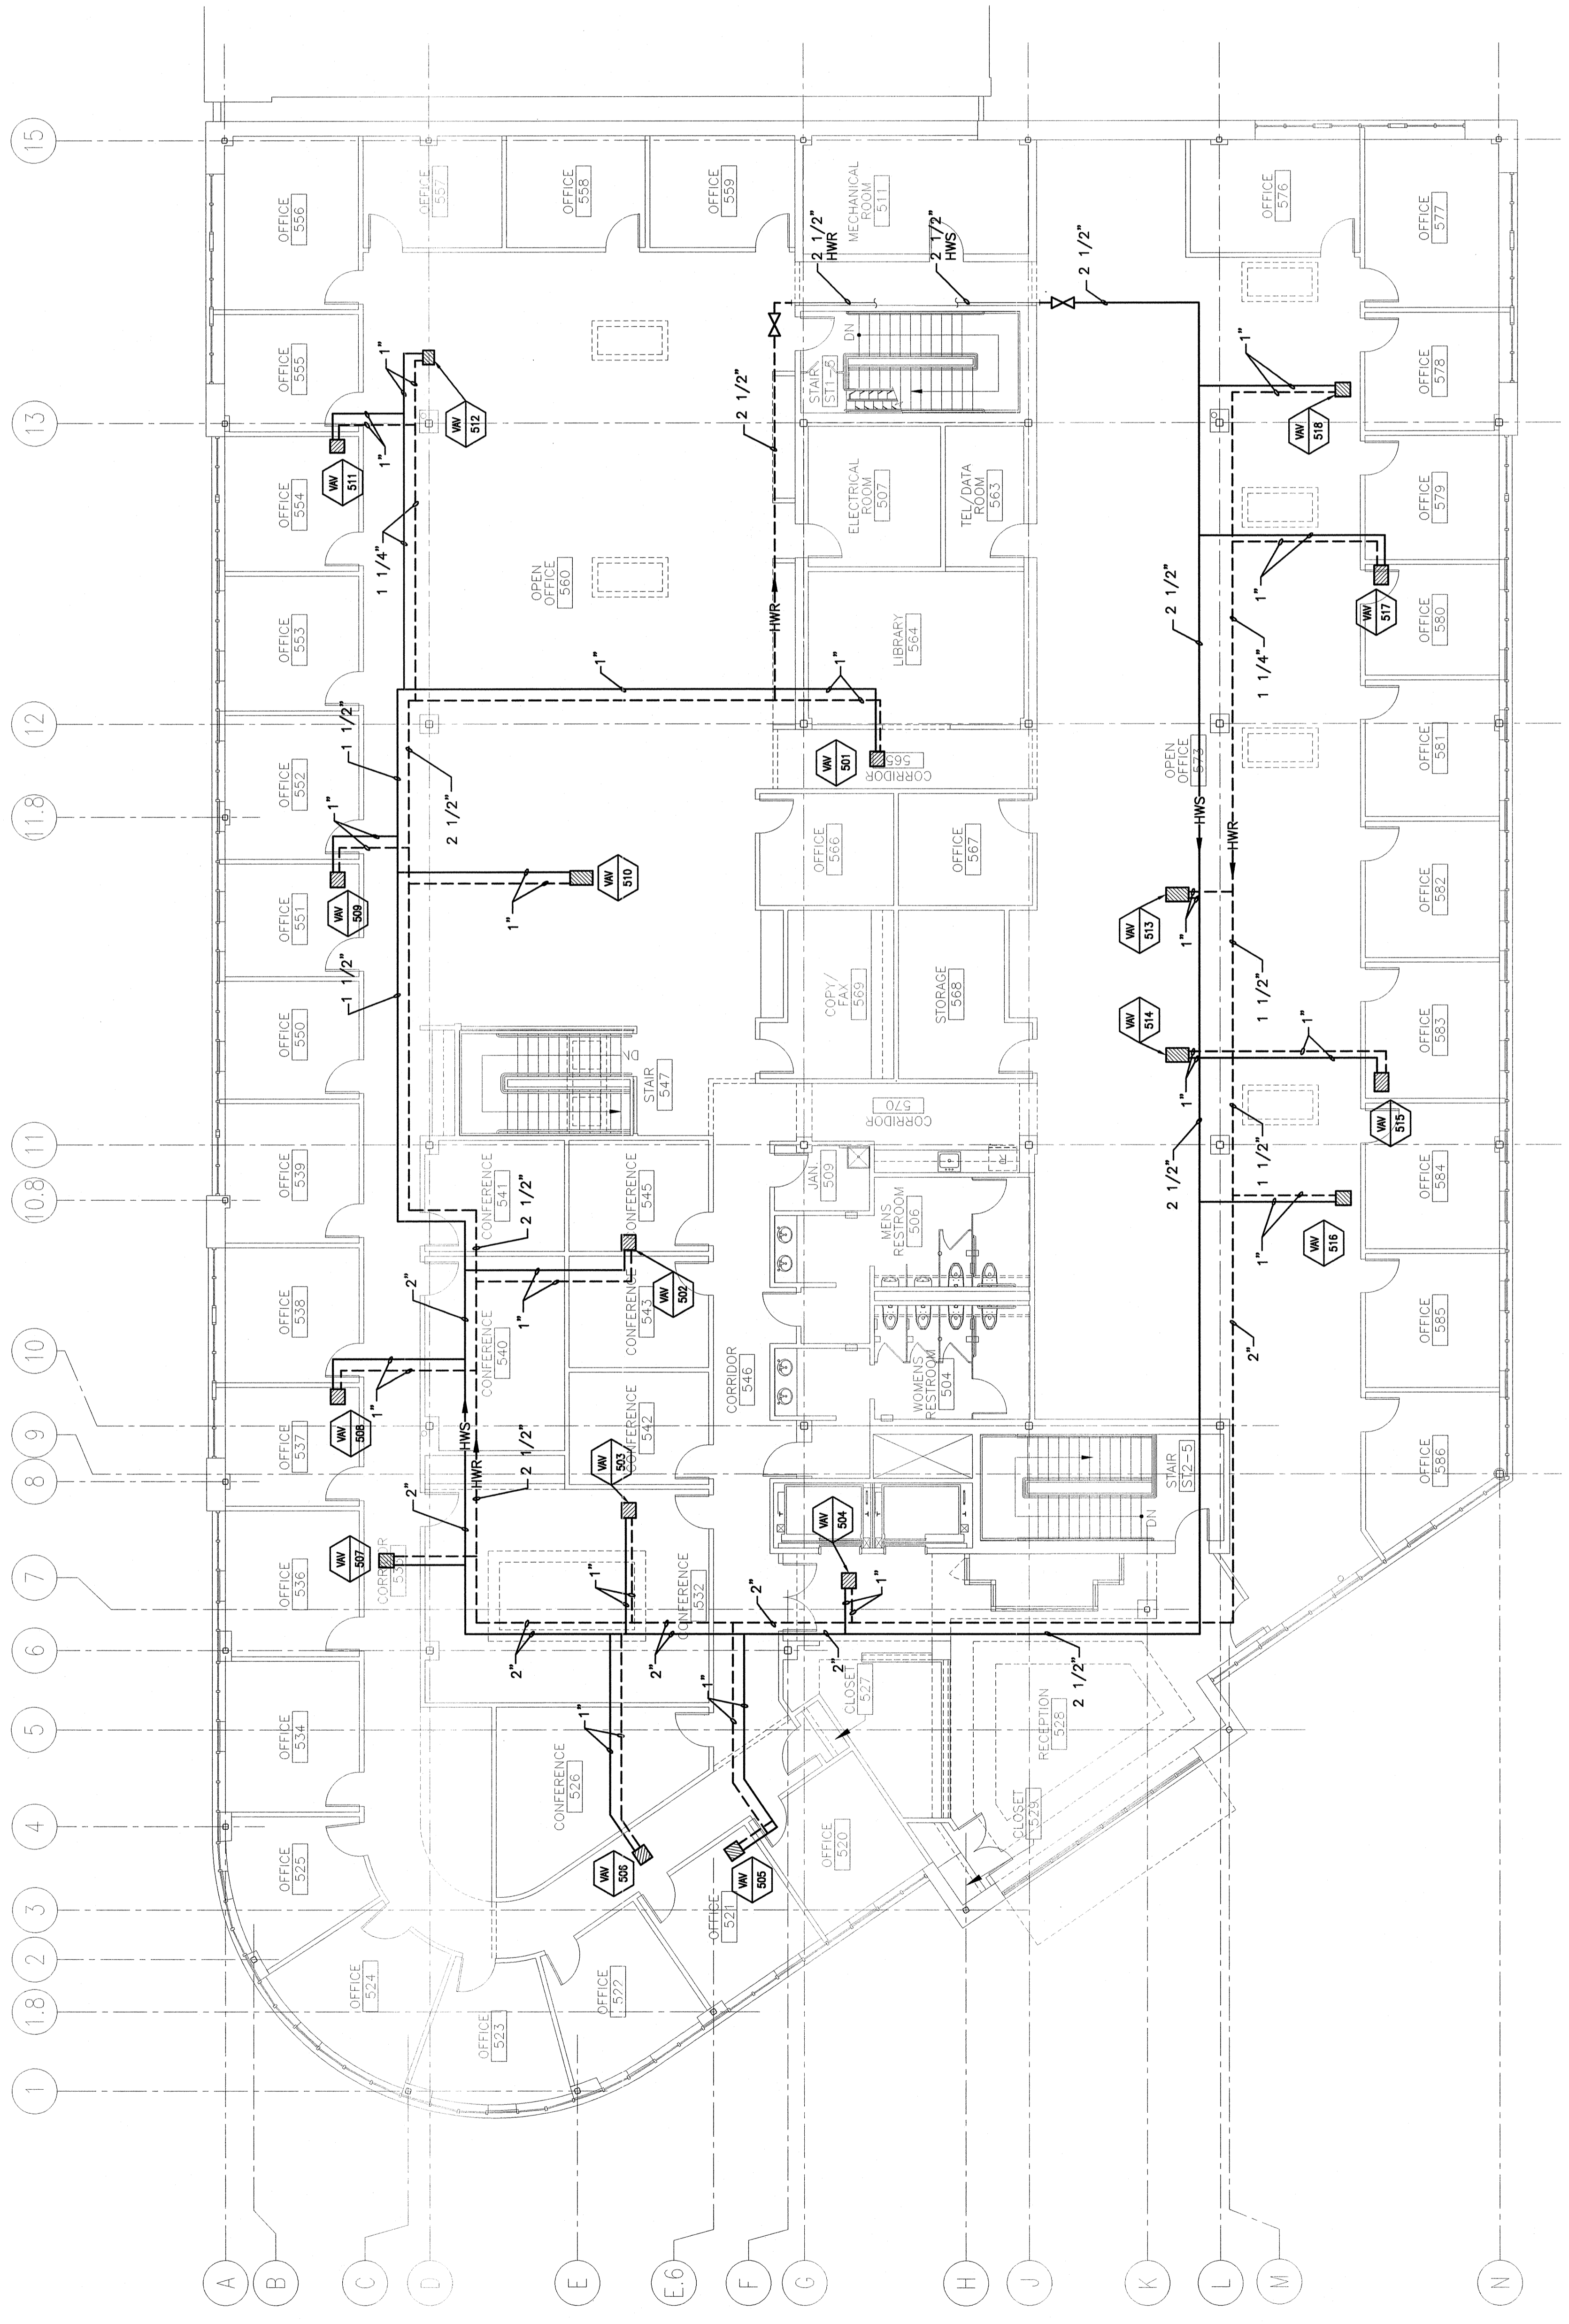

REV.	ISSUED FOR PERMIT/CONTRACT	DATE
0	ISSUED FOR PERMIT/CONTRACT	6-11-04

ISSUED FOR PERMIT/CONTRACT
6-11-04

CURRENT ISSUE STATUS:

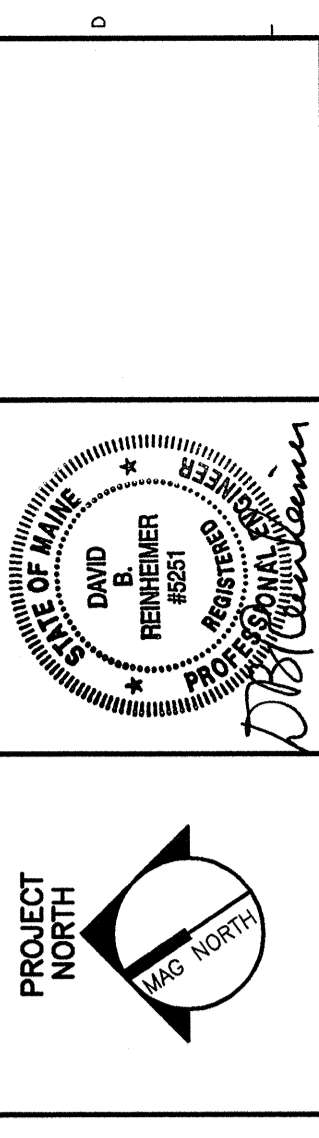

PROJECT NORTH
SM RT
 ARCHITECTURE ENGINEERING PLANNING
 144 Foye Street/PP.O. Box 618
 Portland, Maine 04104
 tel. (207) 772-3846
 fax. (207) 772-1070

BAKER NEWMAN NOYES
 FIT-UP
 PORTLAND, MAINE

FIFTH FLOOR
HVAC PIPING PLAN

SHEET TITLE: FIFTH FLOOR HVAC PIPING PLAN
 SCALE: 1/8" = 1'-0"
 DATE: 6-11-04
 PROJECT MANAGER: JLN
 GRAPHIC SCALE: 8"
 JOB CAP/DRAWN: DJM/BGG
 A/E OF RECORD: DBR

SMART CAD FILE: MP102-03137
 PROJECT NO.: 03137
 SHEET NO.: MP102

A1 FIFTH FLOOR PLAN

1/8" = 1'-0"