


**NOTE:**

1. SEE SHEET M-001 FOR LEGEND AND ABBREVIATIONS.

**KEYED NOTE:**


Ⓢ COORDINATE LOCATION TO AVOID INTERFERENCE WITH COFFEE MACHINE.

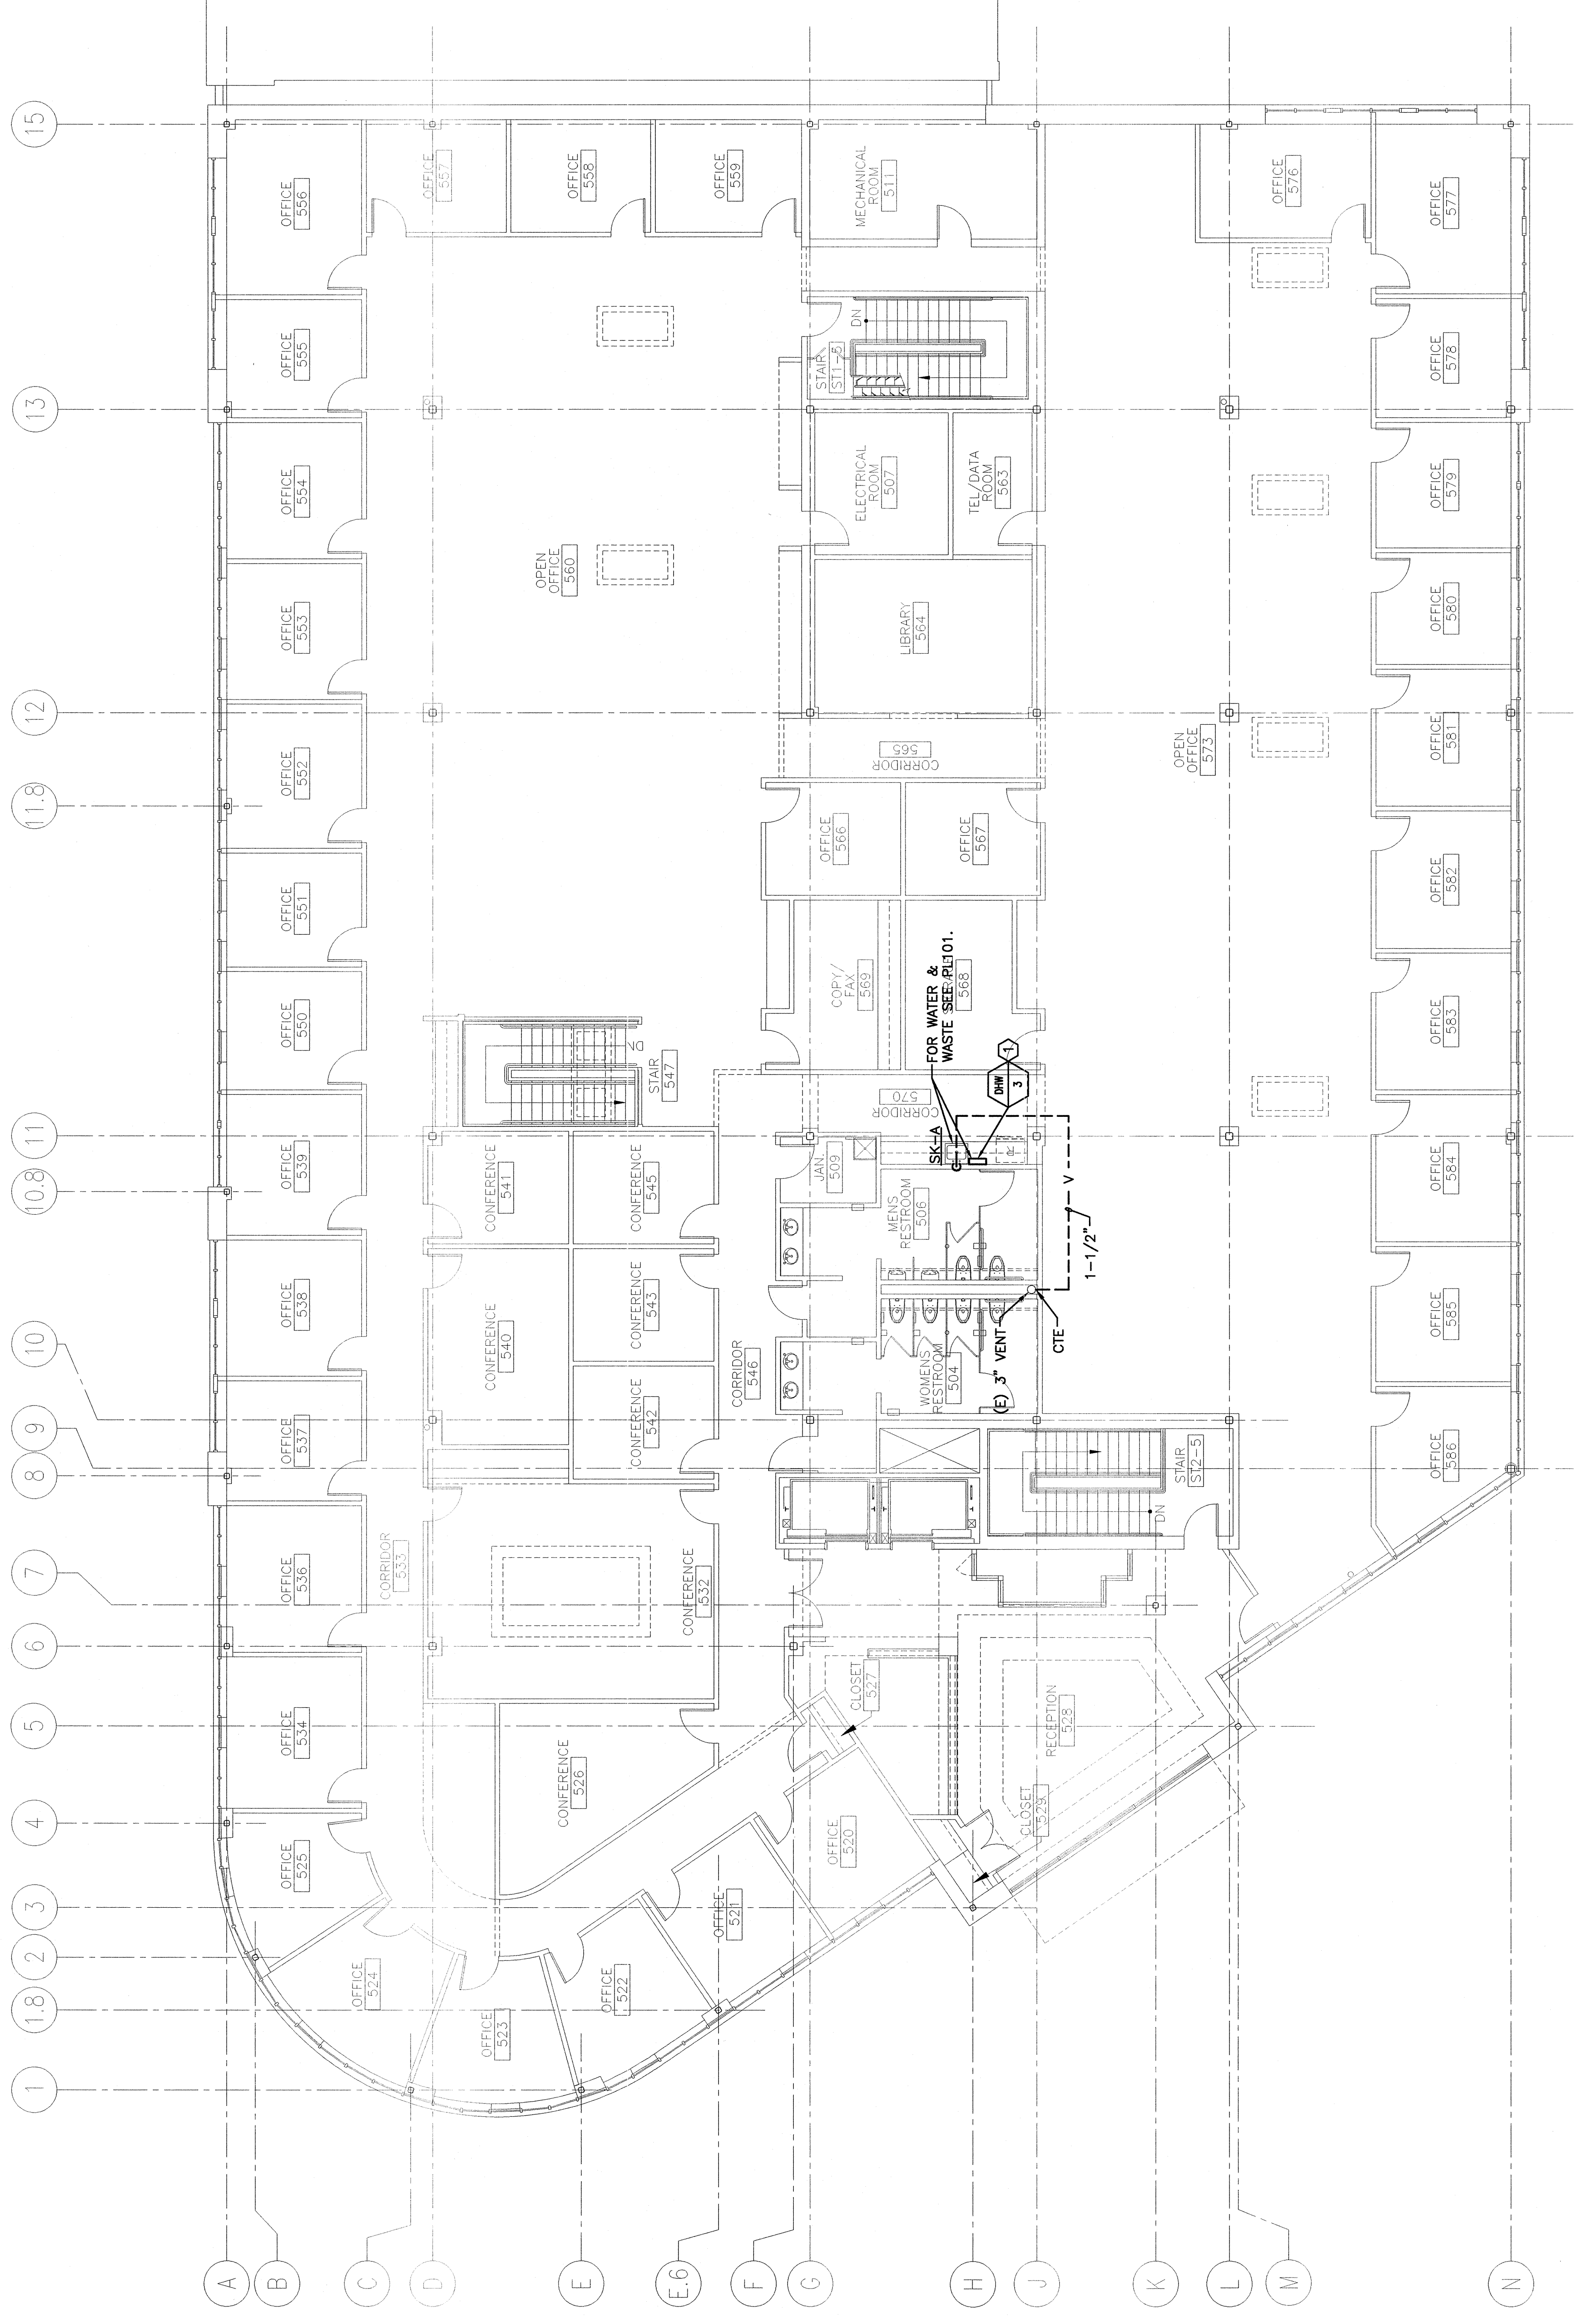

REV.	ISSUED FOR PERMIT/CONTRACT	DESCRIPTION	DATE
0			6-11-04

**ISSUED FOR PERMIT/CONTRACT**  
**6-11-04**

CURRENT ISSUE STATUS:

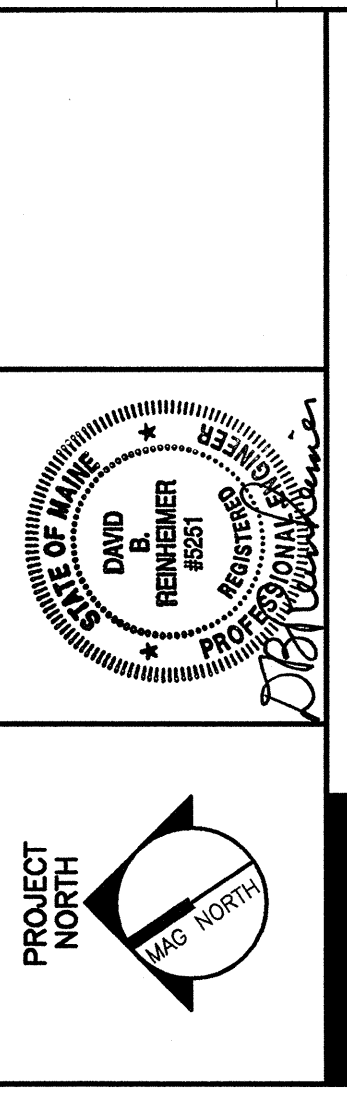

**SM RT**  
 ARCHITECTURE ENGINEERING PLANNING  
 144 Fore Street P.O. Box 618  
 Portland, Maine 04104  
 tel. (207) 772-3846  
 fax. (207) 772-1070

**BAKER NEWMAN NOYES**  
 FIT-UP  
 PORTLAND, MAINE

PROJECT:  
**FIFTH FLOOR PLUMBING PLAN**

SHEET TITLE:  
 SCALE: 1/8" = 1'-0"  
 DATE: 6-11-04

PROJECT MANAGER: JLN  
 JOB CAP/DRAWN: DJM/BSG  
 GRAPHIC SCALE: 0'

SHEET No. **PL102**

SMRT CAD FILE: PL102-03137  
 PROJECT No. 03137

**A1 FIFTH FLOOR PLAN**

1/8" = 1'-0"