


NOTE:

1. SEE SHEET E-001 FOR LEGEND AND GENERAL NOTES.

KEYED NOTES:


1. MOUNT RECEPTACLE 42" AFF TO CENTER OF DEVICE.
2. PROVIDE WALL FEED TO MODULAR FURNITURE. COORDINATE W/FURNITURE INSTALLER FOR LOCATIONS OF ELECTRICAL CONNECTIONS. WIRING TO BE 3/4" AWG PHASE CONDUCTORS, 1/4" AWG NEUTRALS & 1/4" AWG GND.
3. PROVIDE POWER CONNECTION TO ELECTRIC DISHWASHER.
4. PROVIDE MANUAL TOGGLE SWITCH FOR SERVICE DISCONNECT AND WIRING TO BE 3/4" AWG PHASE CONDUCTORS, 1/4" AWG NEUTRALS & 1/4" AWG GND. COORDINATE W/ PLUMBING CONTRACTOR FOR EXACT LOCATION OF ELECTRICAL CONNECTION.
5. COORDINATE W/ OWNER FOR CONFIGURATION OF PHONE SYSTEM OUTLET. WIRING TO BE 3-#6 AWG & #10 GND, 5/8".

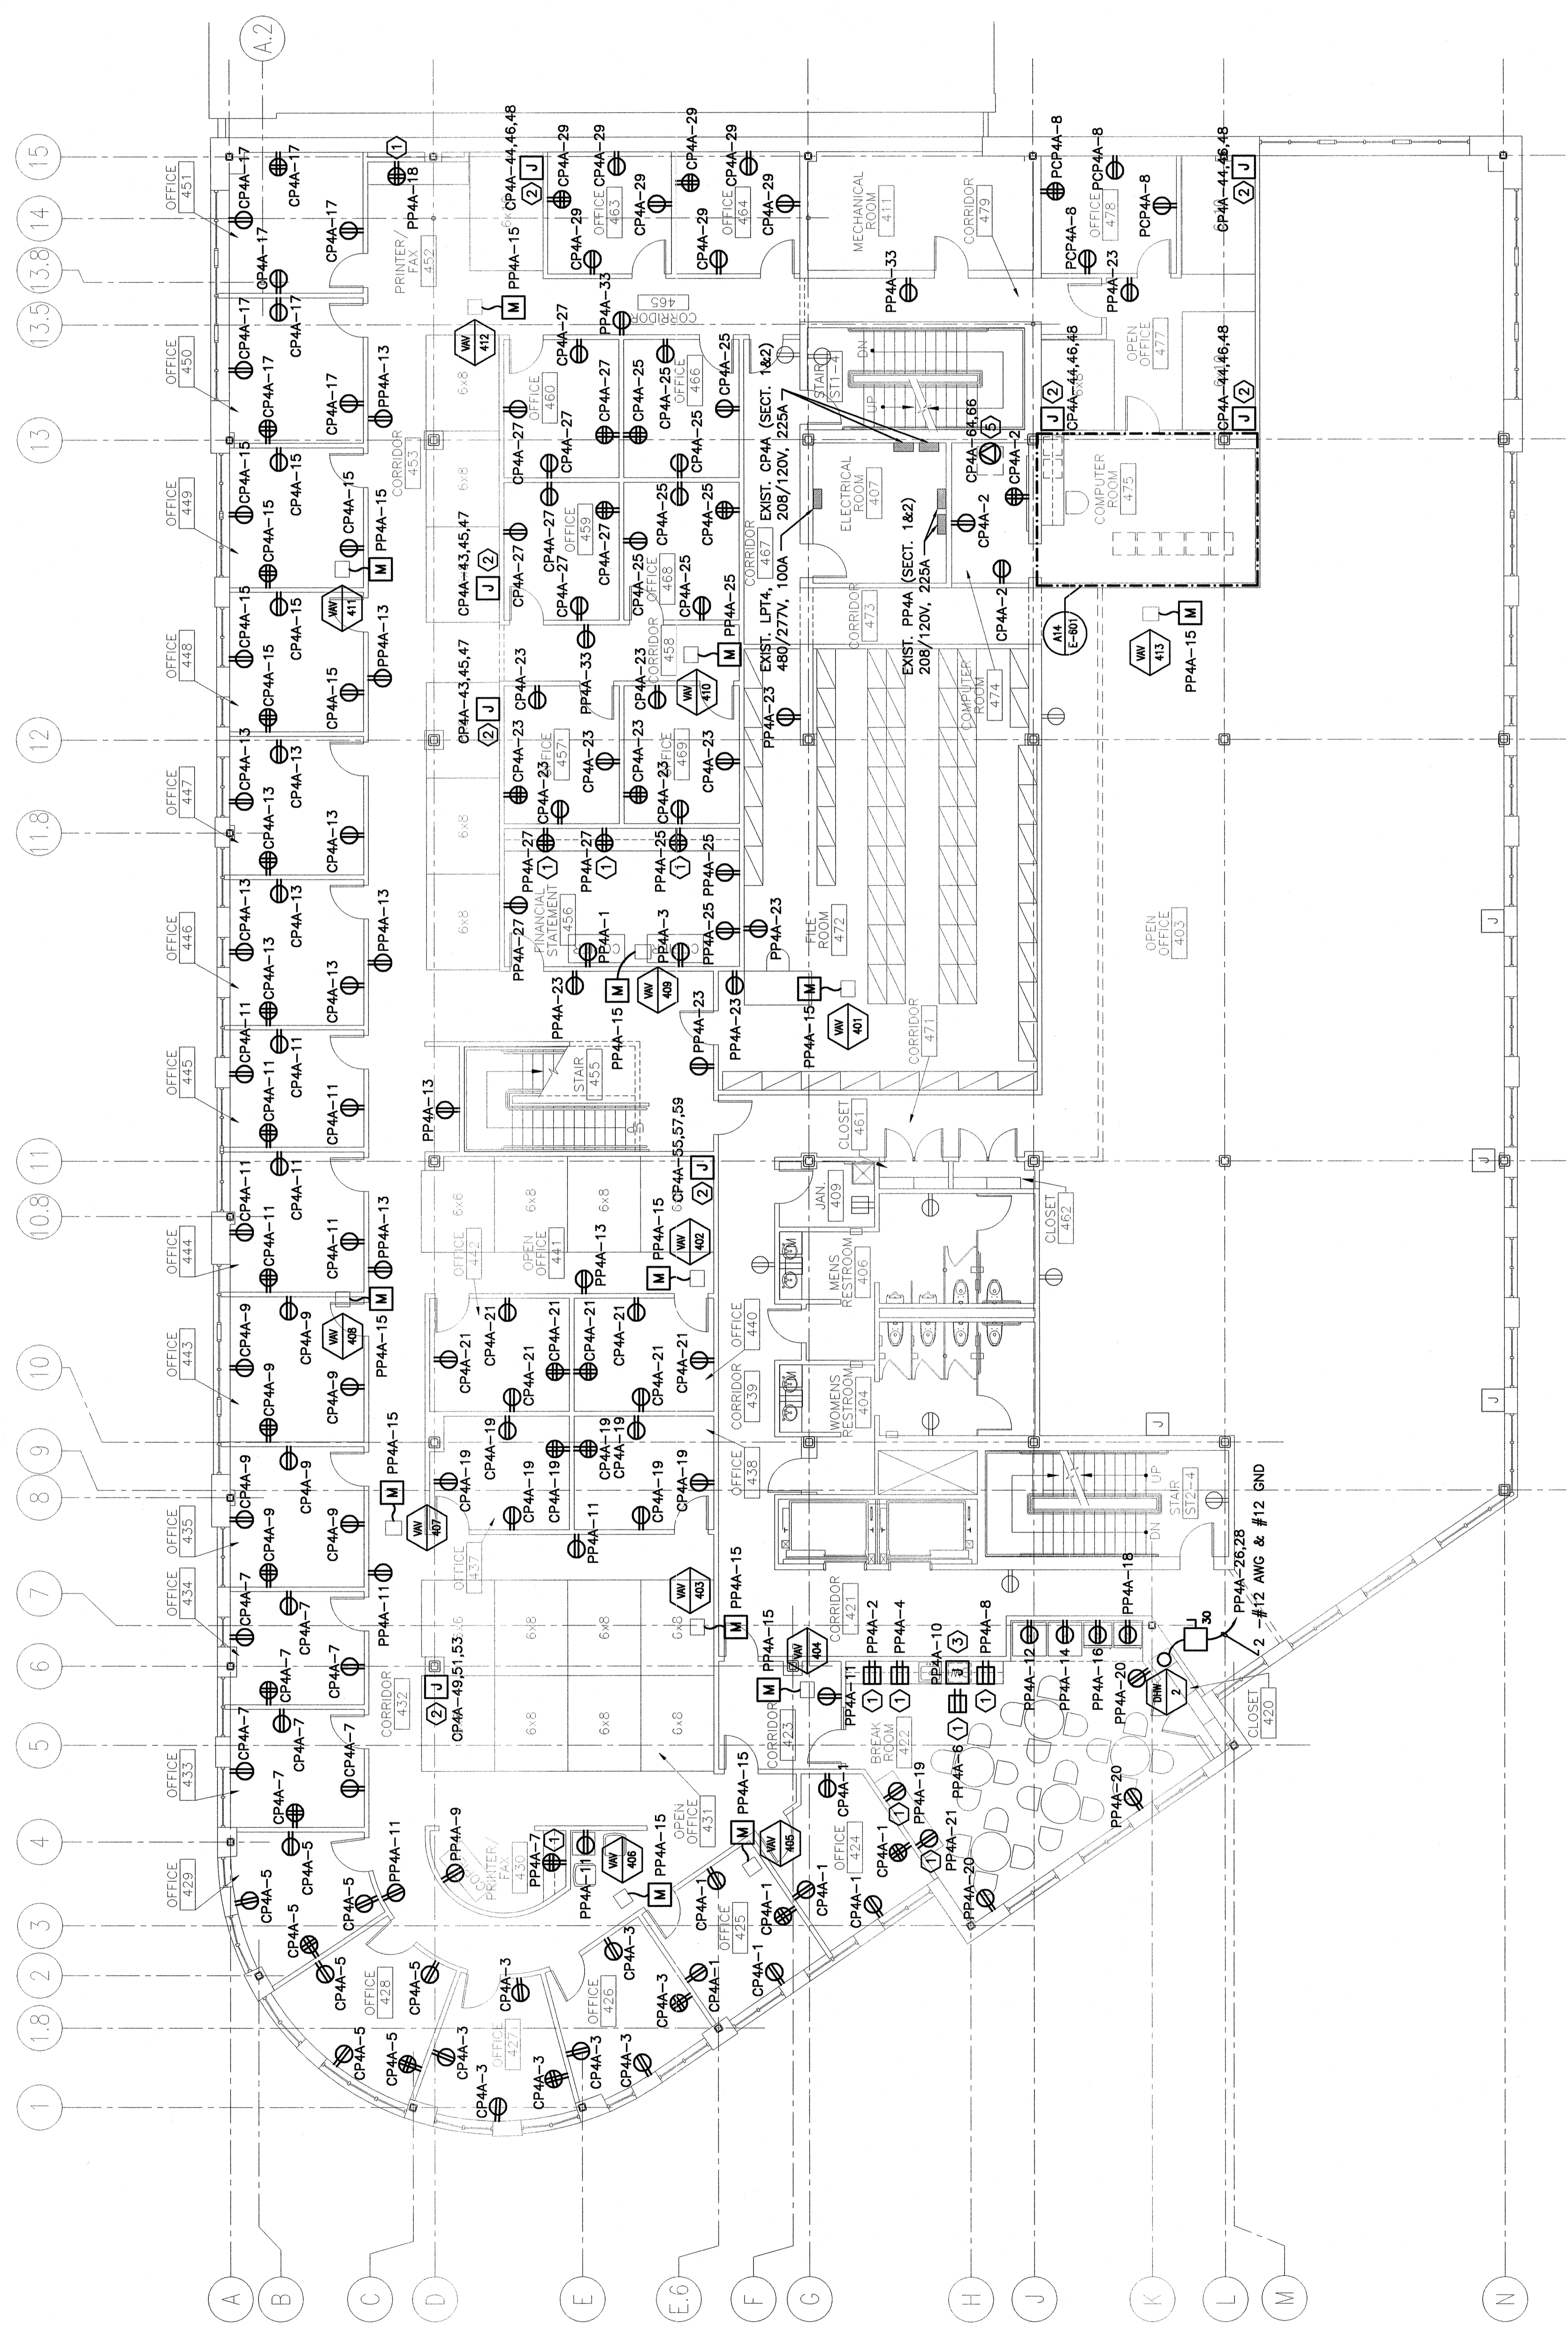

REV.	ISSUED FOR PERMIT/CONTRACT	DATE
0	ISSUED FOR PERMIT/CONTRACT	6-11-04

ISSUED FOR PERMIT/CONTRACT
6-11-04

CURRENT ISSUE STATUS:

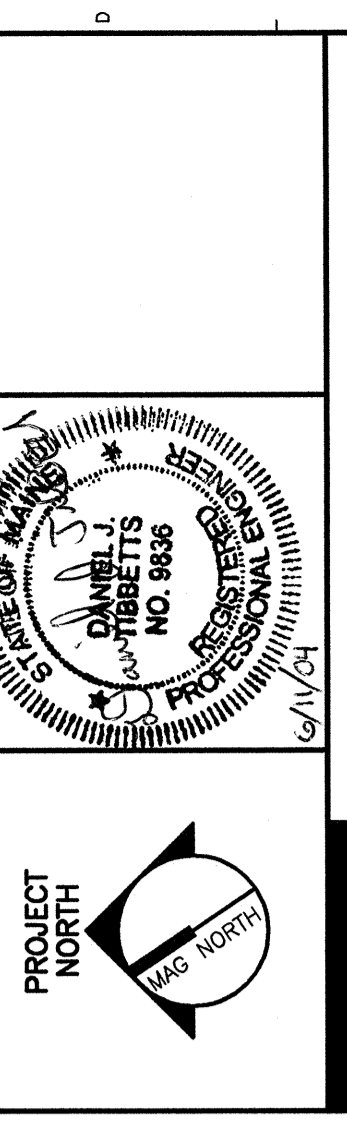

S.M. RT
 ARCHITECTURE ENGINEERING PLANNING
 144 Fore Street, P.O. Box 618
 Portland, Maine 04104
 Tel. (207) 772-3846
 Fax. (207) 772-1070

BAKER NEWMAN NOYES
 FIT-UP
 PORTLAND, MAINE

PROJECT:
FOURTH FLOOR POWER PLAN

SHEET TITLE:
 SCALE: 1/8" = 1'-0" DATE: 6-11-04
 PROJECT MANAGER: J.H. GRAPHIC SCALE: 1" = 1'-0"

JOB CADD/DRAWN: DJM/JAM
 A/E OF RECORD: DJM
 SMRT CADD FILE: EP101-03137
 PROJECT NO.: 03137

SHEET NO.: EP101

A1 FOURTH FLOOR PLAN

1/8" = 1'-0"