


NOTES:


1. SEE SHEET E-001 FOR LEGEND AND GENERAL NOTES.
2. SEE SHEET EPI01 FOR LOCATION OF PANELBOARD LPT4.

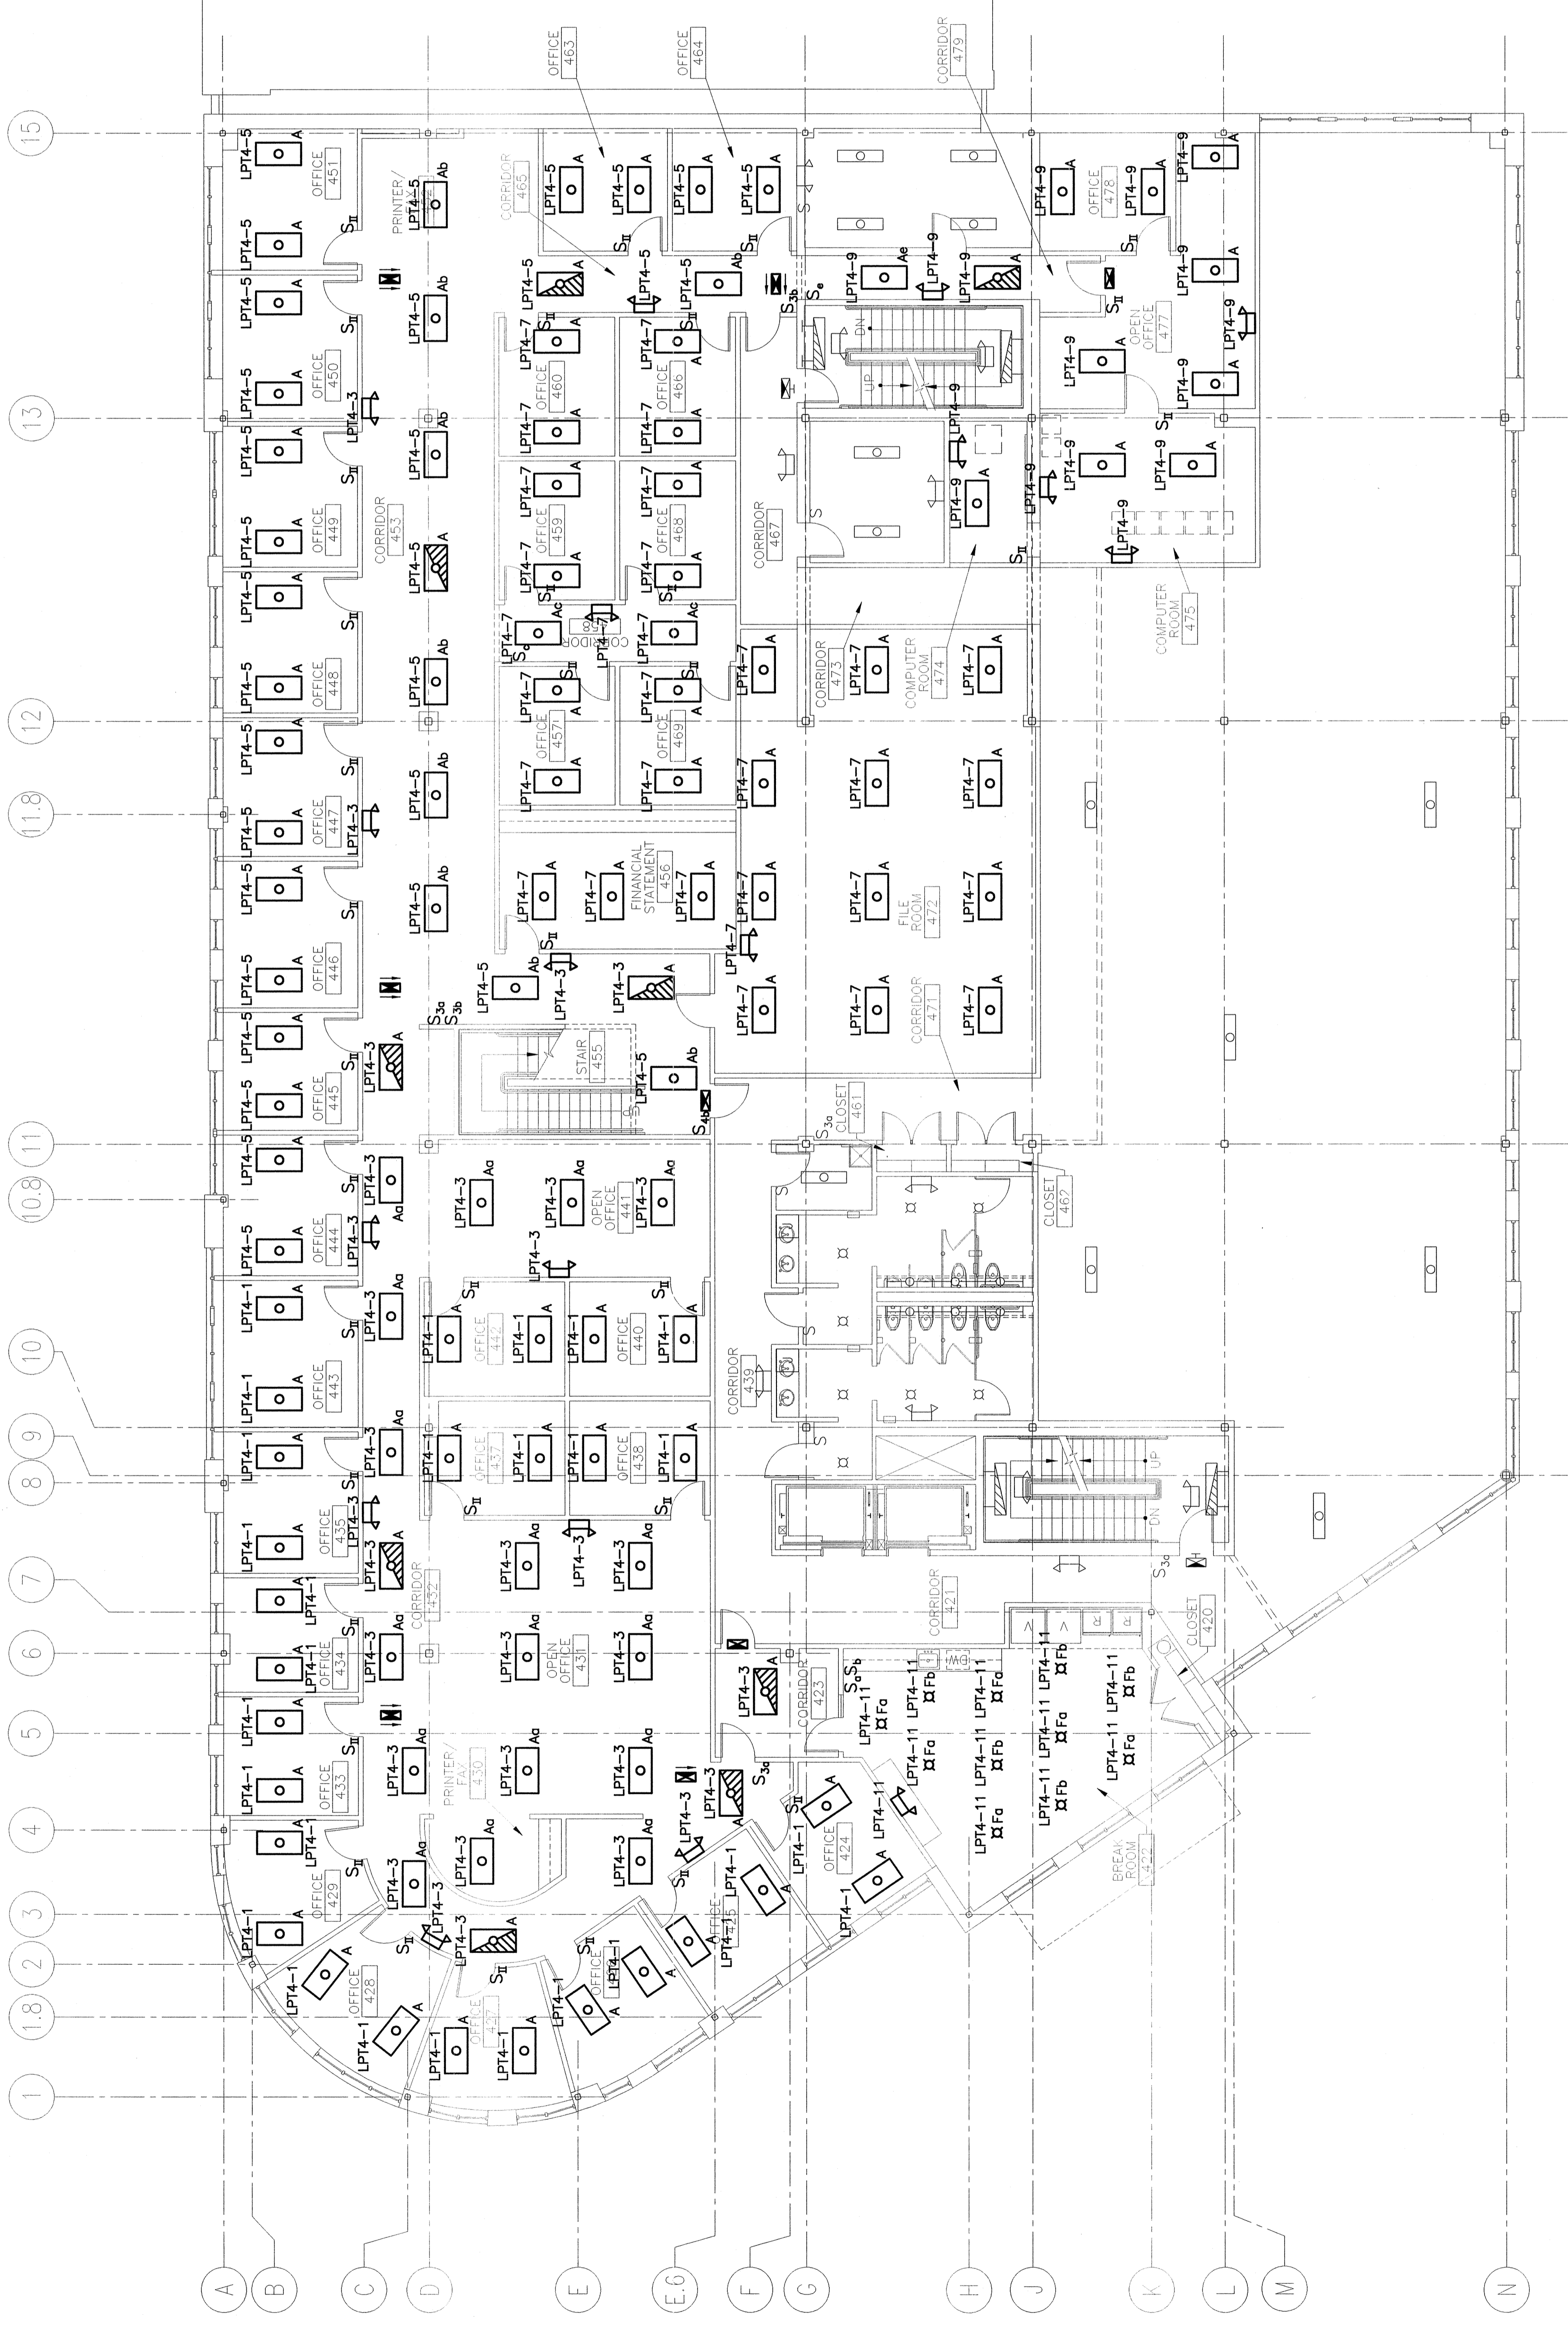

REV.	ISSUED FOR PERMIT/CONTRACT	DESCRIPTION	DATE
0	6-11-04		

ISSUED FOR PERMIT/CONTRACT
6-11-04

CURRENT ISSUE STATUS:

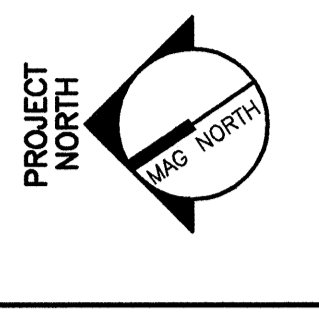

BAKER NEWMAN NOYES
FIT-UP
 PORTLAND, MAINE

PROJECT:
FOURTH FLOOR LIGHTING PLAN

SHEET TITLE:
 SHEET: 1/8" = 1'-0" DATE: 6-11-04

PROJECT MANAGER: JIH GRAPHIC SCALE: 0"

JOB CAP/DRAWN: DJM/LAM

A/E OF RECORD: DJT

SMART CAD FILE: EL01-03137

PROJECT NO.: 03137

SHEET NO.: EL101

A1 FOURTH FLOOR PLAN

1/8" = 1'-0"