

**NOTE:**


1. SEE SHEET E-001 FOR LEGEND AND GENERAL NOTES.

**KEYED NOTES:**

① FURNISH & INSTALL A NEMA LS-30R RECEPTACLE FOR NETWORK RACKS. WIRING TO BE 2-#10 AWG & #10 GND.

**LIGHT FIXTURE SCHEDULE**

TYPE	DESCRIPTION	MFR.	LAMPS	MOUNTING	NOTES
A	2x4 PARABOLIC AIR HANDLING REFLECTOR W/SEMI-SPECULAR 18 CELL LOUVER. 277V	COLUMBIA P424-332G-LD3x6-A-EBB-277	3-F3278 3500K	CEILING RECESSED	PROVIDE MASTER SLAVE CONFIGURATION IN ALL ROOMS HAVING DUAL LEVEL SWITCHING
B	2x4 DIRECT/INDIRECT RECESSED FIXTURE WITH METAL PERFORATED SHIELDING. 277V	COLUMBIA STR24-332G-MPO-EBB-277	3-F3278 3500K	CEILING RECESSED	PROVIDE MASTER SLAVE CONFIGURATION IN ALL ROOMS HAVING DUAL LEVEL SWITCHING
C	2x4 PARABOLIC AIR HANDLING TROFFER W/3" DEEP LOW RIDESCENT SEMI-SPECULAR 18 CELL LOUVER. 277V	FINLITE S12-8"3TB-02-EP-277-AC-CE	3-F3278 3500K	AIR CRAFT CABLE	PROVIDE 15" MOUNTING CABLE. FIXTURE TO BE WIRED TO ALLOW FOR DUAL LEVEL SWITCHING
D	8" ROUND APERTURE DOWNLIGHT W/AMERICAN MATTE REFLECTOR. 277V	PRESCOLITE CP3824EB SERIES	2-26W TRIPLE TUBE	CEILING RECESSED	
D1	8" ROUND APERTURE DOWNLIGHT W/AMERICAN MATTE REFLECTOR. 277V	PRESCOLITE CP3824EB SERIES	2-18W TRIPLE TUBE	CEILING RECESSED	PROVIDE W/DIMMING BALLAST
D	8" ROUND APERTURE DOWNLIGHT W/AMERICAN MATTE REFLECTOR. 277V	PRESCOLITE CP3824EB SERIES	2-26W TRIPLE TUBE	CEILING RECESSED	PROVIDE W/DIMMING BALLAST
E	8" FLUORESCENT STRIP. 277V	COLUMBIA CS8-232-EBB-277	4-F3278 3500K	SURFACE WALL	
F	DECORATIVE PENDANT LIGHT WITH COPPER HOUSING & SATIN ETCHED GLASS CYLINDER. 277V	LURALINE GPS-14-02-E-COP	1-42W CF	PENDANT	PROVIDE EXTENDED PENDANT TO MOUNT TO DECK & PASS DOWN THROUGH GRID.
EM	EMERGENCY EXIT SIGN W/ANTHONY BACK-UP, BLACK HOUSING W/BRUSHED ALUMINUM FACE. 277V	PRESCOLITE DURAMAX SERIES	LED	WALL OR CEILING	
EM	EMERGENCY LIGHTING UNIT. 277V	PRESCOLITE EMAX SERIES	INTEGRAL W/UNIT	WALL	

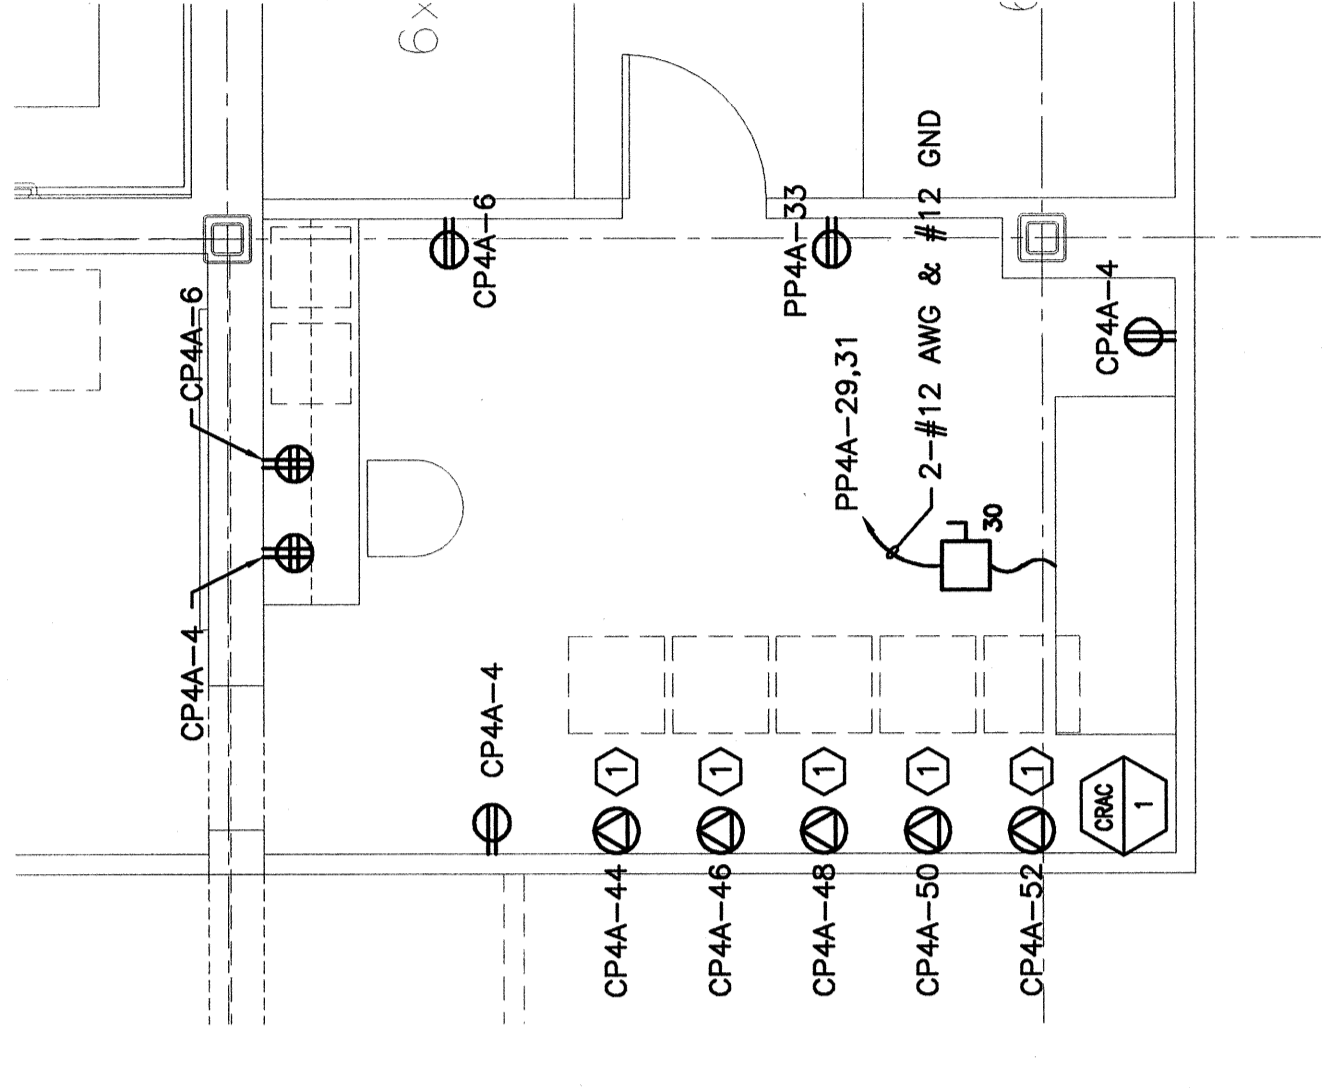

**A14 PART PLAN**  
1/4" = 1'-0"

REV.	0	ISSUED FOR PERMIT/CONTRACT	6-11-04
DESCRIPTION	ISSUED FOR PERMIT/CONTRACT <b>6-11-04</b>		
CURRENT ISSUE STATUS:	ARCHITECTURE ENGINEERING PLANNING <b>SM RT</b> 144 Fore Street/P.O. Box 618 Portland, Maine 04104 tel. (207) 772-3846 fax. (207) 772-1070		
PROJECT:	BAKER NEWMAN NOYES FIT-UP PORTLAND, MAINE		
SHEET TITLE:	LIGHT FIXTURE SCHEDULE & PART PLAN		
SCALE:	AS NOTED	DATE:	6-11-04
PROJECT MANAGER:	JLH	GRAPHIC SCALE:	0" = 1'
JOB CAP/DRAWN:	DJM/LAM		
A/E OF RECORD:	DJT	SHEET No.	E-601
SMRT CAD FILE:	E-601-03137	PROJECT No.	03137