

**GENERAL NOTES:**

- DO NOT SCALE THE DRAWINGS.
- ALL SEALANT, FIRE STOPPING, AND SMOKE STOPPING ASSEMBLIES SHALL BE U.L. RATED.
- DIMENSIONS ARE FACE OF MASONRY, AND CENTERLINE OF STUD PARTITIONS, UNLESS INDICATED OTHERWISE.
- REFER TO SHEET 61003 FOR TYPICAL MOUNTING HEIGHTS OF PLUMBING FIXTURES, RESTROOM ACCESSORIES & MISCELLANEOUS ITEMS.
- REFER TO 61002 FOR TOP OF WALL DETAILS.
- REFER TO ALL CONSTRUCTION DOCUMENTS FOR REQUIREMENTS WHICH MAY AFFECT THE WORK IN ANOTHER AND COORDINATE WORK.
- REFERENCE DETAILS FOR ADDITIONAL DIMENSIONAL INFORMATION.
- DOOR JAMB SHALL BE LOCATED 6" FROM CORNER IN STUD PARTITIONS, UNLESS INDICATED OTHERWISE.
- REFER TO AE402 FOR TOILET ACCESSORIES.
- ALL EXTERIOR COLUMNS TO BE FIRE WRAPPED PRIOR TO WALL CONSTRUCTION (UNO). VAPOR BARRIER TO BE CONTINUOUS AROUND COLUMN AND INTEGRATED WITH WALL SYSTEM VAPOR BARRIER.


**LEGEND:**

--- LATERAL BRACING RE: STRUCT.

REV.	ISSUED FOR CONSTRUCTION DESCRIPTION	DATE
0		12-15-03

**ISSUED FOR CONSTRUCTION**  
12-15-03

CURRENT ISSUE STATUS:

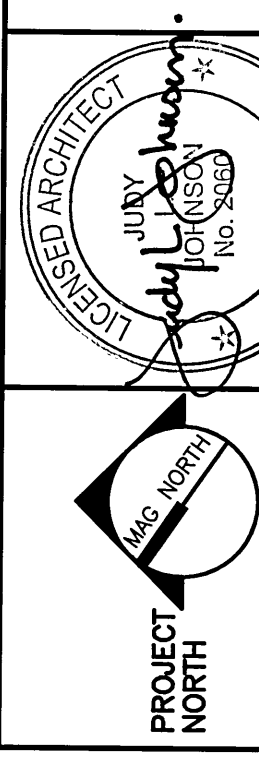


SMRT  
ARCHITECTURE ENGINEERING PLANNING  
144 Fore Street P.O. Box 618  
Portland, Maine 04104  
tel. (207) 772-3846  
fax. (207) 772-1070

**FORE STREET  
OFFICE BUILDING**  
PORTLAND, MAINE

**SECOND FLOOR  
PLAN**

SHEET TITLE:	1/8" = 1'-0"	DATE:	12-15-03
SCALE:	1/8" = 1'-0"	GRAPHIC SCALE:	0'
PROJECT No.:	AE102-03087	PROJECT No.:	AE102
PROJECT MANAGER:	JJJ	PROJECT No.:	AE102
JOB CAP/DRAWN:	RJJ	PROJECT No.:	AE102
A/E OF RECORD:	JJJ	PROJECT No.:	AE102
SMRT CAD FILE:	AE102-03087	PROJECT No.:	AE102
PROJECT No.:	03087	PROJECT No.:	AE102

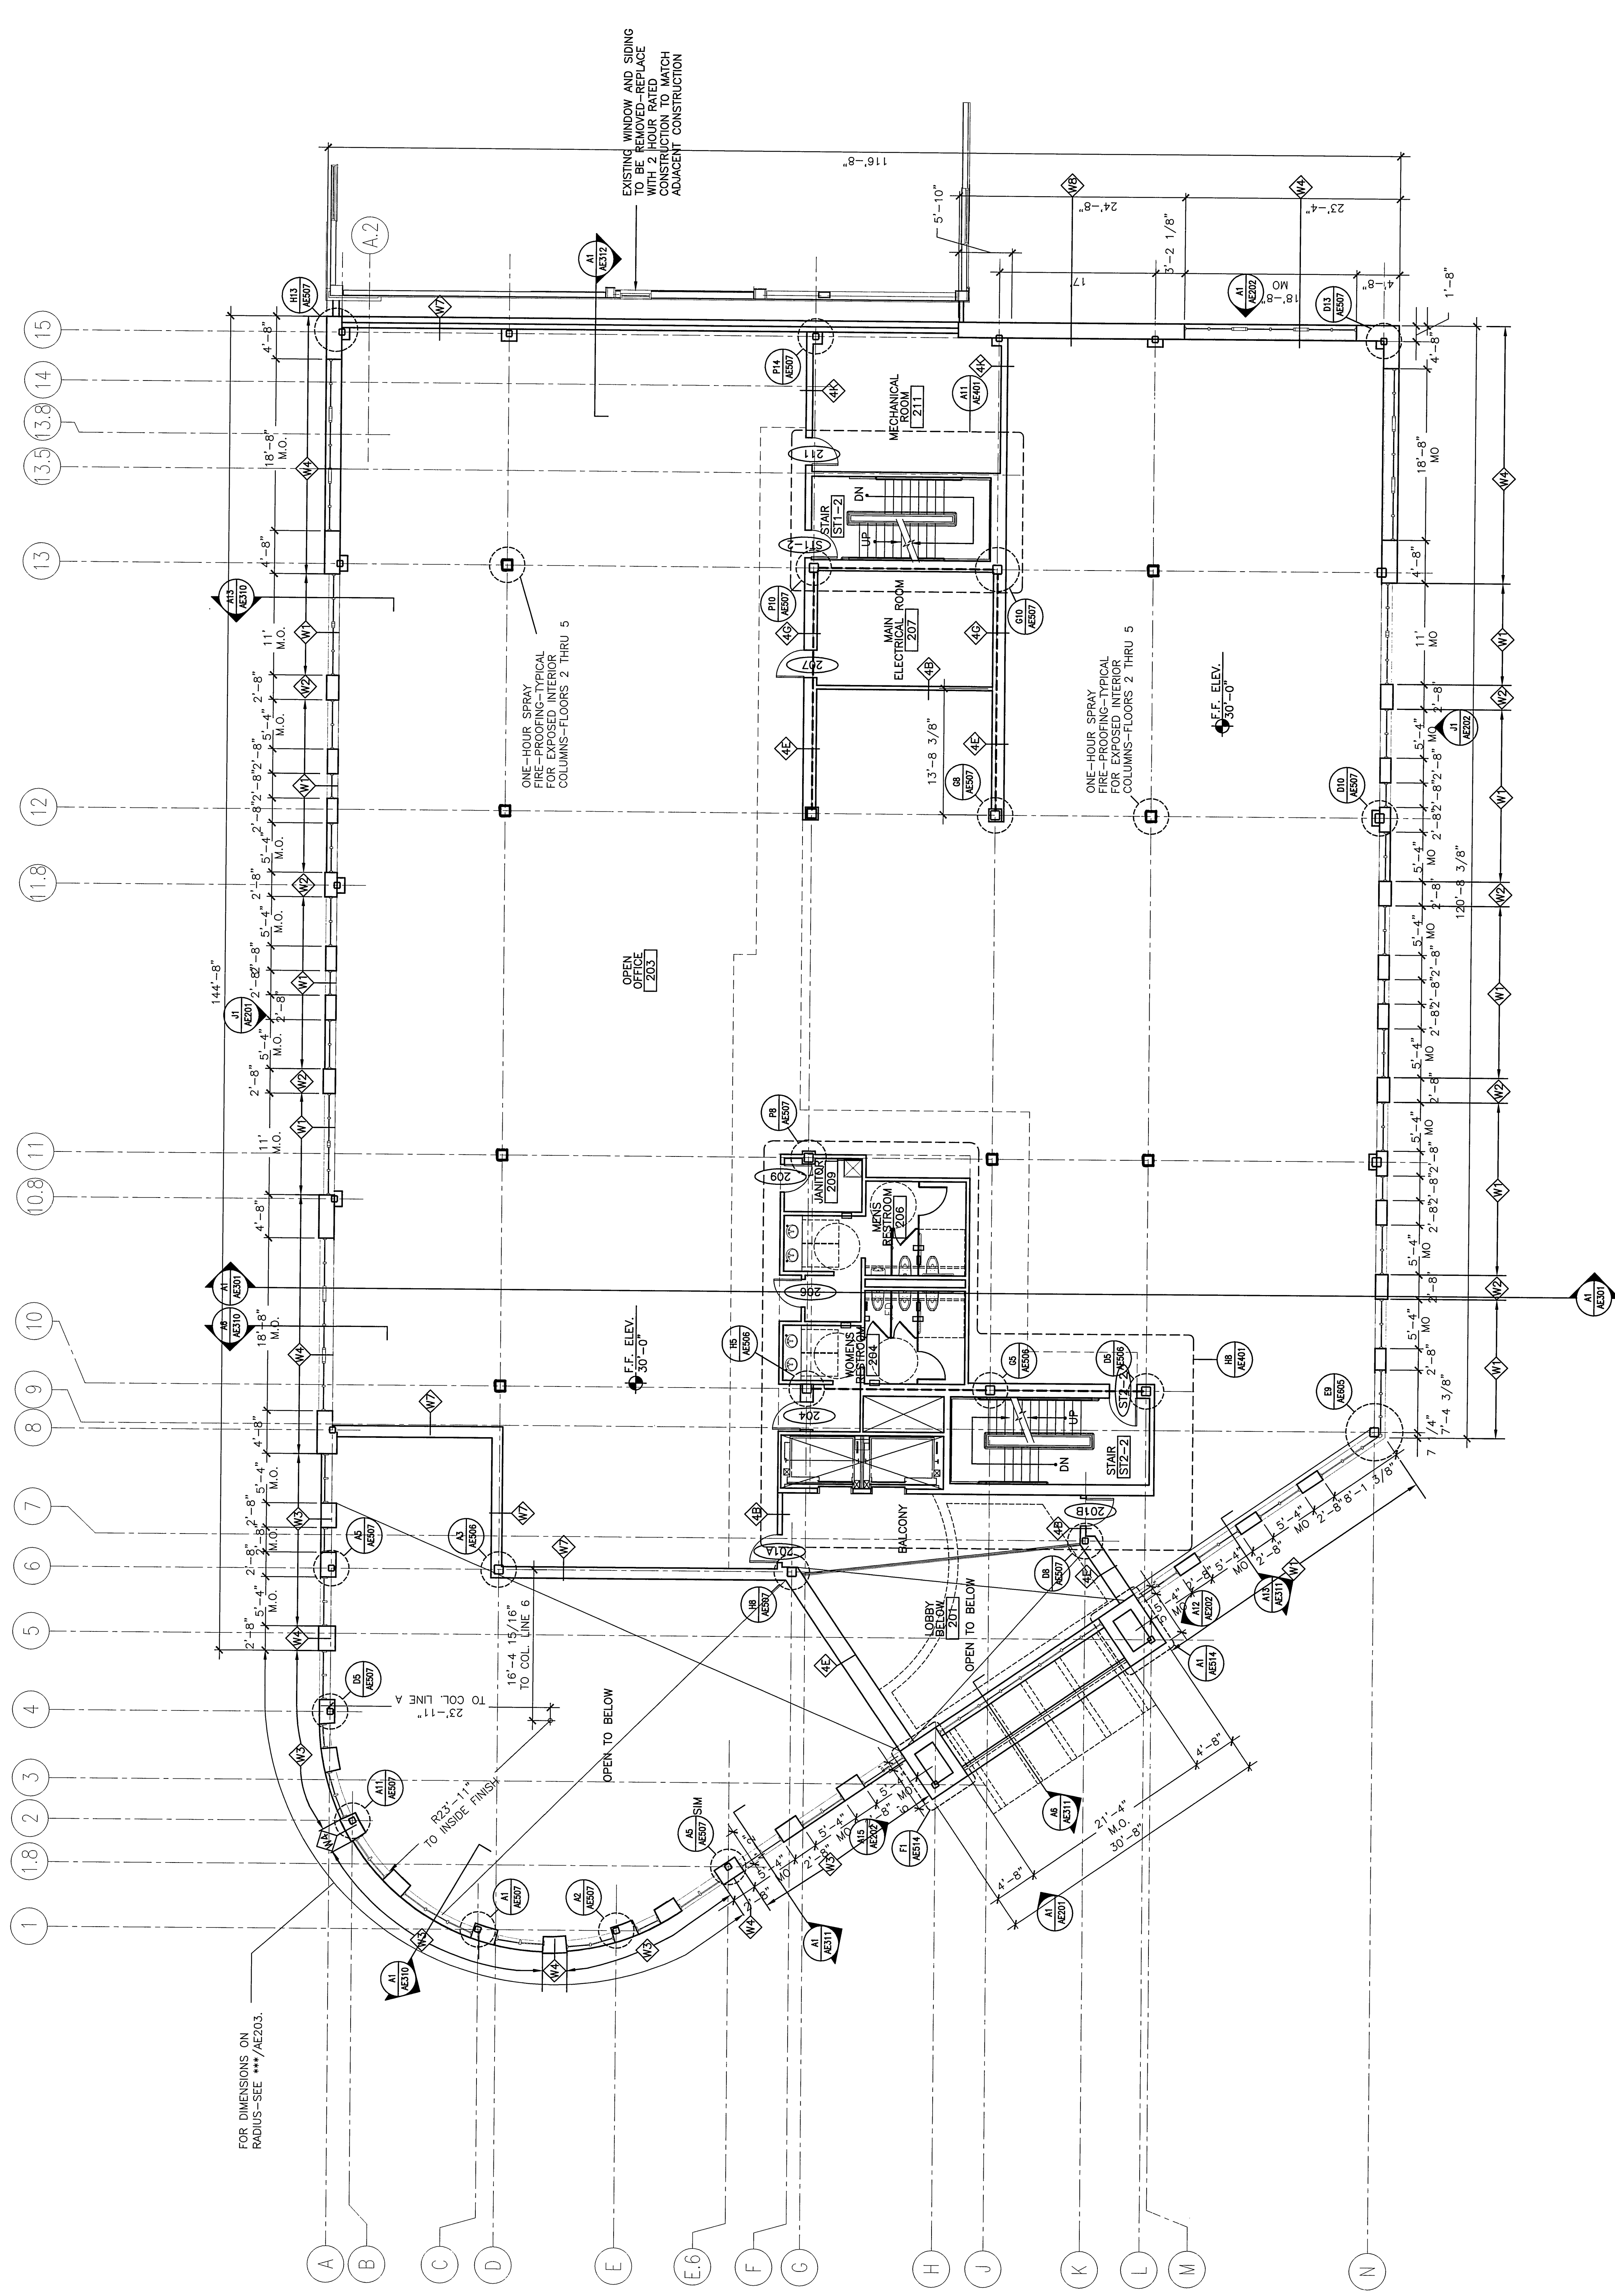

**A1 SECOND FLOOR PLAN**

1/8" = 1'-0"