


GENERAL NOTES:

- DO NOT SCALE THE DRAWINGS.
- ALL SEALANT, FIRE STOPPING, AND SMOKE STOPPING ASSEMBLIES SHALL BE U.L. RATED.
- DIMENSIONS ARE FACE OF MASONRY, AND CENTERLINE OF STUD PARTITIONS, UNLESS INDICATED OTHERWISE.
- REFER TO SHEET G003 FOR TYPICAL MOUNTING HEIGHTS OF PLUMBING FIXTURES, RESTROOM ACCESSORIES & MISCELLANEOUS ITEMS.
- REFER TO G002 FOR TOP OF WALL DETAILS.
- REFER TO ALL CONSTRUCTION DOCUMENTS FOR REQUIREMENTS WHICH MAY AFFECT THE WORK IN ANOTHER AND COORDINATE WORK.
- REFERENCE DETAILS FOR ADDITIONAL DIMENSIONAL INFORMATION.
- DOOR JAMBS SHALL BE LOCATED 6" FROM CORNER IN STUD PARTITIONS, UNLESS INDICATED OTHERWISE.
- REFER TO A6402 FOR TOILET ACCESSORIES.
- ALL EXTERIOR COLUMNS TO BE FIRE WRAPPED PRIOR TO WALL CONSTRUCTION (UNO). VAPOR BARRIER TO BE CONTINUOUS ABOUT COLUMNS AND INTEGRATED WITH WALL SYSTEM VAPOR BARRIER.

LEGEND:


--- LATERAL BRACING RE: STRUCT.

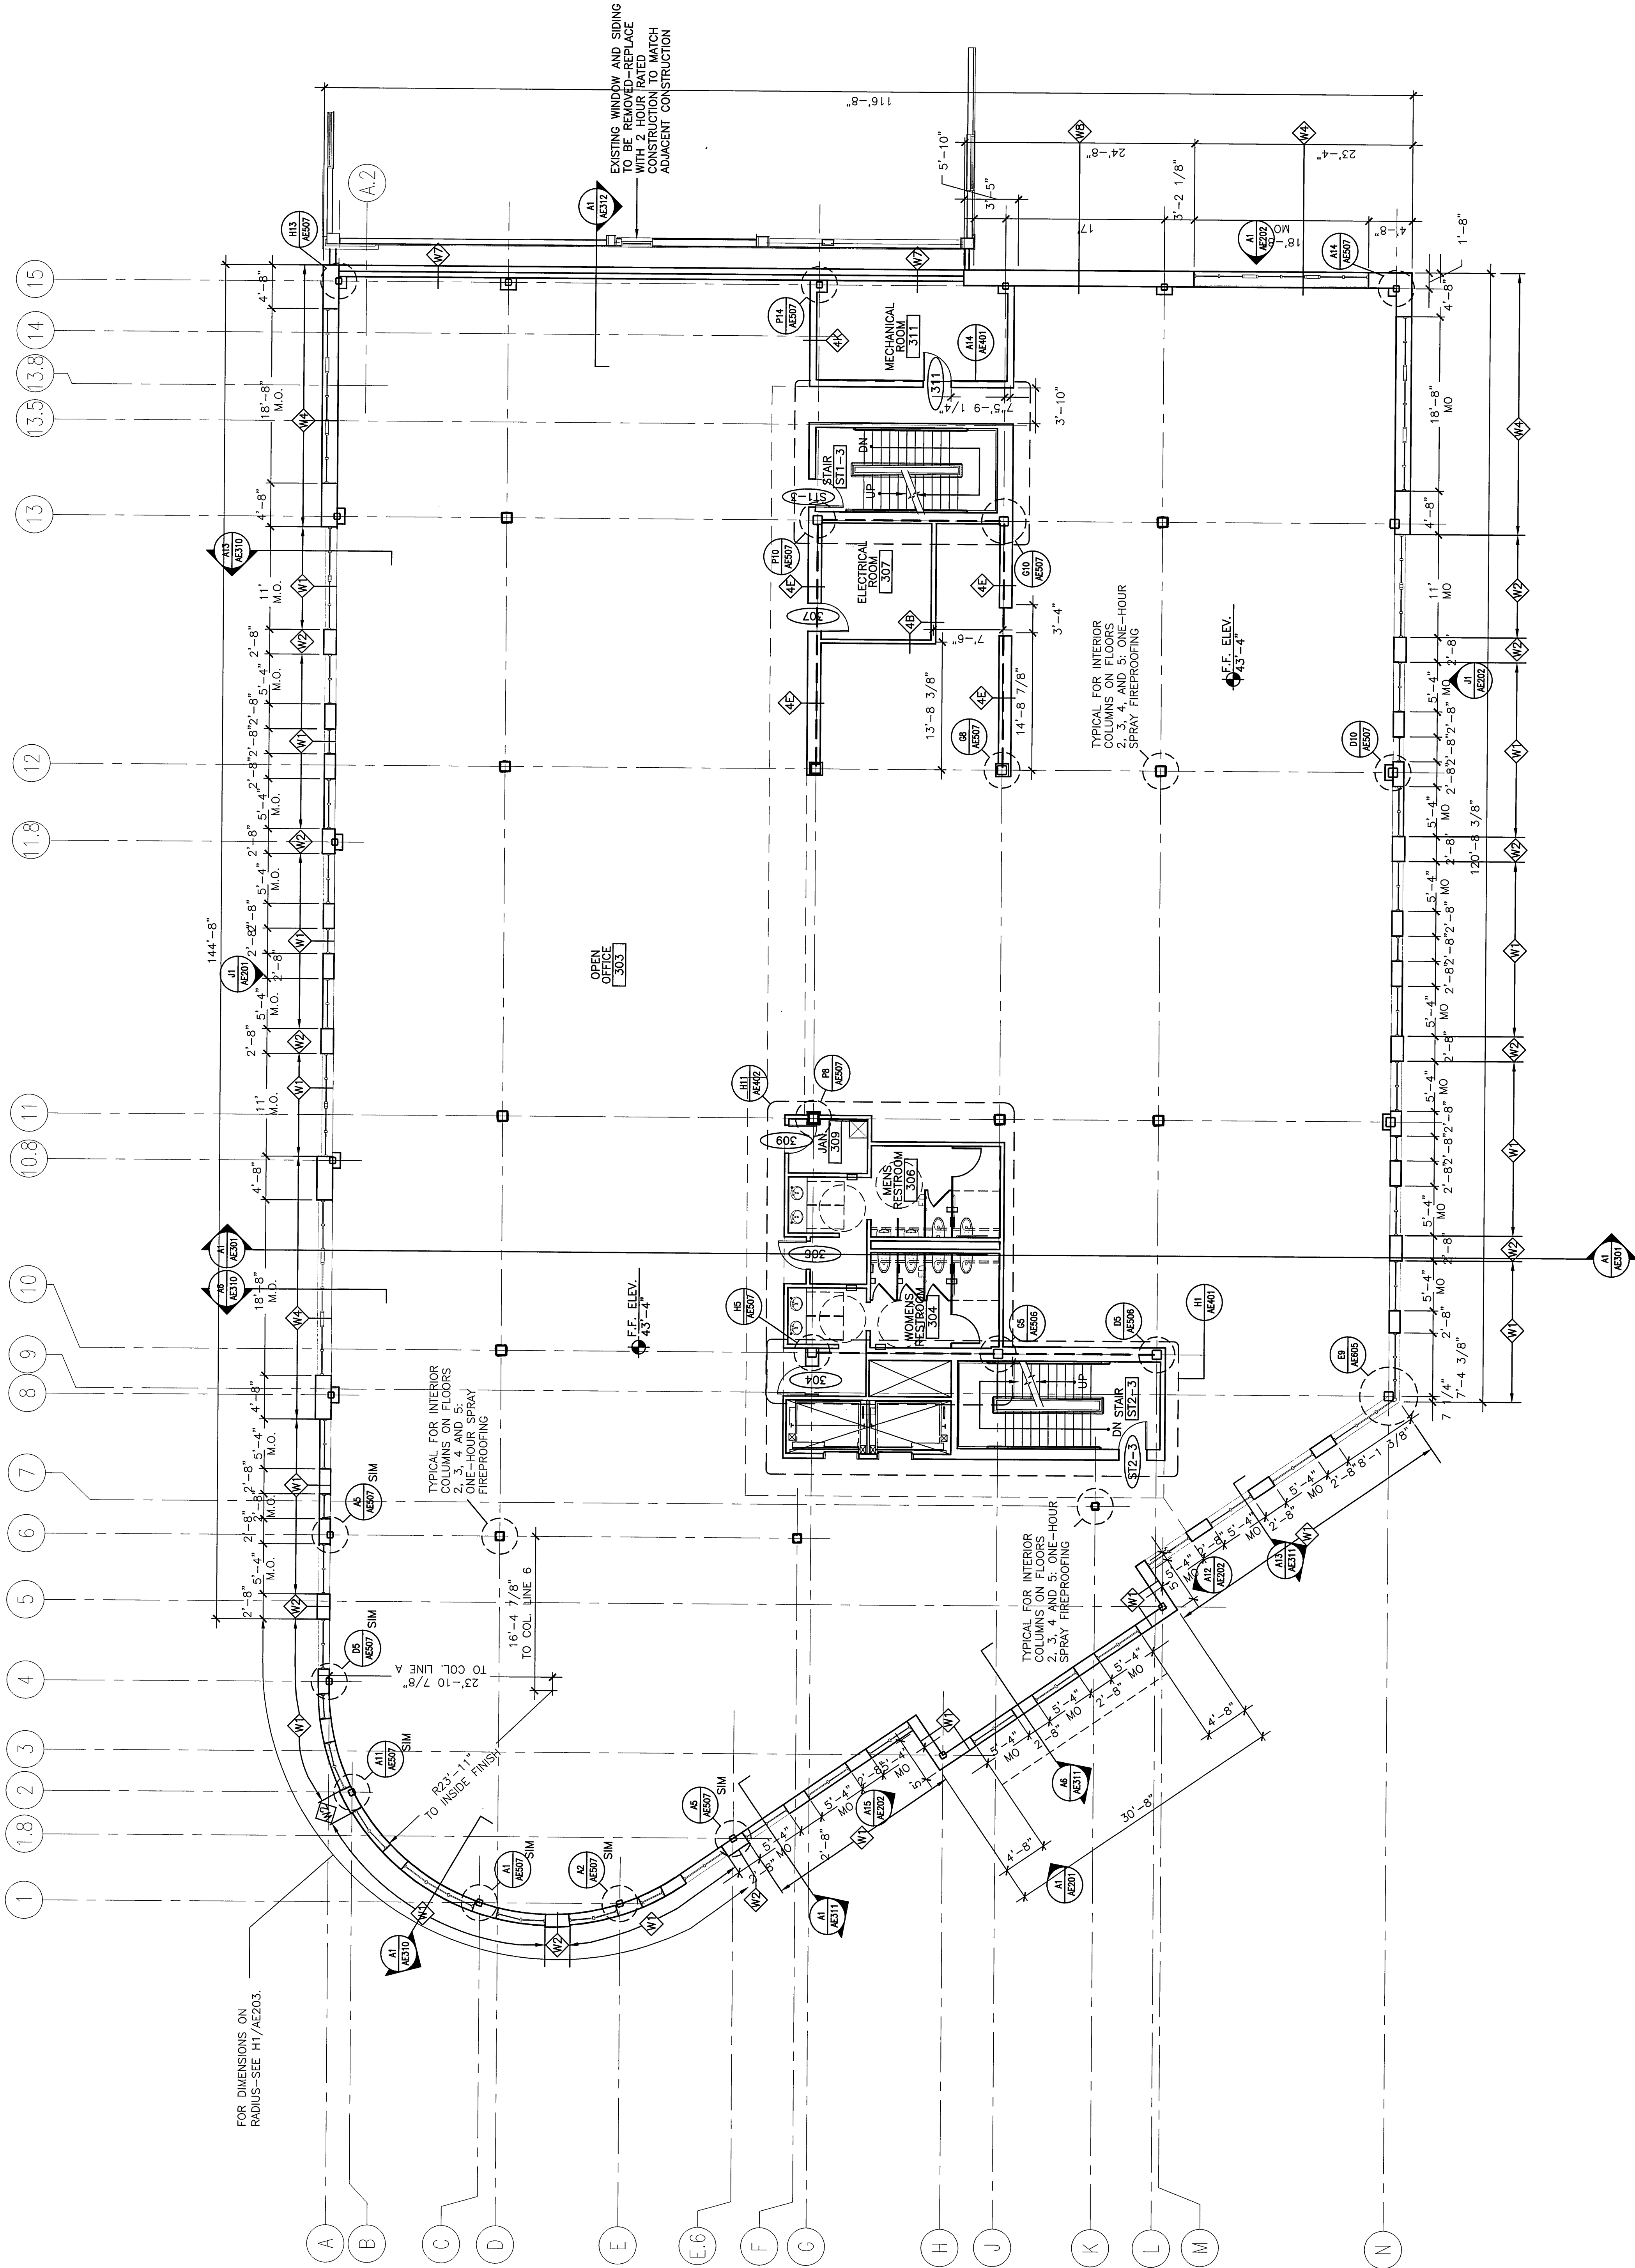

REV.	ISSUED FOR CONSTRUCTION	DESCRIPTION	DATE
0			12-15-03

ISSUED FOR CONSTRUCTION
12-15-03

CURRENT ISSUE STATUS:

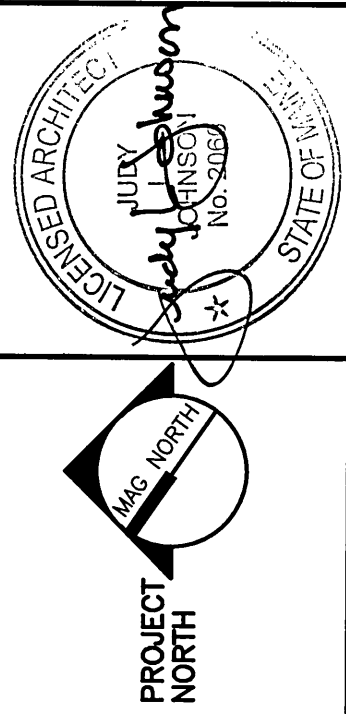

FORE STREET
OFFICE BUILDING
PORTLAND, MAINE

THIRD FLOOR
PLAN

SHEET TITLE:	1/8"=1'-0"	DATE:	12-15-03
SCALE:	1/8"=1'-0"	GRAPHIC SCALE:	0'
PROJECT MANAGER:	JLJ	JOB CAP/DRAWN:	RJL
A/E OF RECORD:	JLJ	SHEET No.	AE103
SMART CAD FILE:	AE103-03087	PROJECT No.	03087

A1 THIRD FLOOR PLAN

1/8"=1'-0"