


**GENERAL NOTES:**

- DO NOT SCALE THE DRAWINGS.
- ALL SEALANT, FIRE STOPPING, AND SMOKE STOPPING ASSEMBLIES SHALL BE U.L. RATED.
- DIMENSIONS ARE FACE OF MASONRY, AND CENTERLINE OF STUD PARTITIONS, UNLESS INDICATED OTHERWISE.
- REFER TO SHEET G003 FOR TYPICAL MOUNTING HEIGHTS OF PLUMBING FIXTURES, RESTROOM ACCESSORIES & MISCELLANEOUS ITEMS.
- REFER TO G002 FOR TOP OF WALL DETAILS.
- REFER TO ALL CONSTRUCTION DOCUMENTS FOR REQUIREMENTS WHICH MAY AFFECT THE WORK IN ANOTHER AND COORDINATE WORK.
- REFERENCE DETAILS FOR ADDITIONAL DIMENSIONAL INFORMATION.
- DOOR SWINGS SHALL BE LOCATED 6" FROM CORNER IN STUD PARTITIONS, UNLESS INDICATED OTHERWISE.
- REFER TO AE402 FOR TOILET ACCESSORIES.
- ALL EXTERIOR COLUMNS TO BE FIRE WRAPPED PRIOR TO WALL CONSTRUCTION (UNO). VAPOR BARRIER TO BE CONTINUOUS COLUMN AND INTEGRATED WITH WALL SYSTEM VAPOR BARRIER.

**LEGEND:**


--- LATERAL BRACING RE: STRUCT.

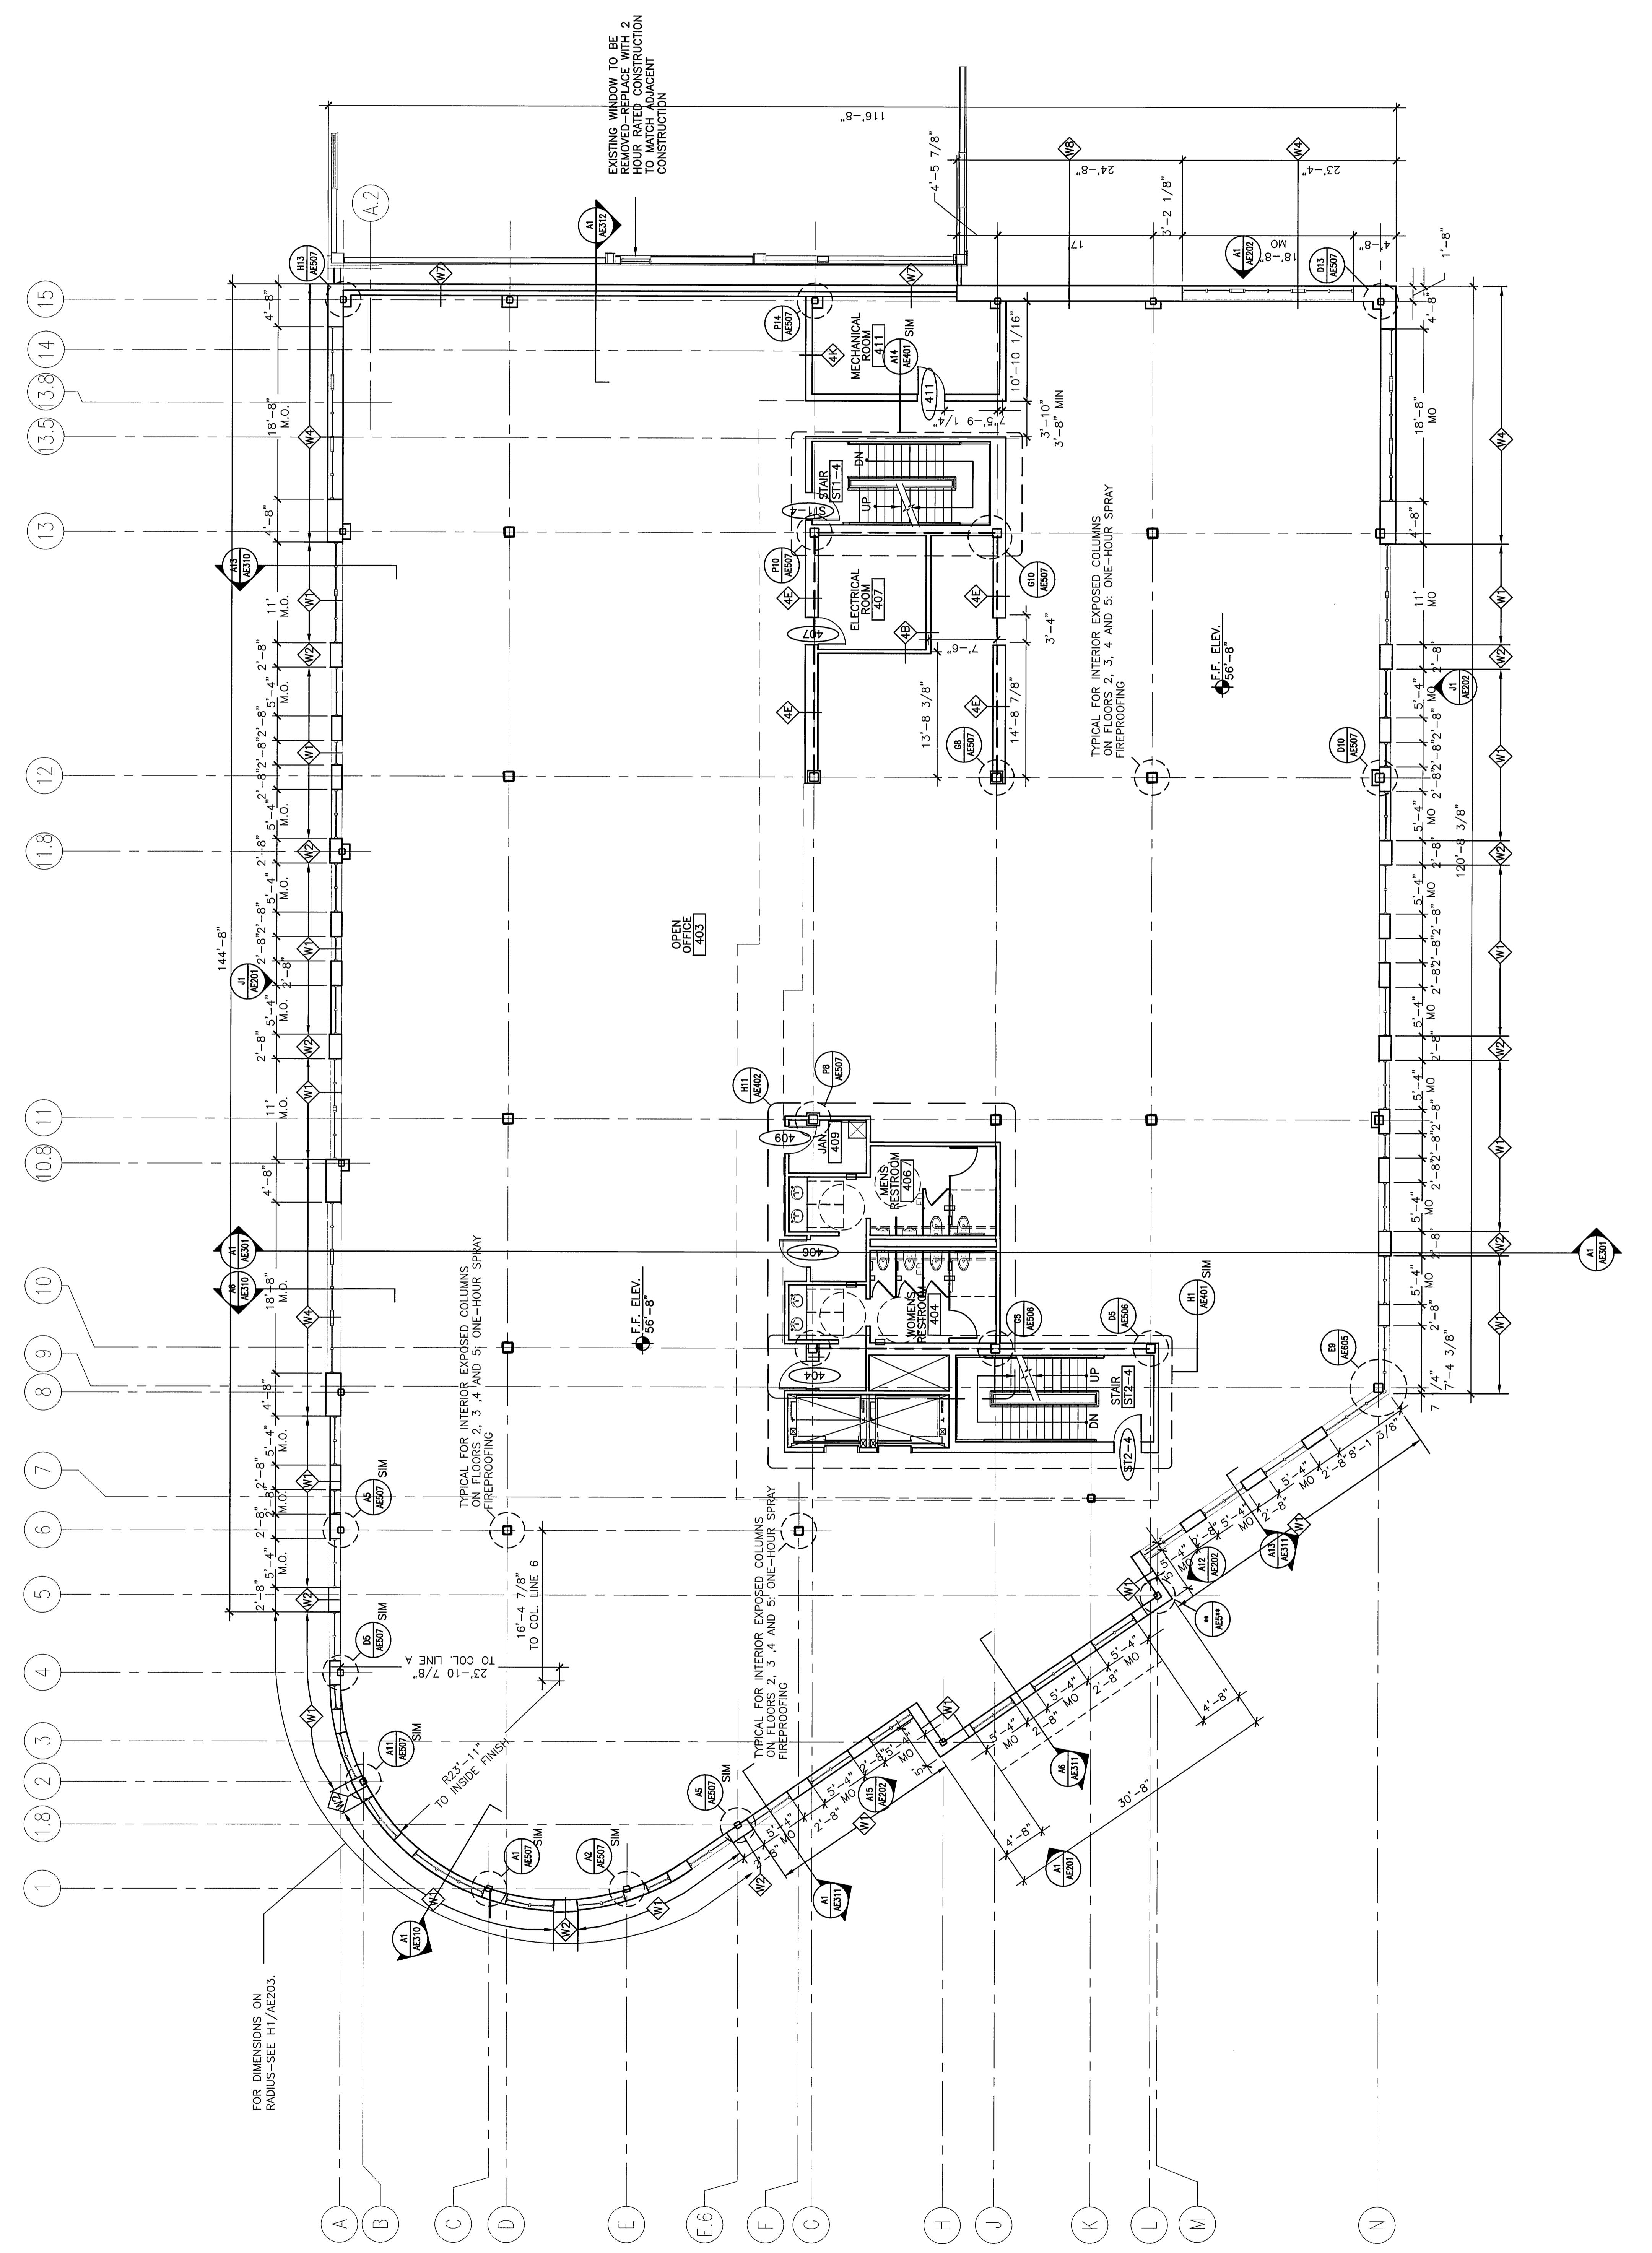

REV.	DESCRIPTION	DATE
0	ISSUED FOR CONSTRUCTION	12-15-03

**ISSUED FOR CONSTRUCTION**  
12-15-03

CURRENT ISSUE STATUS:

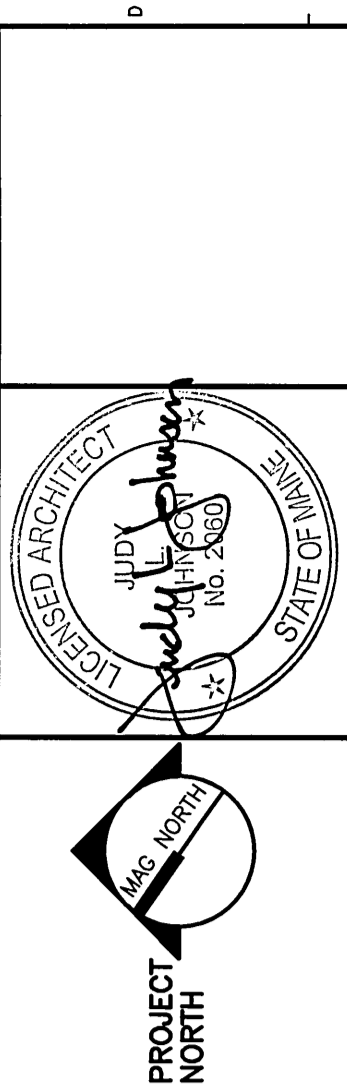

ARCHITECTURE ENGINEERING PLANNING  
SMRT  
144 Fore Street/P.O. Box 618  
Portland, Maine 04104  
tel. (207) 772-3846  
fax. (207) 772-1070

**FORE STREET  
OFFICE BUILDING**  
PORTLAND, MAINE

**FOURTH FLOOR  
PLAN**

SHEET TITLE:	1/8"=1'-0"	DATE:	12-15-03
SCALE:	1/8"=1'-0"	GRAPHIC SCALE:	0' 1'
PROJECT MANAGER:	JLJ		
JOB CAP/DRAWN:	JLJ		
A/E OF RECORD:	JLJ		
SMART CAD FILE:	AE104-03087	SHEET No.	AE104
PROJECT No.	03087		

**FOURTH FLOOR PLAN**

1/8"=1'-0"