



E.S. BOULOS CO
ELECTRICAL CONTRACTORS

NOTE:
1. SEE SHEET E-001 FOR LEGEND AND GENERAL NOTES.



KEYED NOTES:

- ① MOUNT LIGHT FIXTURE 7'-6" ABOVE LANDING AND EMERGENCY LIGHTING UNIT AT 8'-6" ABOVE LANDING.
- ② SEE SHEET EL101 FOR LIGHTS CONTROLLED BY SWITCHES SHOWN ON LOWER PARKING LEVEL.
- ③ DOWNLIGHT TO BE CONTROLLED BY AN EXTERIOR WALL MOUNTED PHOTOCELL.

REV.	ISSUED FOR CONSTRUCTION	DESCRIPTION	DATE
0			12-15-03

ISSUED FOR CONSTRUCTION
12-15-03

CURRENT ISSUE STATUS:

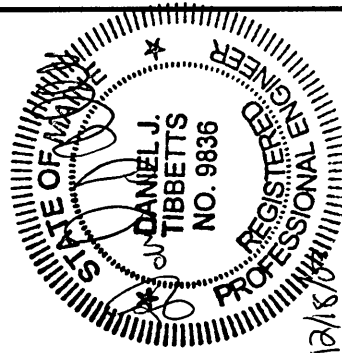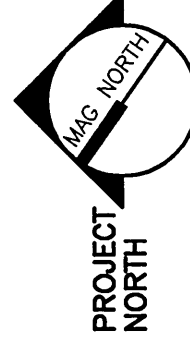


SMART
144 Fore Street P.O. Box 618
Portland, Maine 04104
tel. (207) 772-3846
fax. (207) 772-1070

PROJECT:
**FORE STREET
OFFICE BUILDING**
PORTLAND, MAINE

SHEET TITLE:
**LOWER PARKING
LEVEL LIGHTING PLAN**

SCALE:	1/8"=1'-0"	DATE:	12-15-03
PROJECT MANAGER:	JLJ	GRAPHIC SCALE:	0" 1"

JOB CAP/DRAWN:	RLJ/LAM
A/E OF RECORD:	DJT
SMART CAD FILE:	EL100-03087
PROJECT No.	03087
SHEET No.	EL100

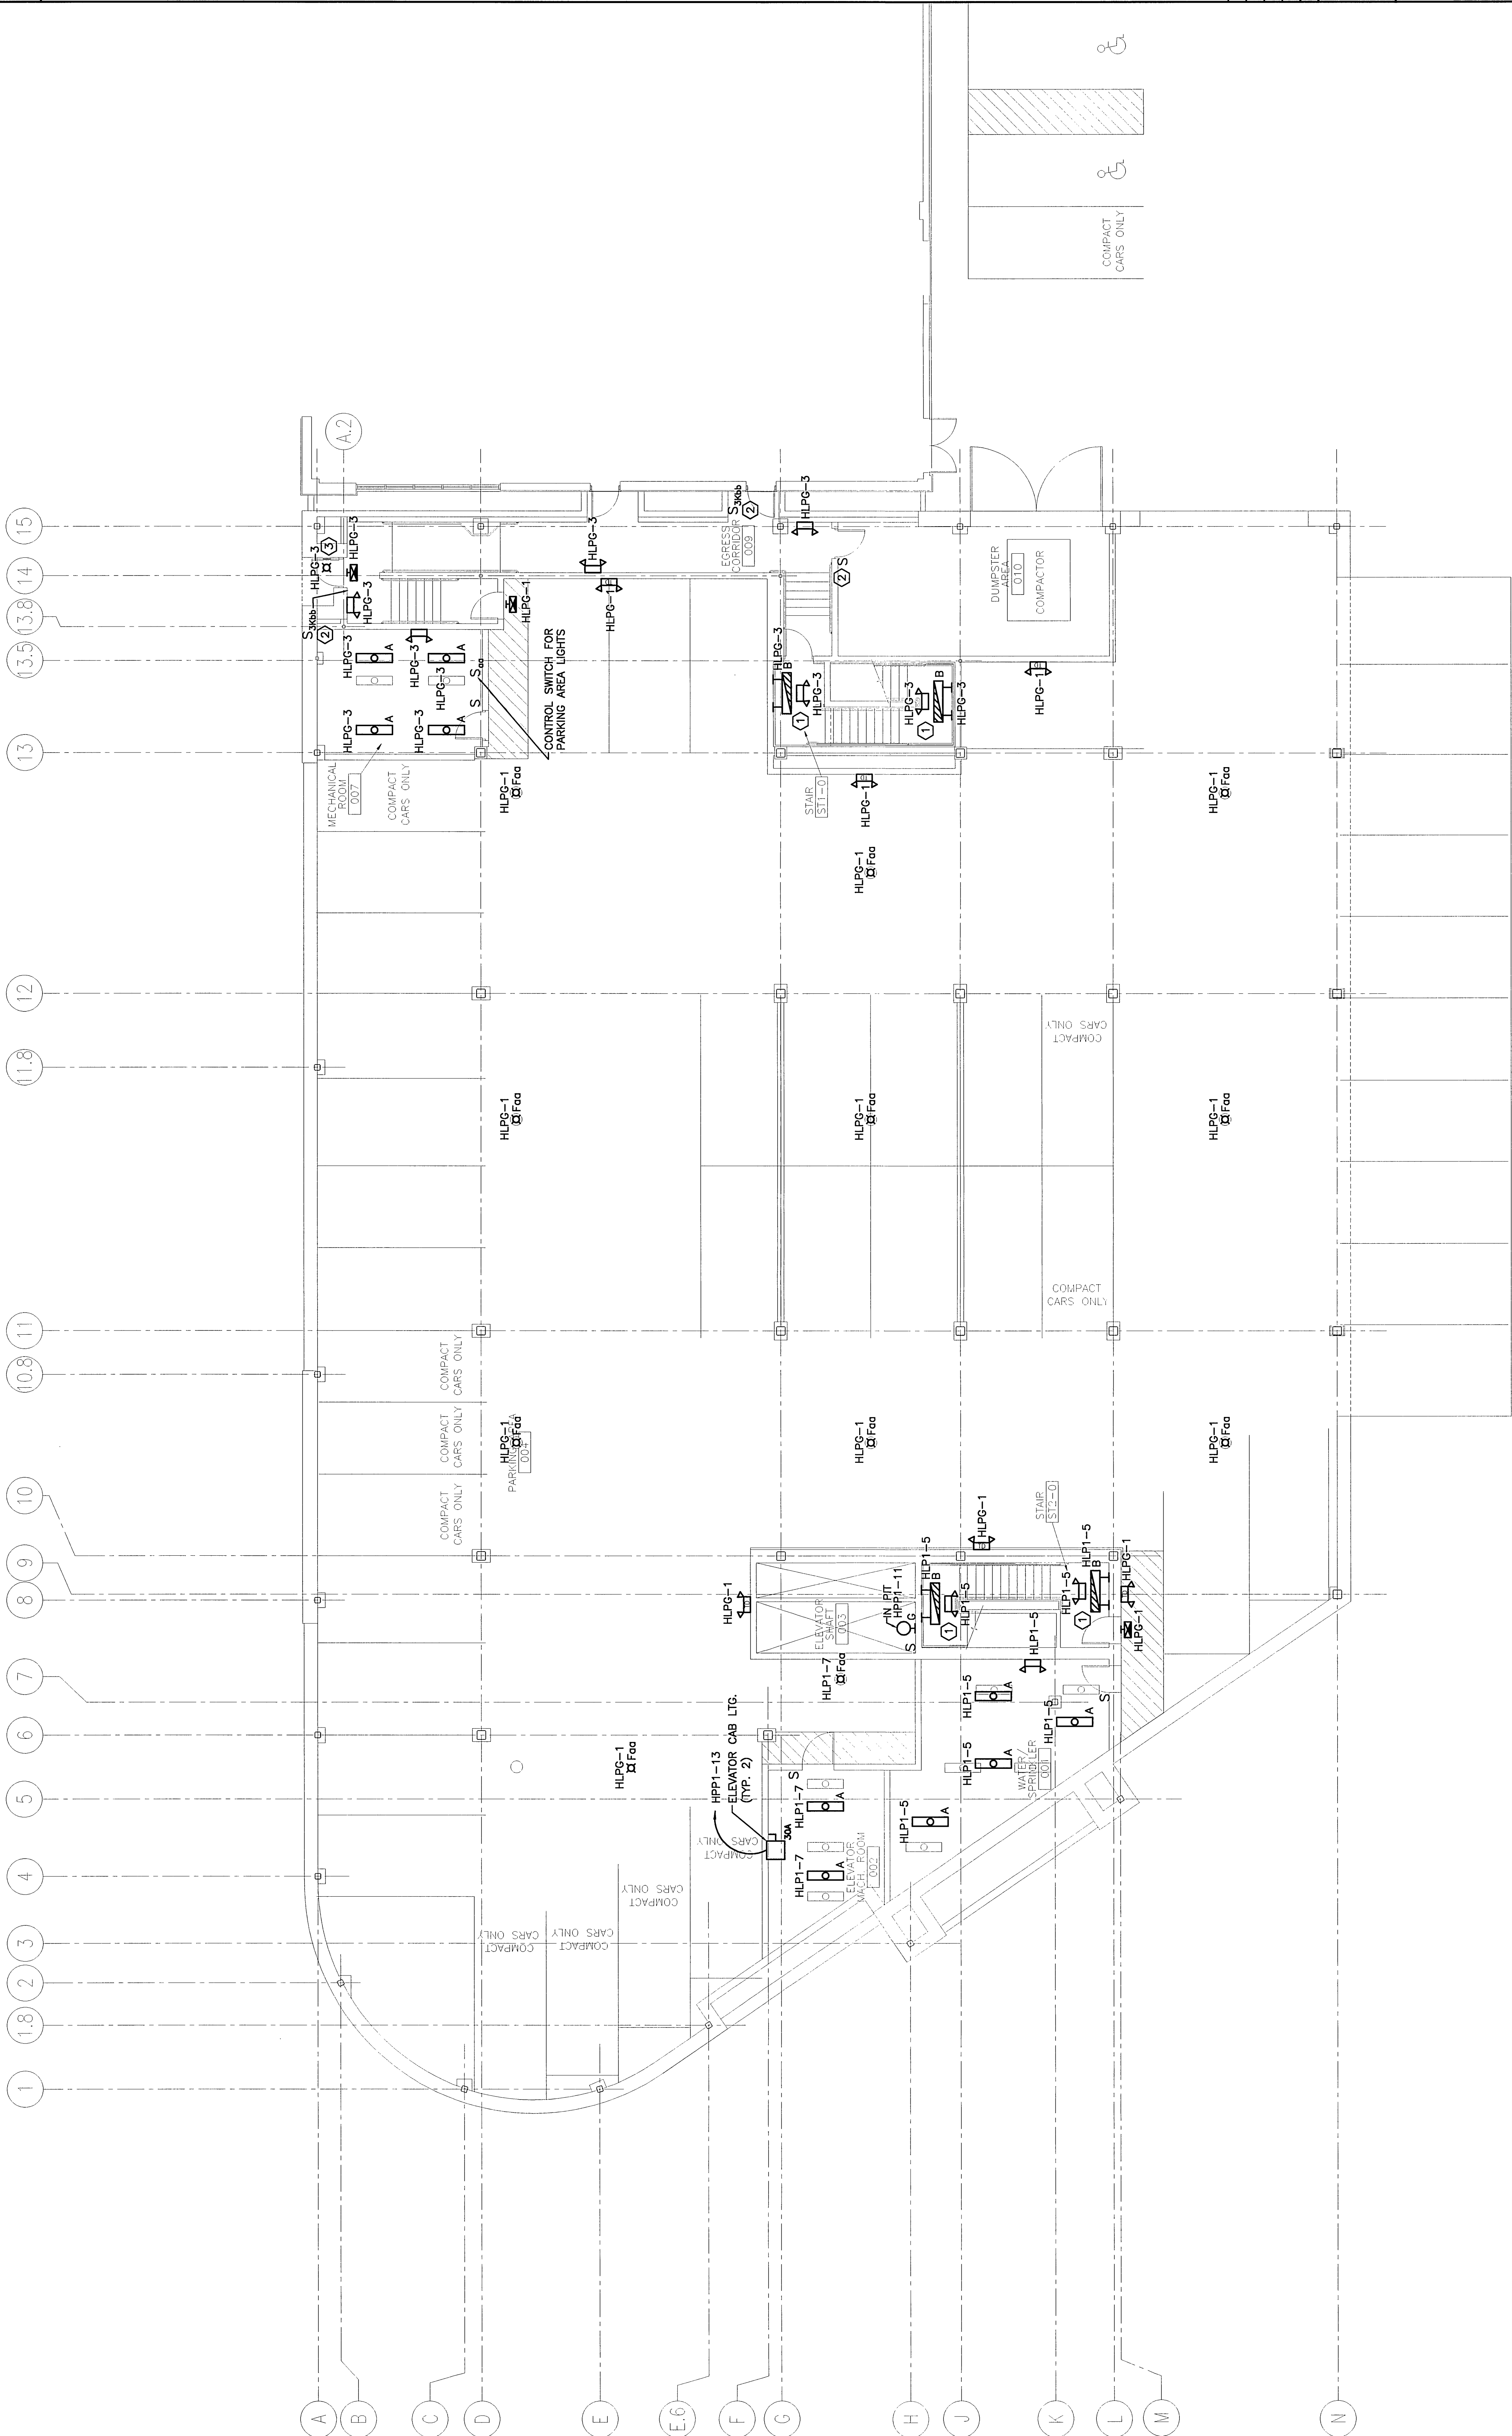

A1 LOWER PARKING LEVEL PLAN

1/8"=1'-0"